


TPOLOGY 12

Mixed Use/Ground Floor Retail-Restaurant

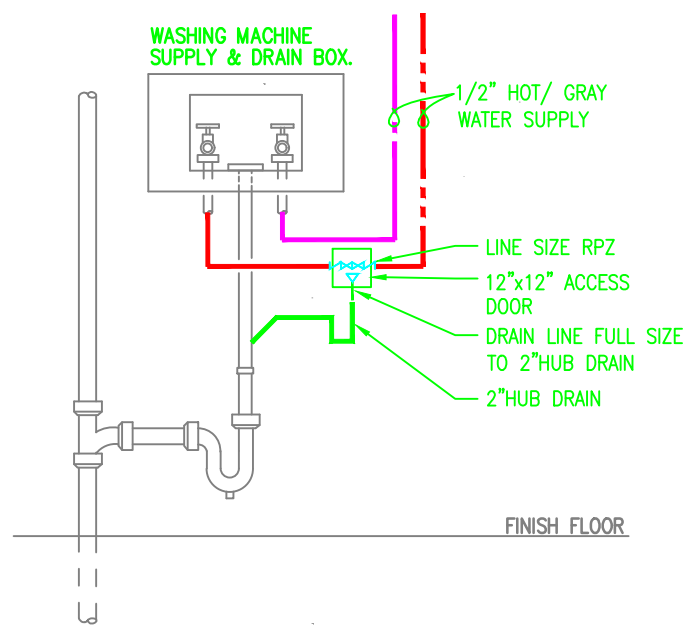

RPZ/HUB DRAIN @ WASHER BOX
SCALE: NOT TO SCALE

PLUMBING LEGEND	
	DOMESTIC WATER SUPPLY PIPING
	GRAY WATER SUPPLY PIPING
	DOMESTIC WATER SUPPLY PIPING SIZE REDUCTION




Architecture Planning Interiors Research
5307 E Markingbird Lane, Suite 220
Dallas, Texas 75206
Telephone 214-242-7650
Fax 214-242-7655
E-mail info@lrk.com

Multi-Family Plan for:
Gables Residential
6850 Austin Center Blvd, Suite 200
Austin, Texas 78731



Issues and Revisions		
No.	Date	Issues and Revisions
01	11.10.06	PERMIT SET
	03.28.07	PERMIT RESUBMITTAL

© 2006 Looney Ricks Kiss Architects, Inc.
Drawings, written material, and design concepts shall not be used or reproduced in whole or part in any form or format without prior written consent of Looney Ricks Kiss Architects, Inc. Do not scale drawings. Use given dimensions only. If not shown, verify correct dimensions with the Architect. Contractor shall check and verify all dimensions and conditions at job site.


Seal

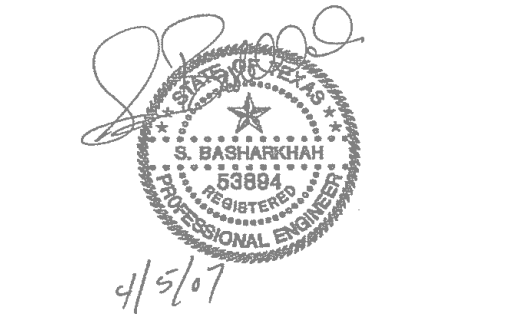

Project Number: 01.06006.00
Project Name:
5th Street Commons
5th Street
Austin, Texas
Drawing Name:
Drawn By:
Checked By:

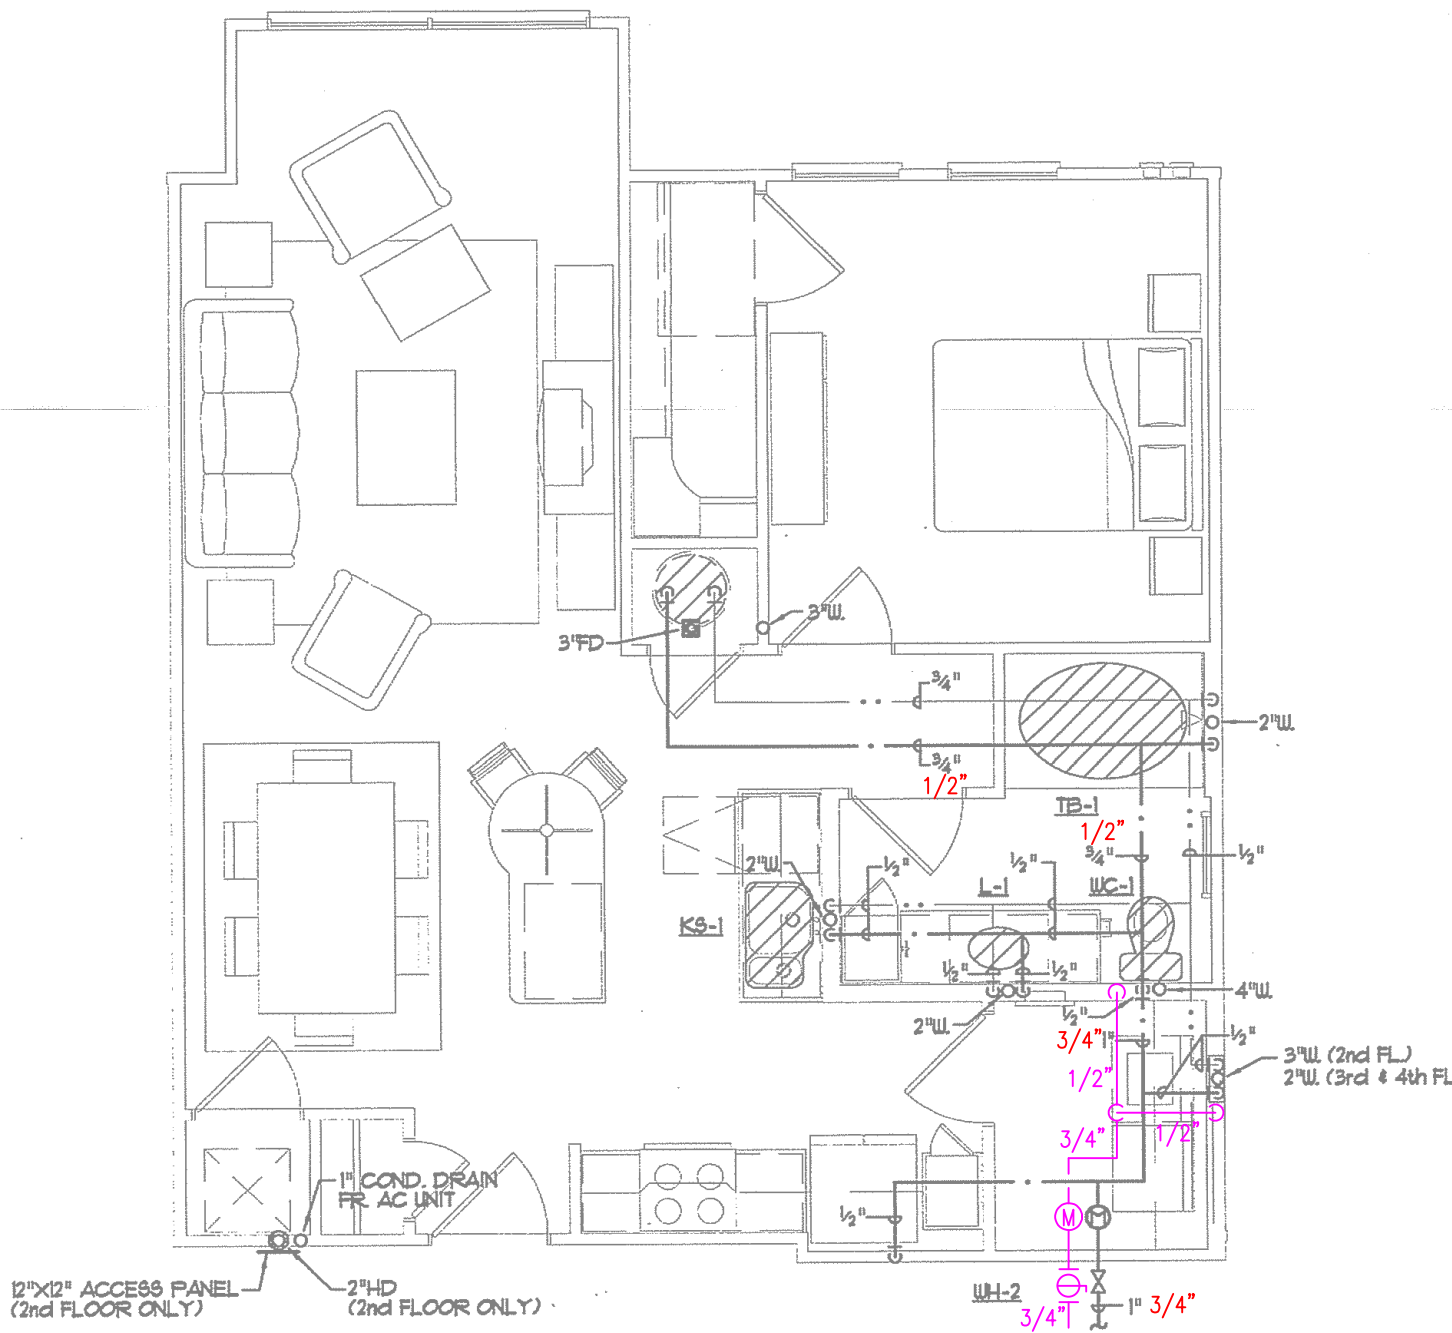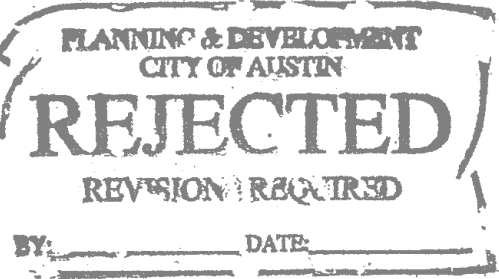


1 UNIT PLAN - A1 - PLUMBING
SCALE: 1/4" = 1'-0"

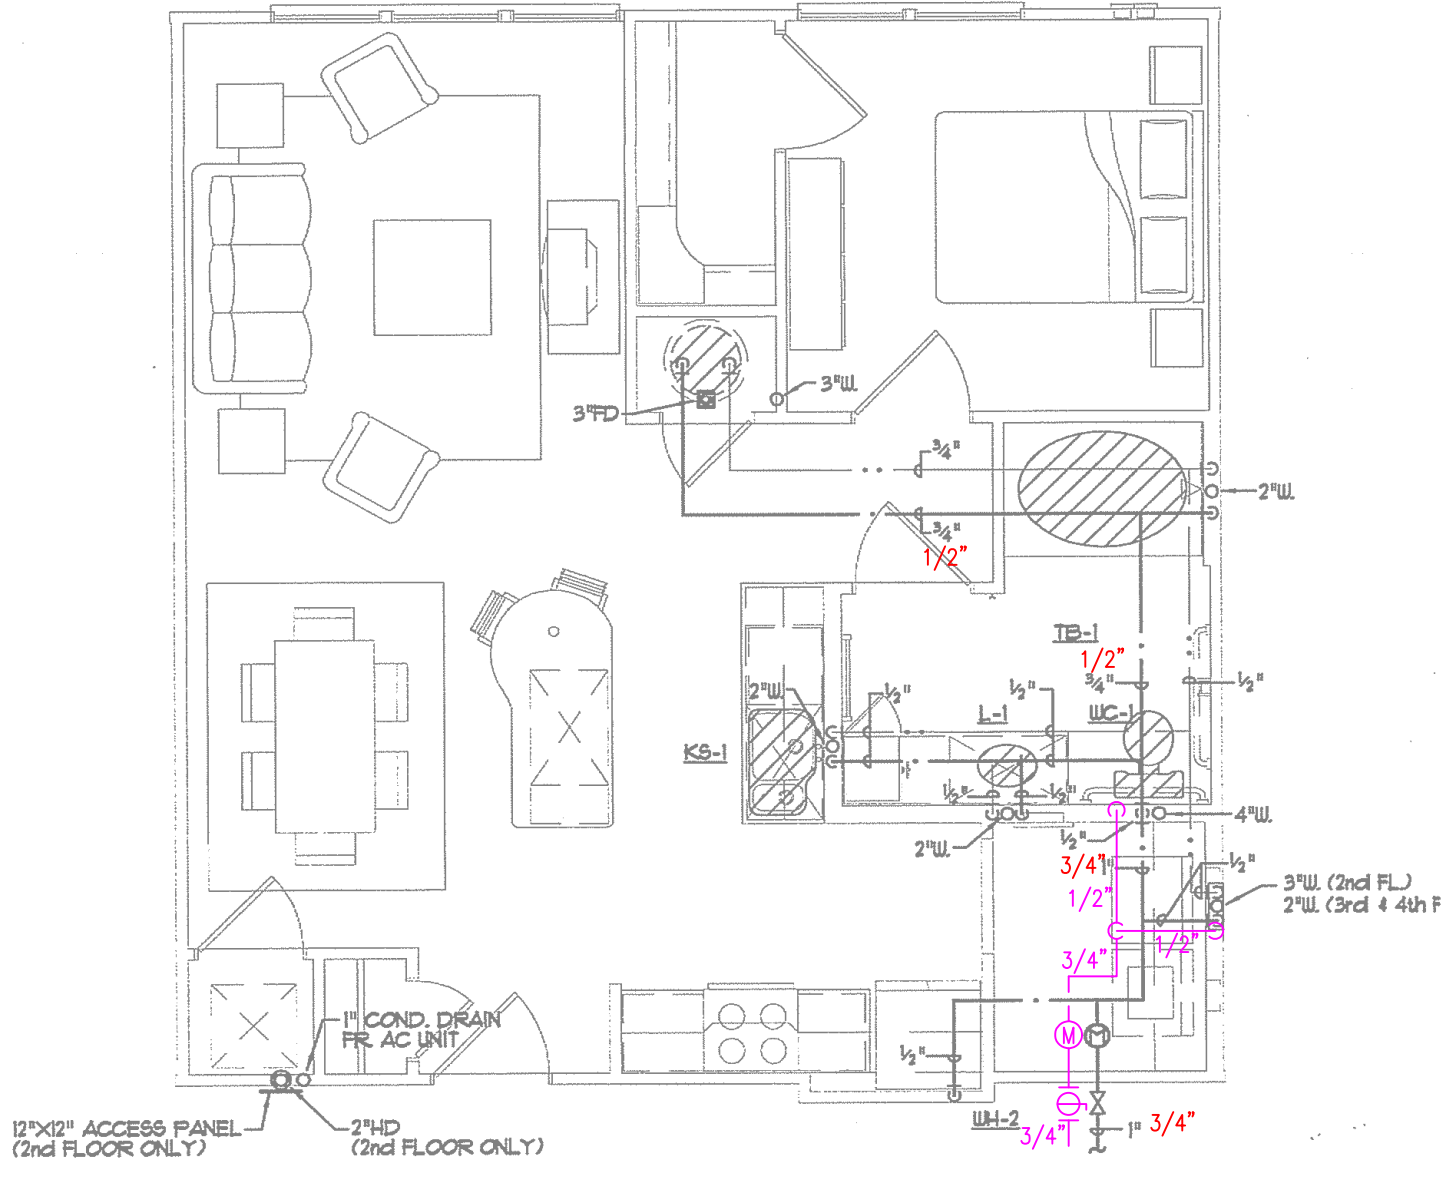


2 UNIT PLAN - A1 ANSI TYPE A - PLUMBING
SCALE: 1/4" = 1'-0"



P102

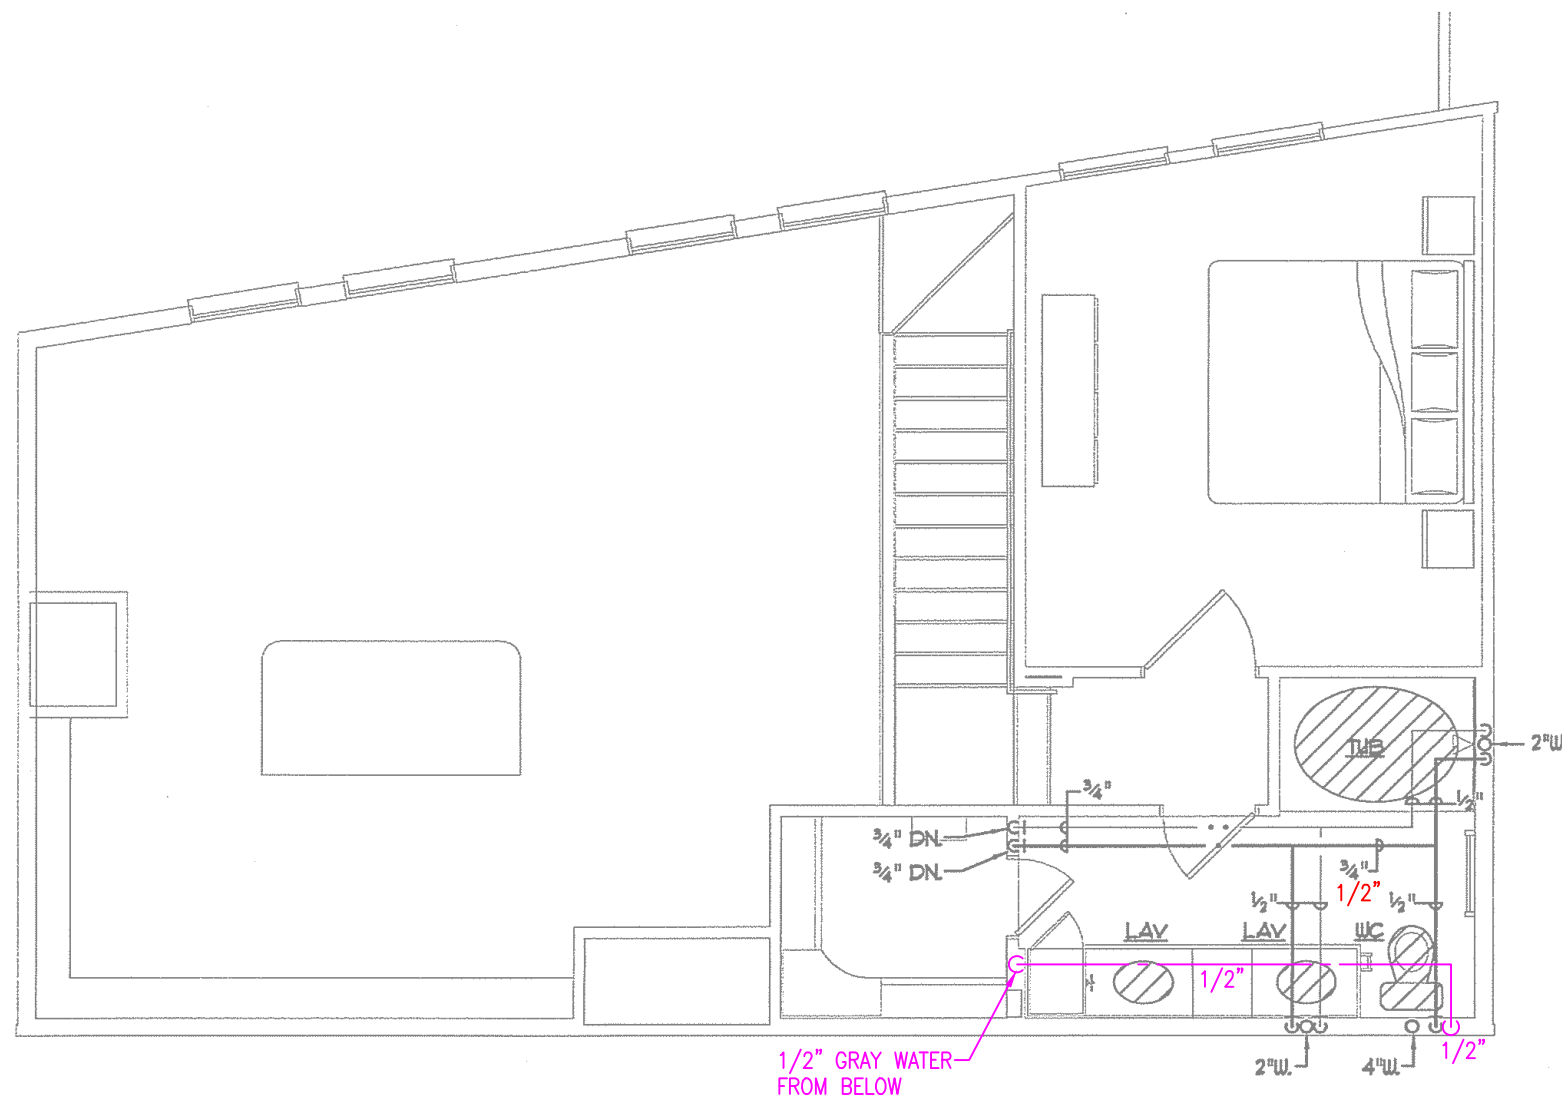


2 UNIT PLAN - A2L- UPPER - PLUMBING
SCALE: 1/4" = 1'-0"

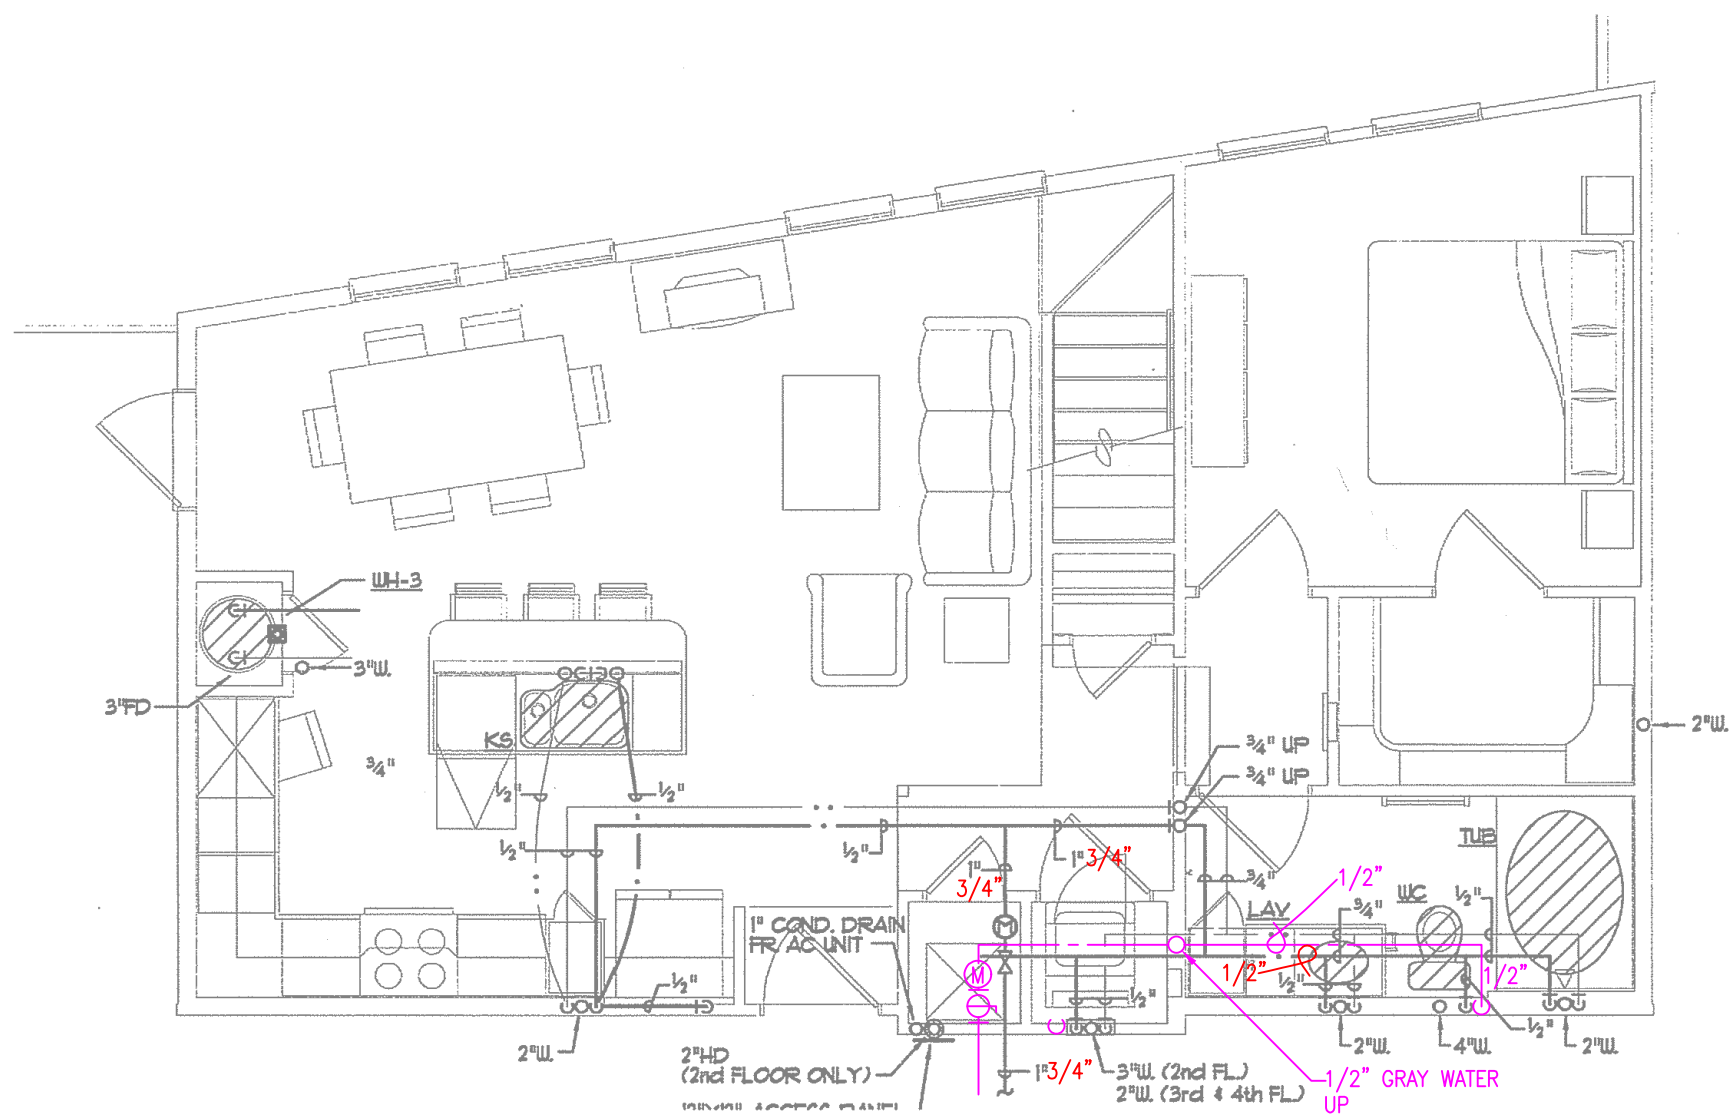


1 UNIT PLAN - A2L - LOWER - PLUMBING
SCALE: 1/4" = 1'-0"

PLUMBING LEGEND	
	DOMESTIC WATER SUPPLY PIPING
	GRAY WATER SUPPLY PIPING
2"	DOMESTIC WATER SUPPLY PIPING SIZE REDUCTION

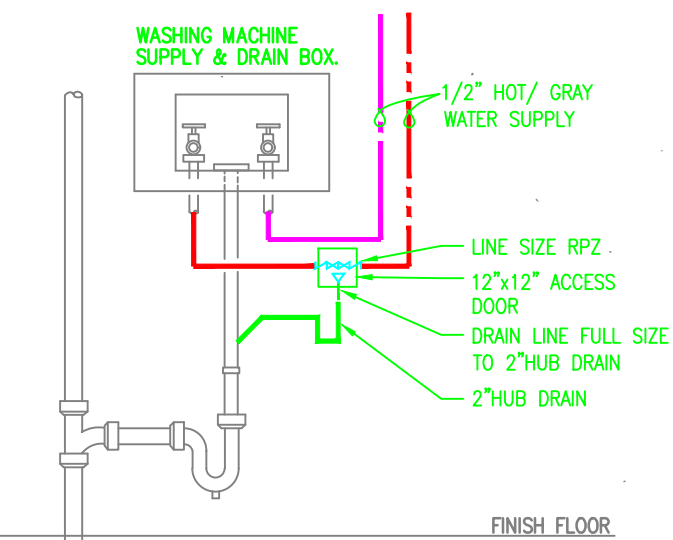

RPZ/HUB DRAIN @ WASHER BOX
SCALE: NOT TO SCALE

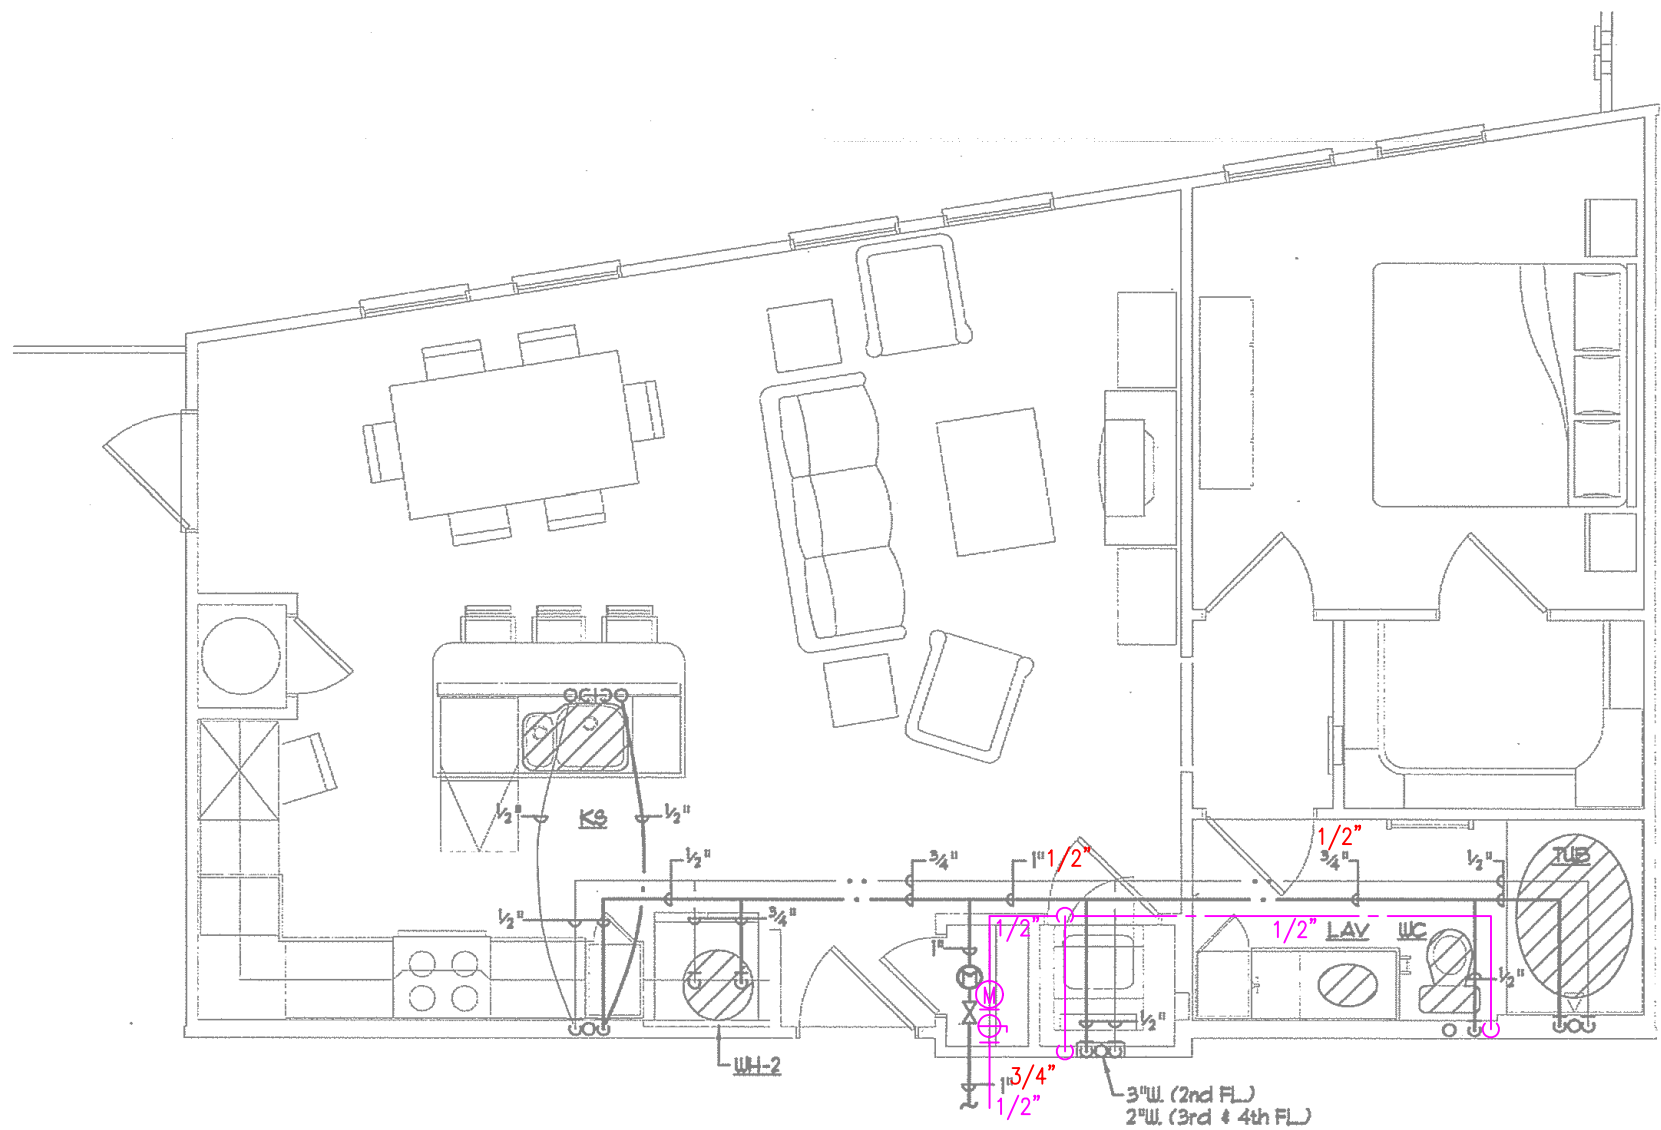

3 UNIT PLAN - A2 - PLUMBING
SCALE: 1/4" = 1'-0"




Looney Ricks Kiss
Architecture Planning Interiors Research
5307 E Markingbird Lane, Suite 220
Dulles, Texas 75206
Telephone 214-242-7650
Fax 214-242-7655
E-mail info@lrk.com

Multi-Family Plan for:
Gables Residential
6850 Austin Center Blvd, Suite 200
Austin, Texas 78731

Issues and Revisions		
No.	Date	Issues and Revisions
01	11.10.06	PERMIT SET
02	03.28.07	PERMIT RESUBMITTAL

© 2006 Looney Ricks Kiss Architects, Inc.
Drawings, written material, and design concepts shall not be used or reproduced in whole or part in any form or format without prior written consent of Looney Ricks Kiss Architects, Inc. Do not scale drawings. Use given dimensions only. If not shown, verify correct dimensions with the Architect. Contractor shall check and verify all dimensions and conditions at job site.

Seal

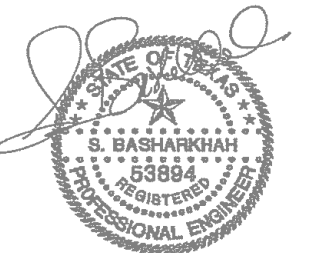

Project Number: 01.06006.00
Project Name:
5th Street Commons
5th Street
Austin, Texas
Drawing Name:

Drawn By:
Checked By:

P103

PLUMBING LEGEND	
	DOMESTIC WATER SUPPLY PIPING
	GRAY WATER SUPPLY PIPING
	2" DOMESTIC WATER SUPPLY PIPING SIZE REDUCTION

LRK

Looney Ricks Kiss

Architects Planning Interiors Research
5307 E Mockingbird Lane, Suite 220
Dallas, Texas 75206
Telephone 214-242-7650
Fax 214-242-7655
E-mail info@lrk.com

Multi-Family Plan for:

Gables Residential

6850 Austin Center Blvd, Suite 200


Austin, Texas 78731

Issues and Revisions

No.	Date	Issues and Revisions
01	11.10.06	PERMIT SET
	03.28.07	PERMIT RESUBMITTAL

© 2006 Looney Ricks Kiss Architects, Inc.
Drawings, written material, and design concepts shall not be used or reproduced in whole or part in any form or format without prior written consent of Looney Ricks Kiss Architects, Inc. Do not scale drawings. Use given dimensions only. If not shown, verify correct dimensions with the Architect. Contractor shall check and verify all dimensions and conditions at job site.

Seal

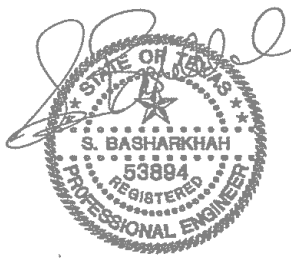

Project Number: 01.06006.00

Project Name:

5th Street Commons

5th Street


Austin, Texas

Drawing Name:


Drawn By:

Checked By:


P104

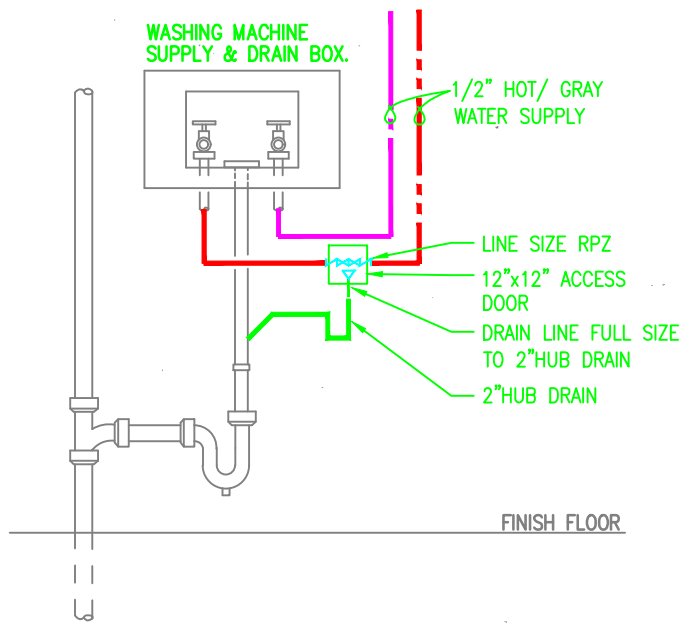


RPZ/HUB DRAIN @ WASHER BOX
SCALE: NOT TO SCALE

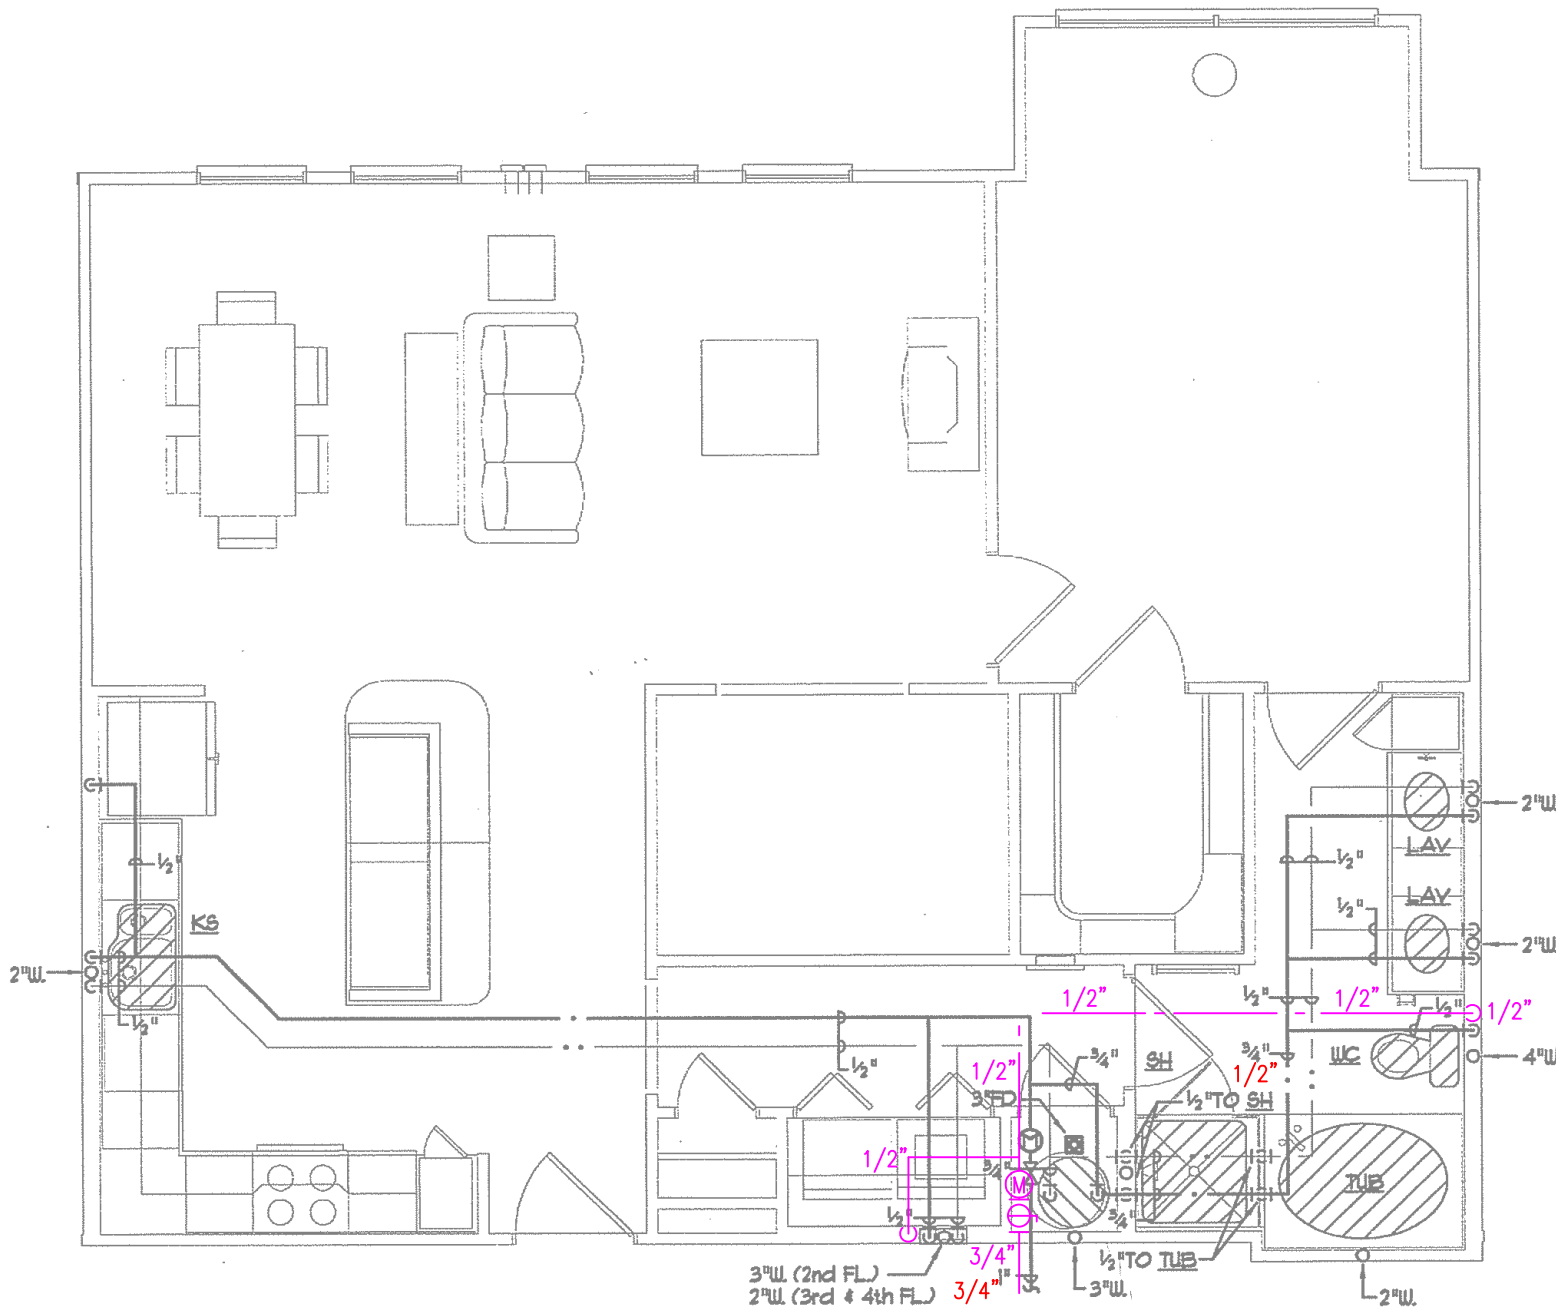


1 UNIT PLAN - A3 - PLUMBING
SCALE: 1/4" = 1'-0"

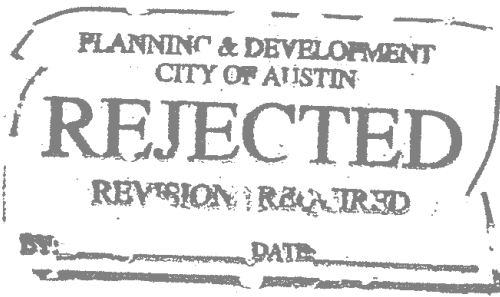

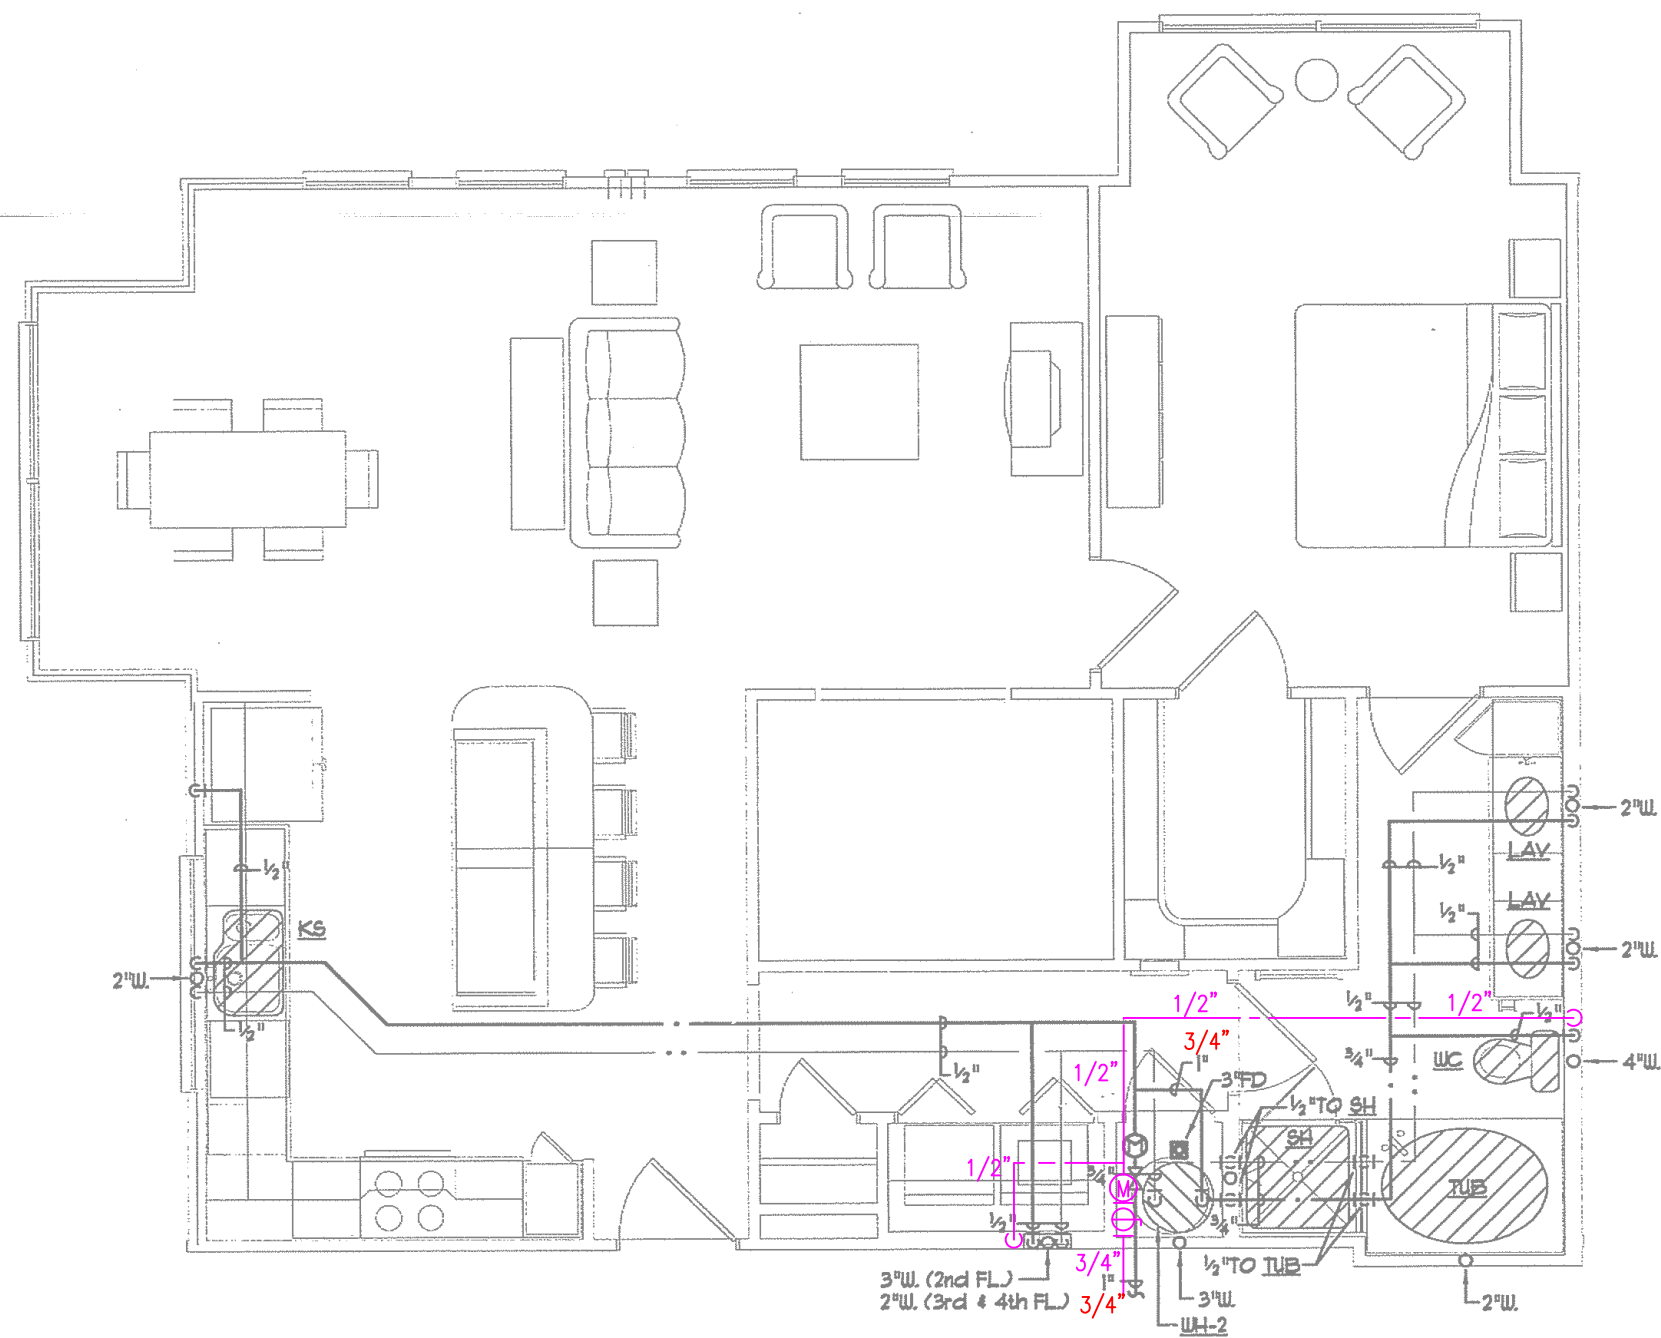


1 UNIT PLAN - A3D - PLUMBING
SCALE: 1/4" = 1'-0"

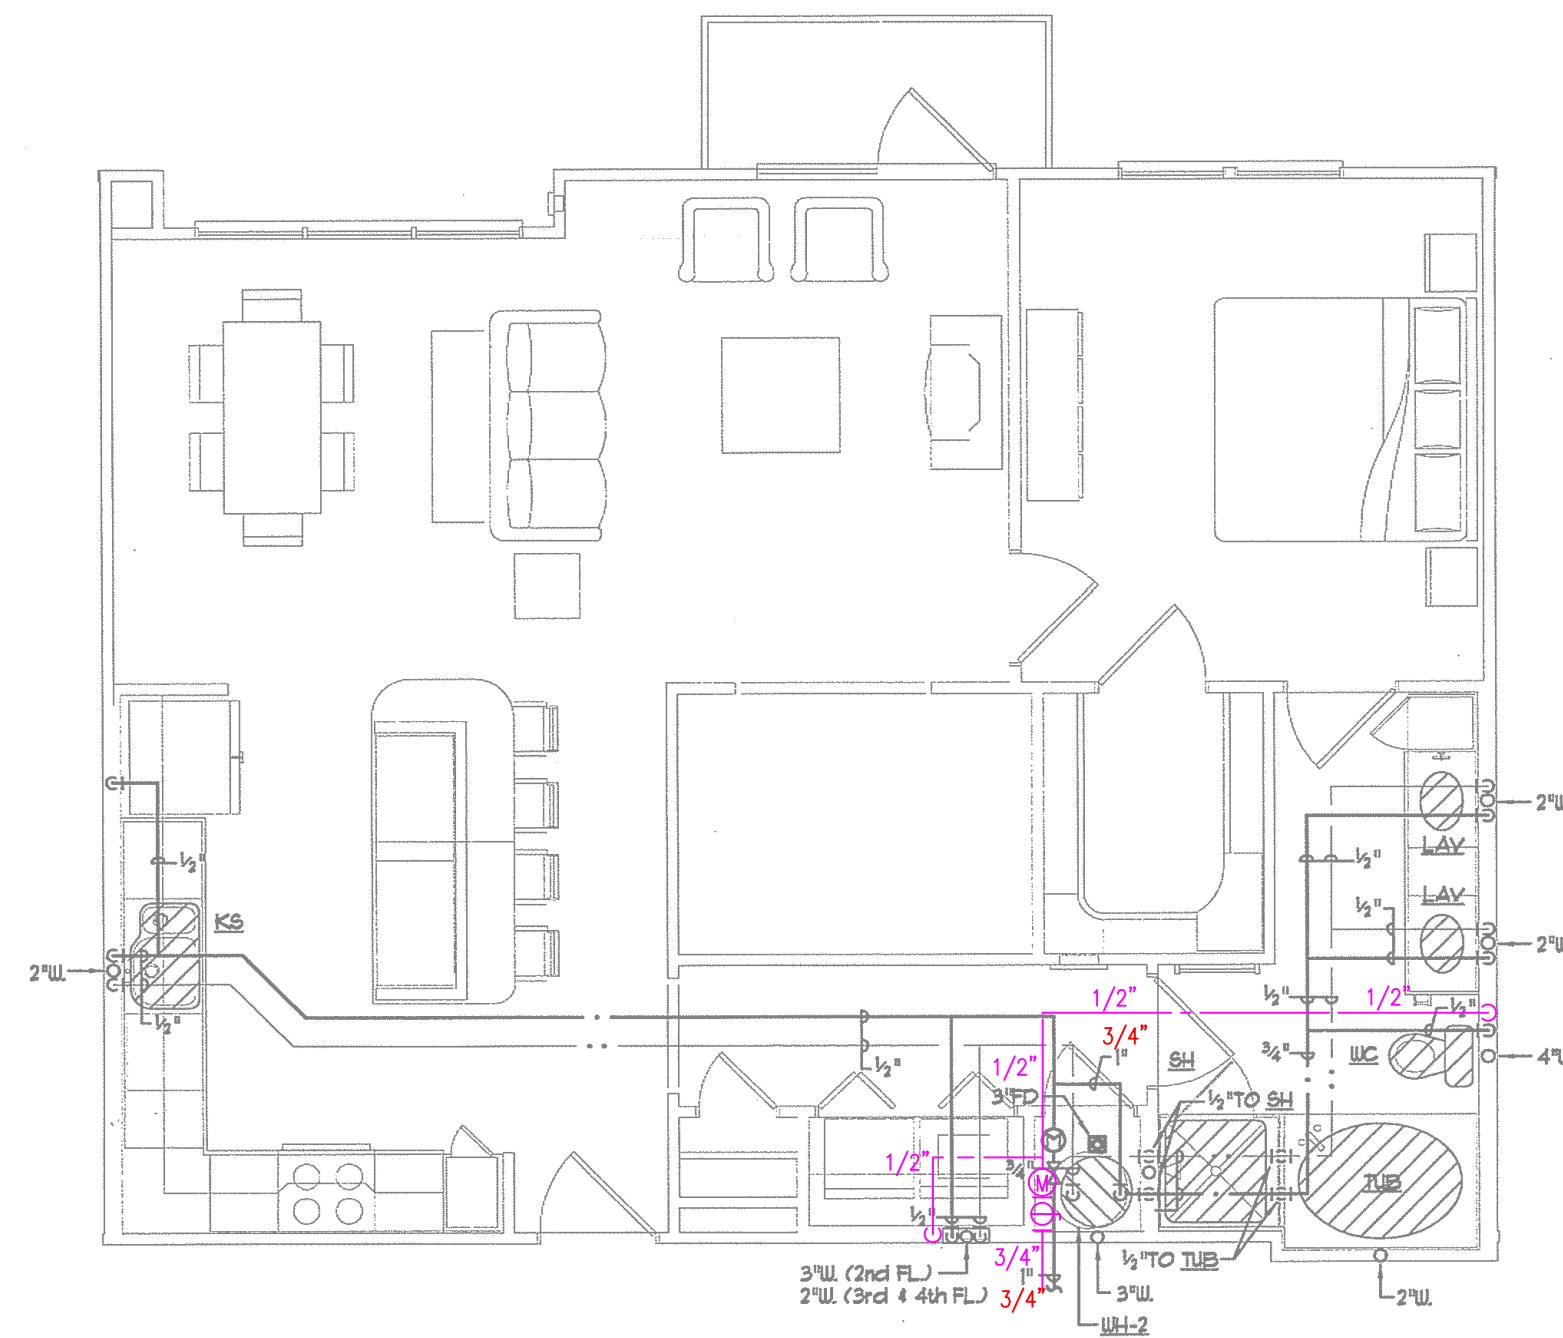

2 UNIT PLAN - A3E - PLUMBING
SCALE: 1/4" = 1'-0"

PLUMBING LEGEND	
---	DOMESTIC WATER SUPPLY PIPING
---	GRAY WATER SUPPLY PIPING
2"	DOMESTIC WATER SUPPLY PIPING SIZE REDUCTION

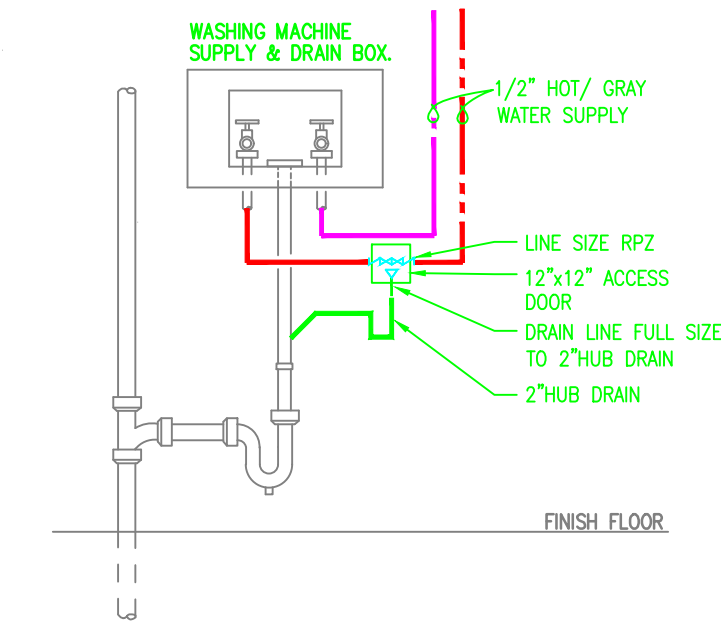

RPZ/HUB DRAIN @ WASHER BOX
SCALE: NOT TO SCALE



Architecture Planning Interiors Research
5307 E Markingbird Lane, Suite 220
Dallas, Texas 75206
Telephone 214-242-7650
Fax 214-242-7655
E-mail info@lrk.com

Multi-Family Plan for:
Gables Residential
6850 Austin Center Blvd, Suite 200
Austin, Texas 78731

Issues and Revisions		
No.	Date	Issues and Revisions
01	11.10.06	PERMIT SET
1	03.28.07	PERMIT RESUBMITTAL


© 2006 Looney Ricks Kiss Architects, Inc.
Drawings, written material, and design concepts shall not be used or reproduced in whole or part in any form or format without prior written consent of Looney Ricks Kiss Architects, Inc. Do not scale drawings. Use given dimensions only. If not shown, verify correct dimensions with the Architect. Contractor shall check and verify all dimensions and conditions of job site.

Seal



4/5/07


Project Number: 01.06006.00
Project Name:
5th Street Commons
5th Street
Austin, Texas
Drawing Name:

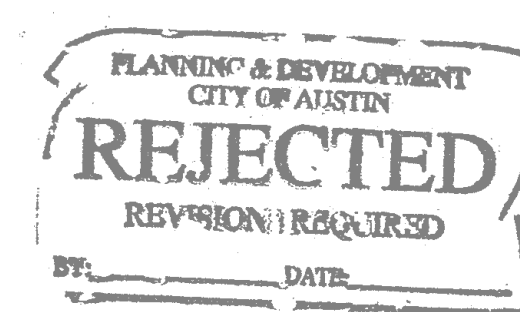

Drawn By:
Checked By:

P105

PLUMBING LEGEND	
	DOMESTIC WATER SUPPLY PIPING
	GRAY WATER SUPPLY PIPING
	2" DOMESTIC WATER SUPPLY PIPING SIZE REDUCTION

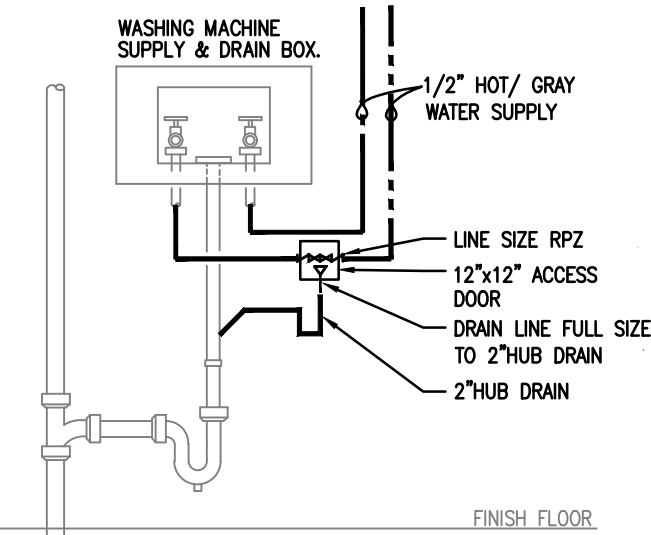

RPZ/HUB DRAIN @ WASHER BOX
SCALE: NOT TO SCALE

L R K

Looney Ricks Kiss

Architecture Planning Interiors Research
5307 E Markingbird Lane, Suite 220
Dallas, Texas 75206
Telephone 214-242-7650
Fax 214-242-7655
E-mail info@lrk.com

Multi-Family Plan for:

Gables Residential

6850 Austin Center Blvd, Suite 200

Austin, Texas 78731

Issues and Revisions		
No.	Date	Issues and Revisions
01	11.10.06	PERMIT SET
	03.28.07	PERMIT RESUBMITTAL

© 2006 Looney Ricks Kiss Architects, Inc.
Drawings, written material, and design concepts shall not be used or reproduced in whole or part in any form or format without prior written consent of Looney Ricks Kiss Architects, Inc. Do not scale drawings. Use given dimensions only. If not shown, verify correct dimensions with the Architect. Contractor shall check and verify all dimensions and conditions of job site.

Seal



4/5/07

Project Number: 01.06006.00

Project Name:

5th Street Commons

5th Street


Austin, Texas

Drawing Name:


Drawn By:

Checked By:


P106

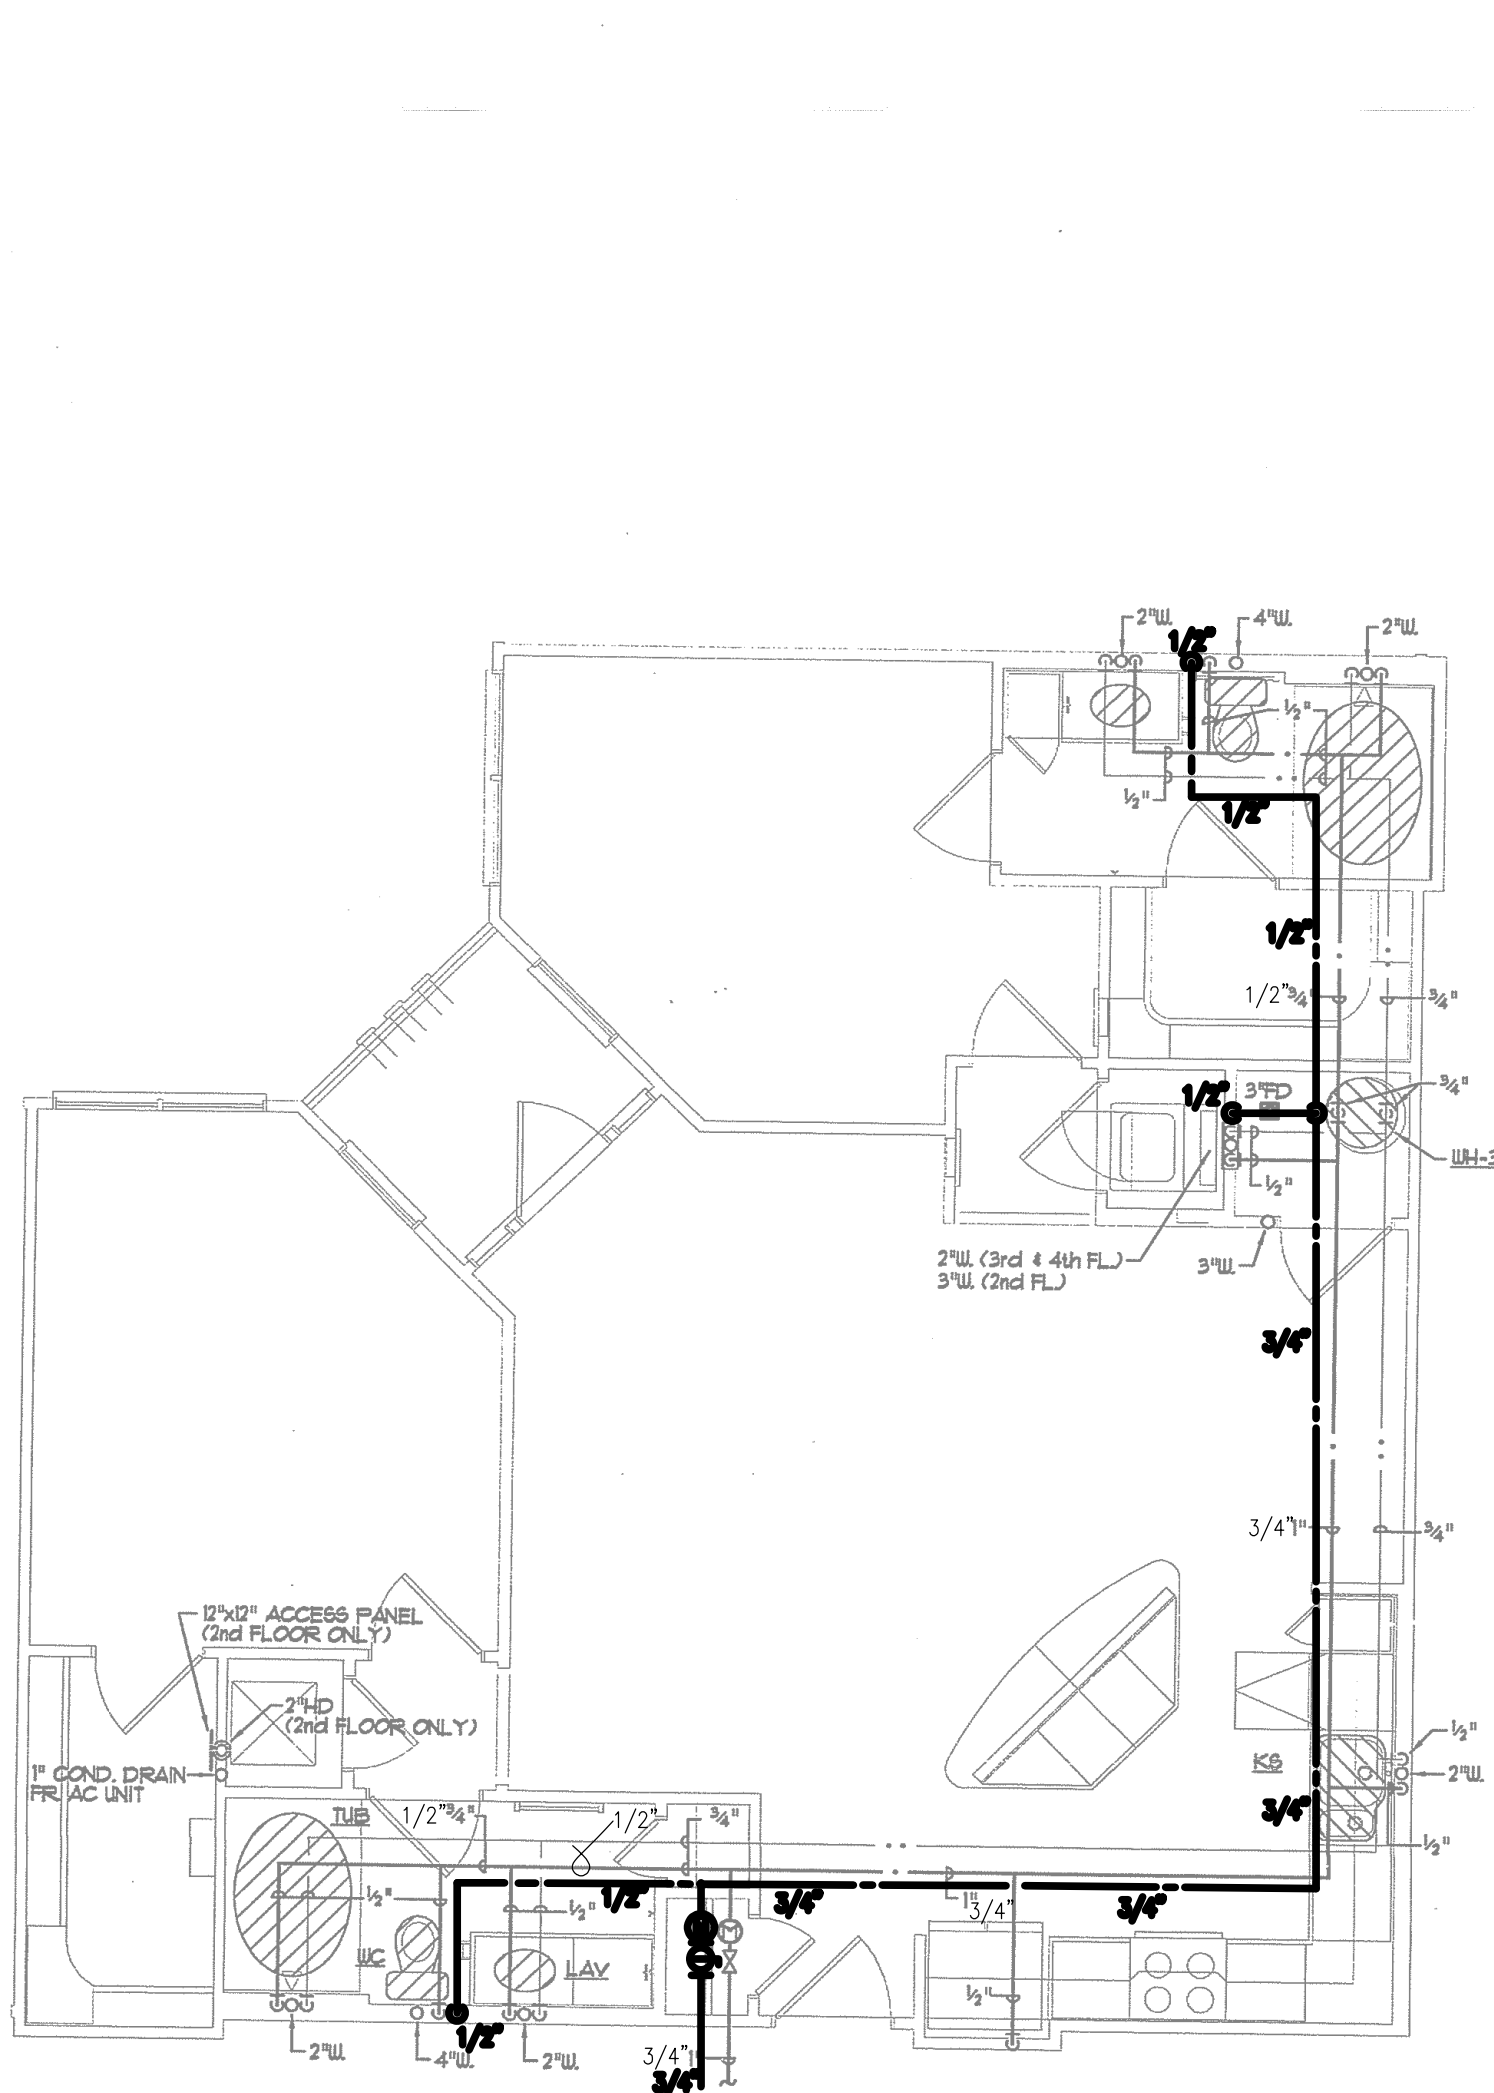


1 UNIT PLAN - B1 - PLUMBING
SCALE: 1/4" = 1'-0"

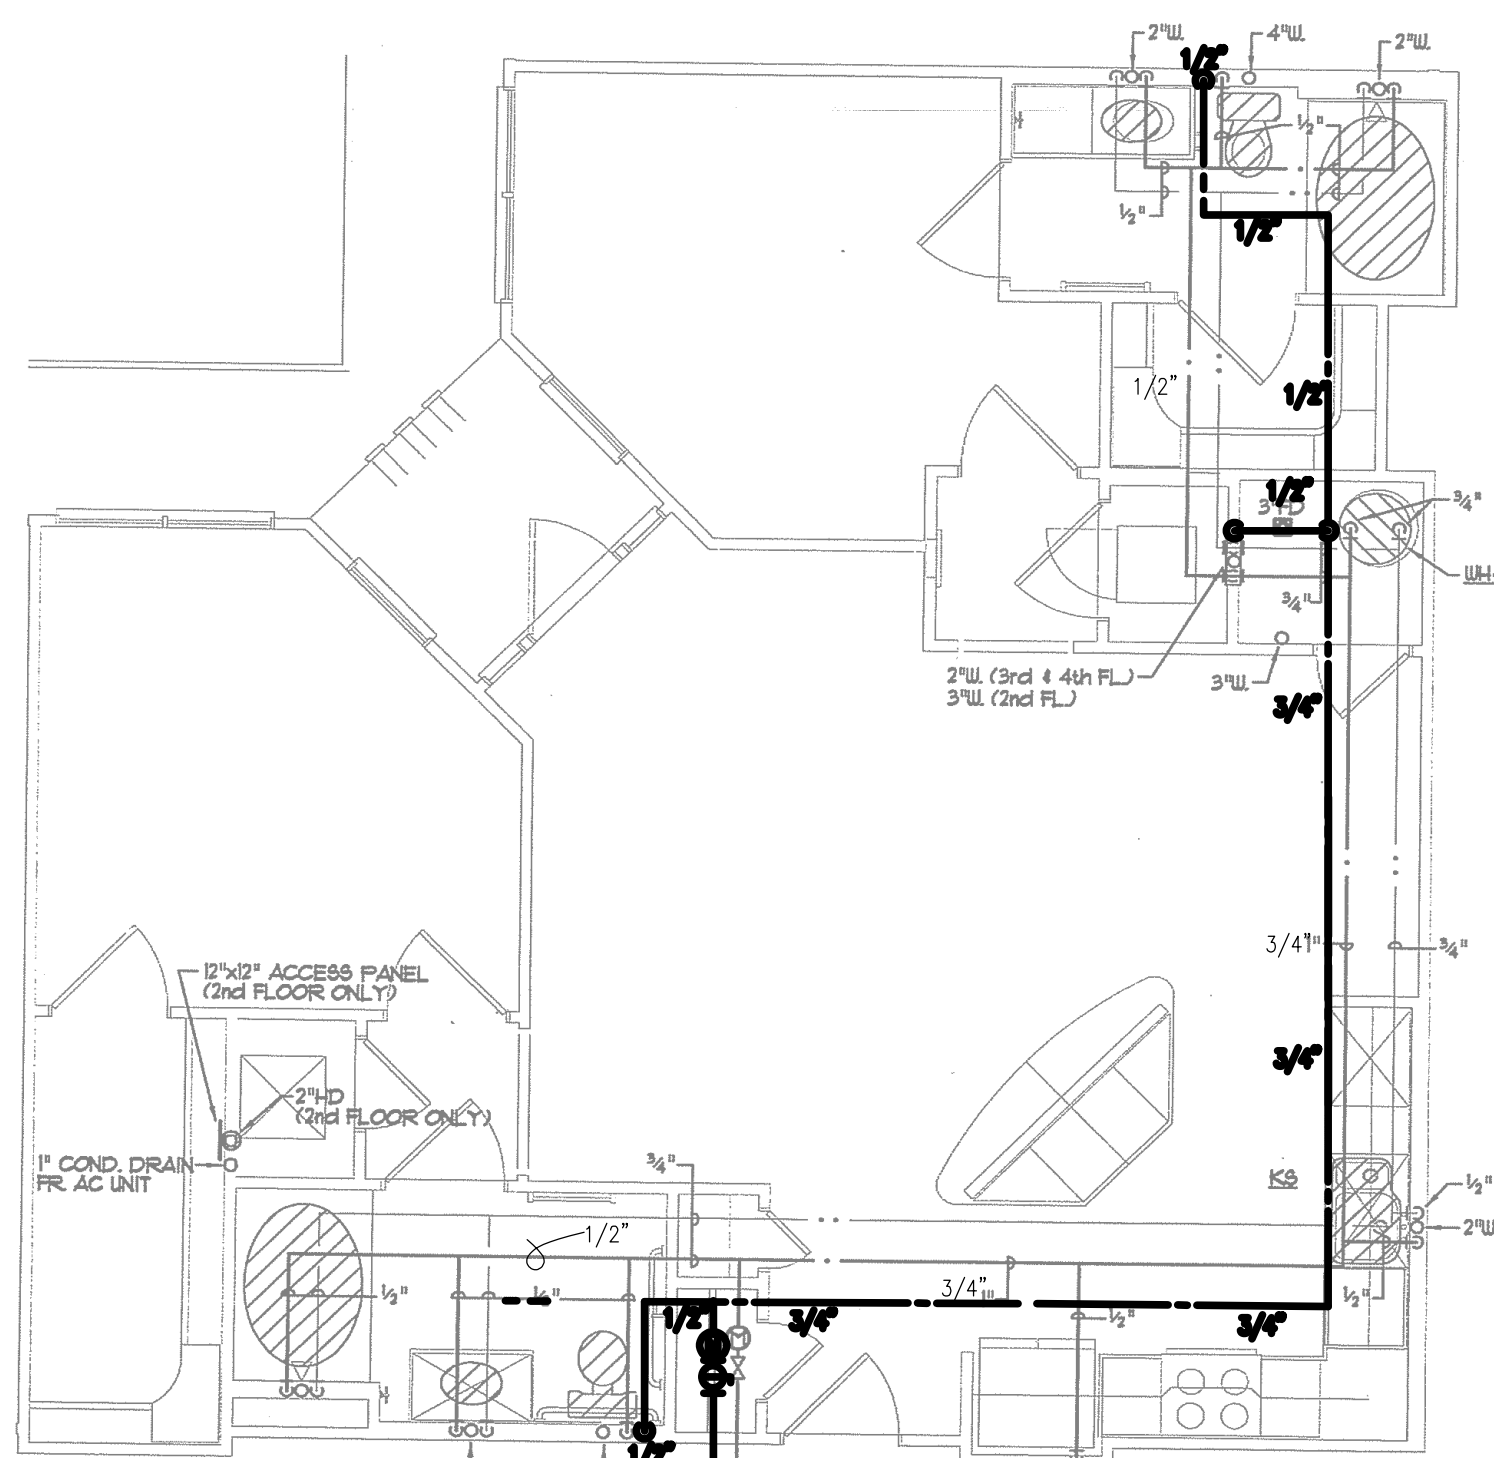

2 UNIT PLAN - B1A ANSI TYPE A - PLUMBING
SCALE: 1/4" = 1'-0"

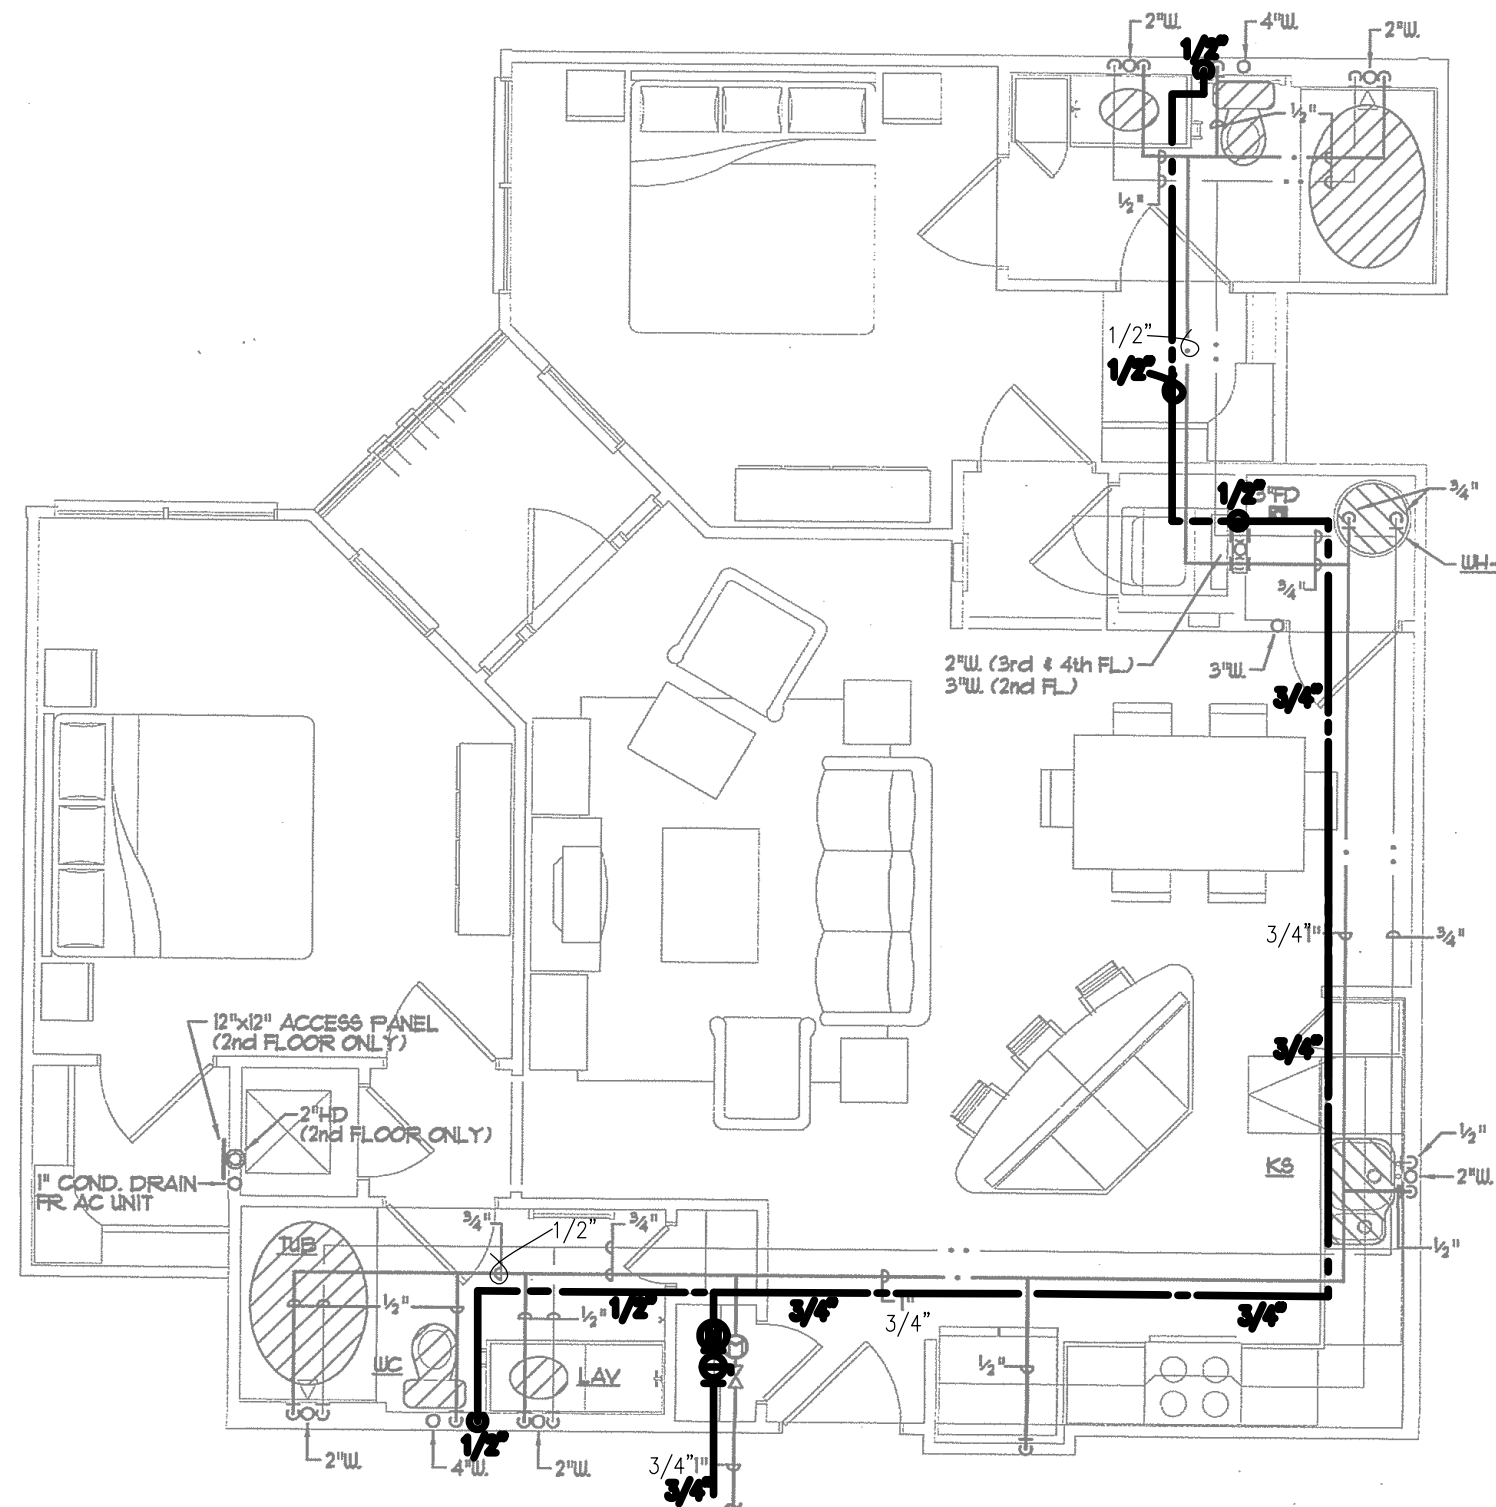


3 UNIT PLAN - B1B - PLUMBING
SCALE: 1/4" = 1'-0"

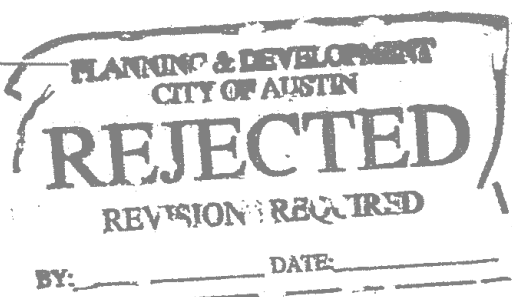

PLUMBING LEGEND

- DOMESTIC WATER SUPPLY PIPING
- GRAY WATER SUPPLY PIPING
- 2" DOMESTIC WATER SUPPLY PIPING SIZE REDUCTION

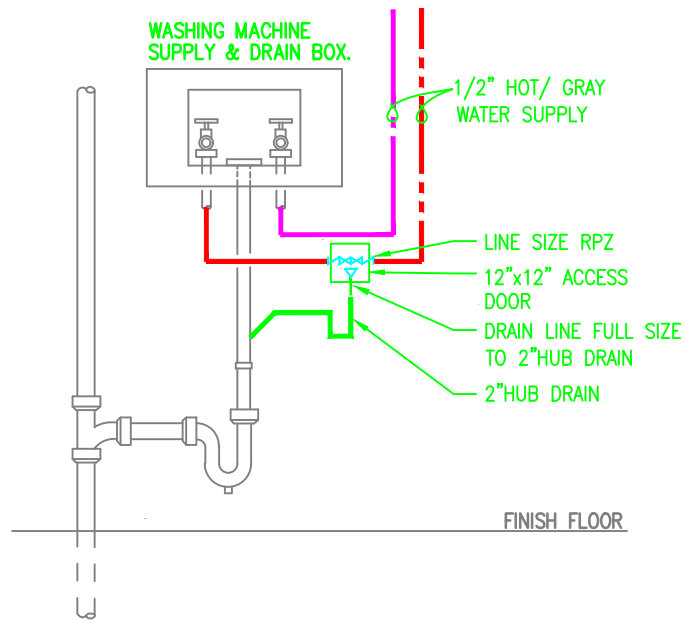

RPZ/HUB DRAIN @ WASHER BOX
SCALE: NOT TO SCALE

LRK

Looney Ricks Kiss

Architecture Planning Interiors Research
5307 E Markingbird Lane, Suite 220
Dallas, Texas 75206
Telephone 214-242-7650
Fax 214-242-7655
E-mail info@lrk.com

Multi-Family Plan for:

Gables Residential


6850 Austin Center Blvd, Suite 200

Austin, Texas 78731

Issues and Revisions		
No.	Date	Issues and Revisions
01	11.10.06	PERMIT SET
03.28.07		PERMIT RESUBMITTAL

© 2006 Looney Ricks Kiss Architects, Inc.
Drawings, written material, and design concepts shall not be used or reproduced in whole or part in any form or format without prior written consent of Looney Ricks Kiss Architects, Inc. Do not scale drawings. Use given dimensions only. If not shown, verify correct dimensions with the Architect. Contractor shall check and verify all dimensions and conditions at job site.

Seal

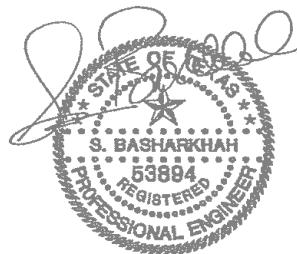

Project Number: 01.06006.00

Project Name:

5th Street Commons


5th Street

Austin, Texas


Drawing Name:

Drawn By:


Checked By:

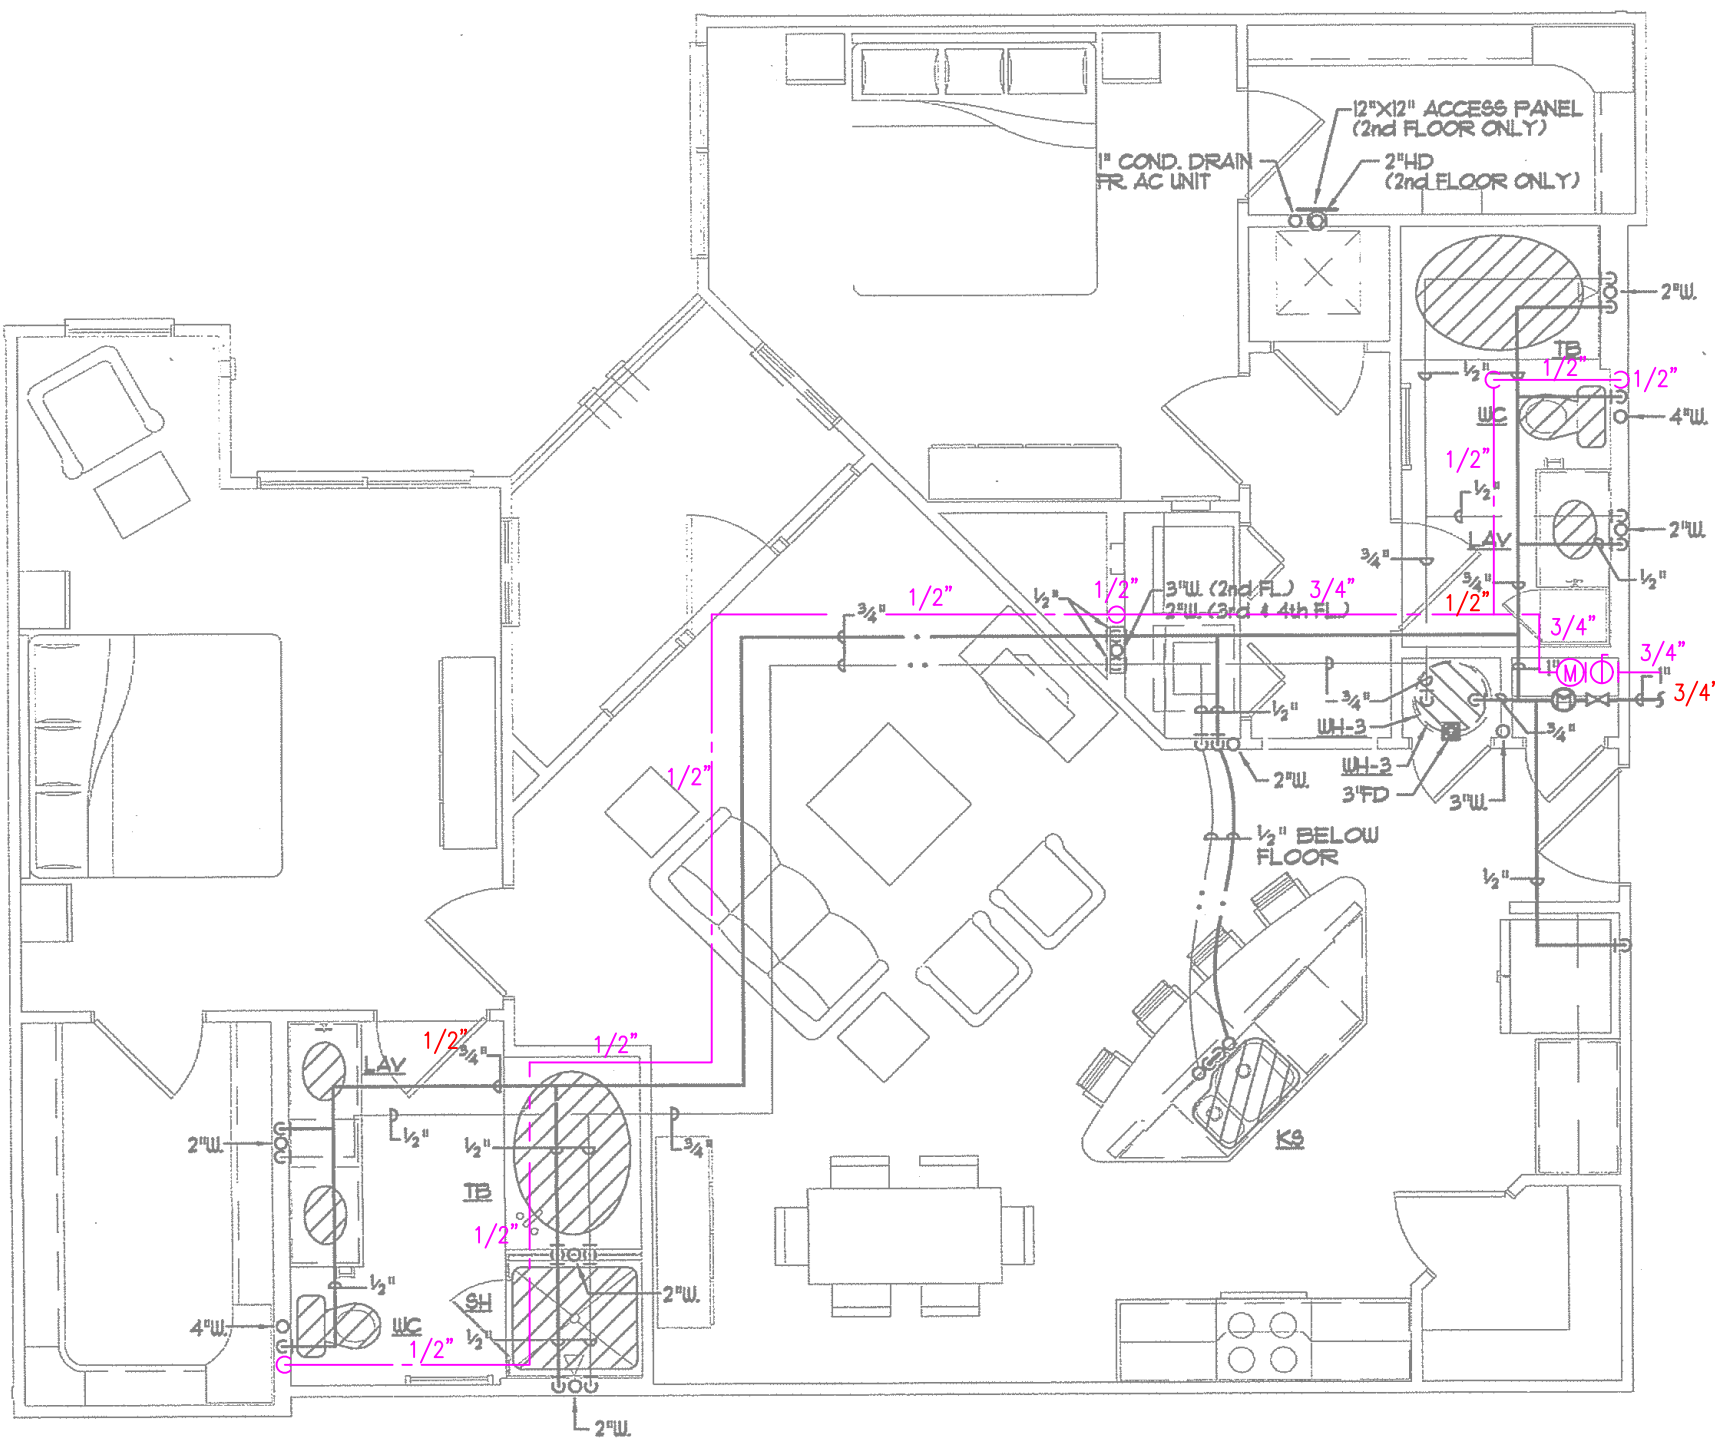

1 UNIT PLAN - B2 - PLUMBING
SCALE: 1/4" = 1'-0"

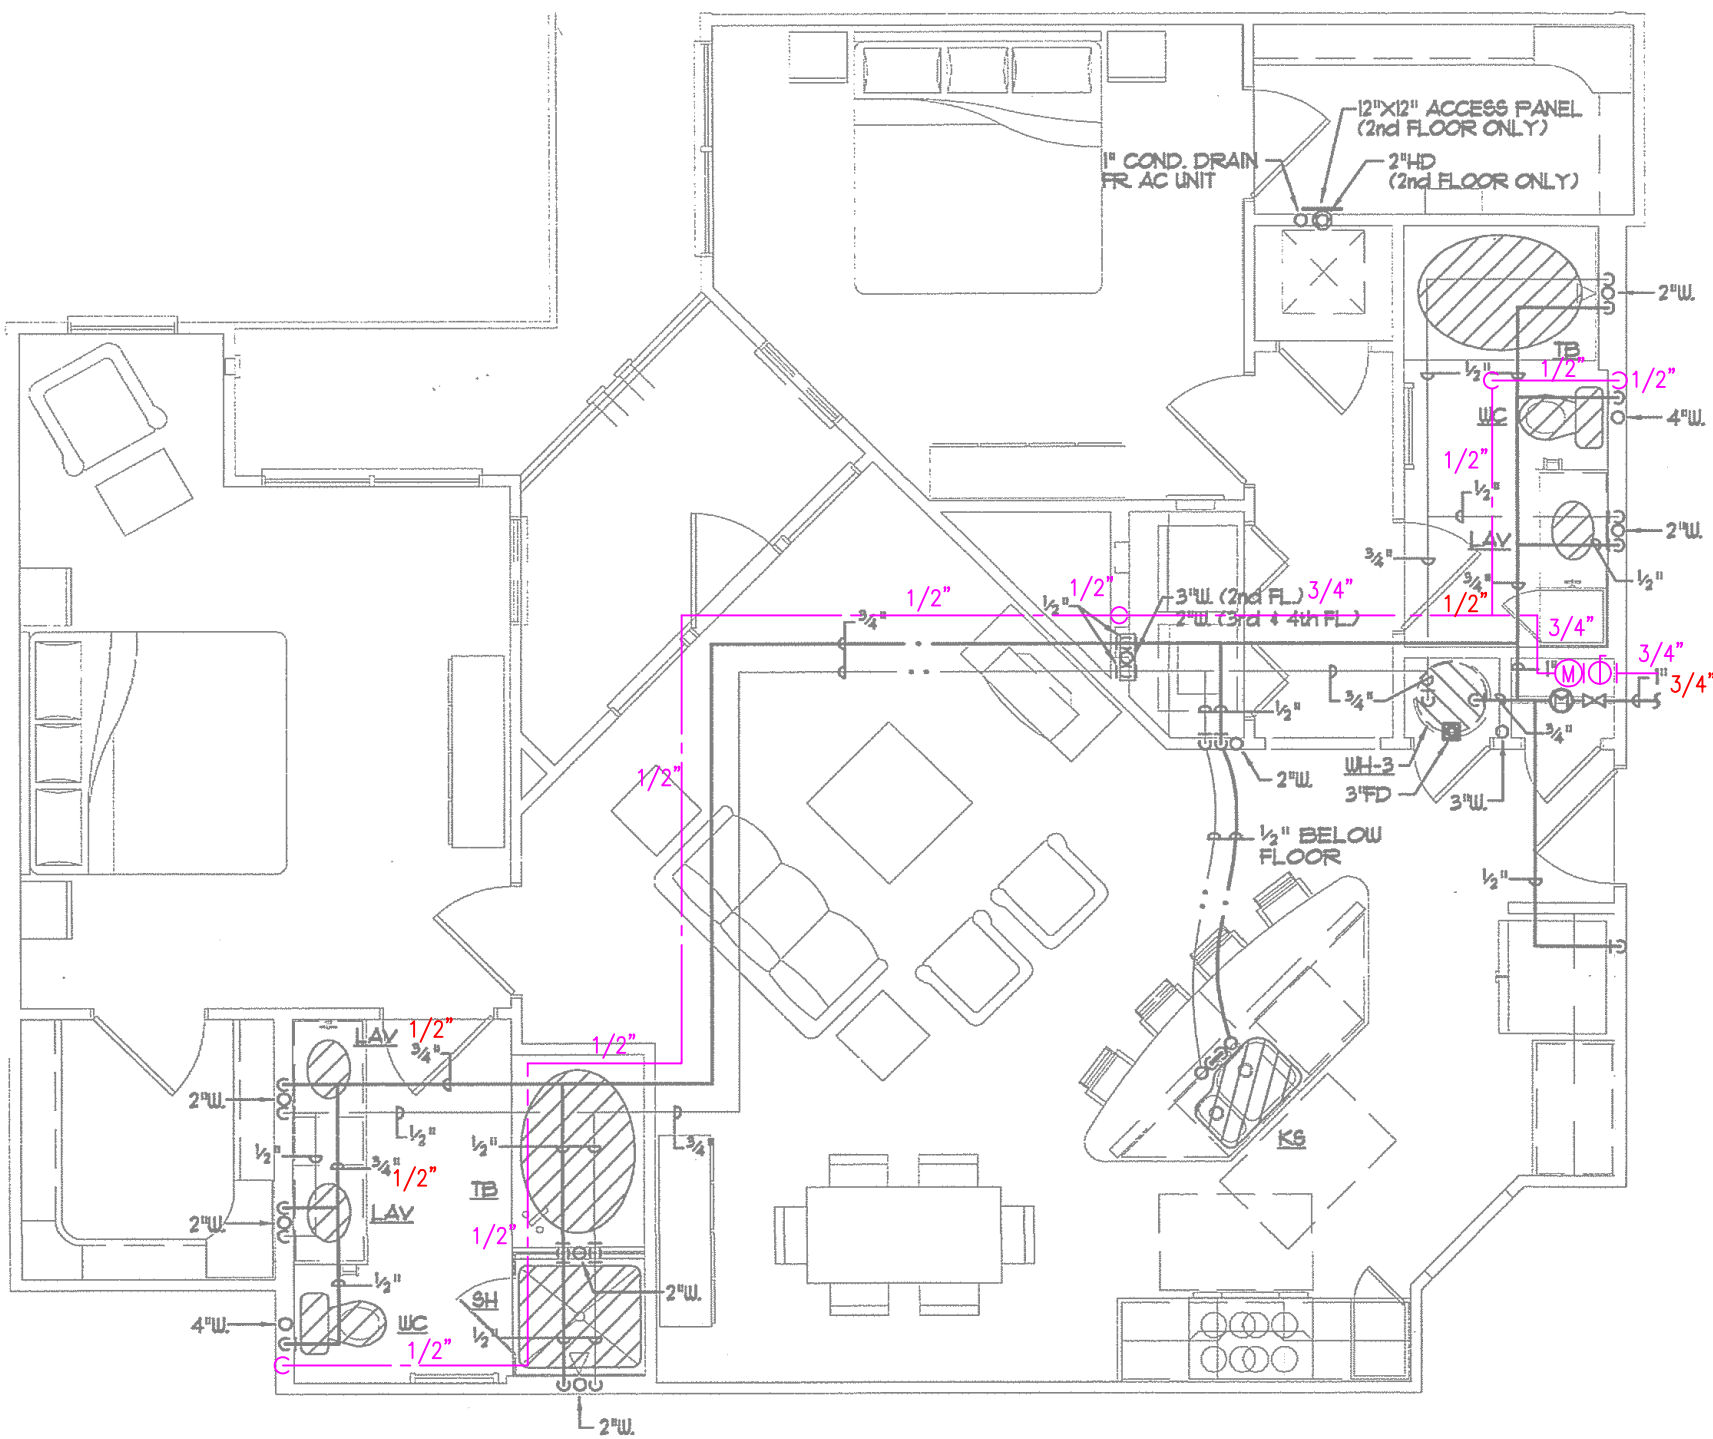

2 UNIT PLAN - B2B - PLUMBING
SCALE: 1/4" = 1'-0"

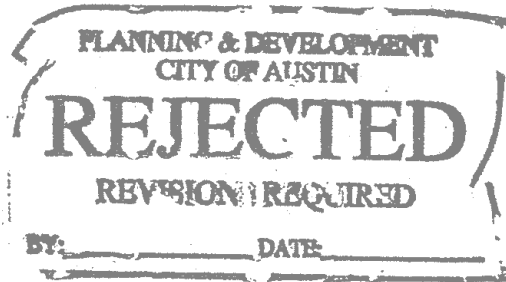


PLUMBING LEGEND

DOMESTIC WATER SUPPLY PIPING

GRAY WATER SUPPLY PIPING

2" DOMESTIC WATER SUPPLY PIPING SIZE REDUCTION

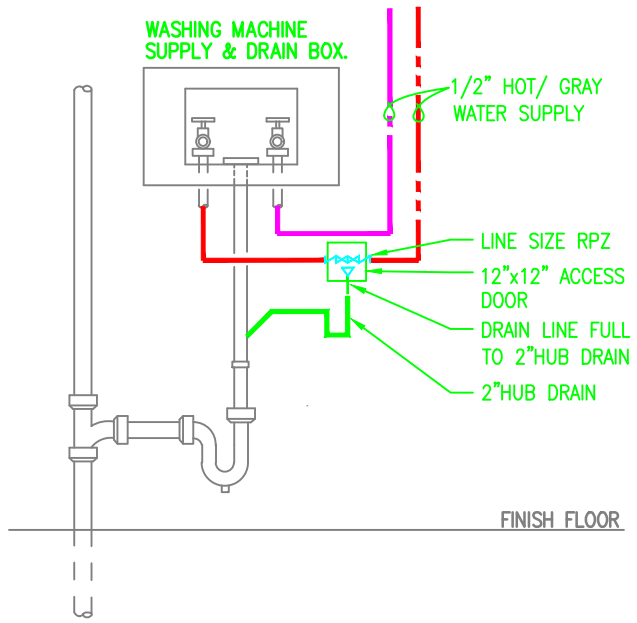

RPZ/HUB DRAIN @ WASHER BOX

SCALE: NOT TO SCALE



Architecture Planning Interiors Research
5307 E Mockingbird Lane, Suite 220
Dallas, Texas 75206
Telephone 214-242-7650
Fax 214-242-7655
E-mail info@lrk.com

Multi-Family Plan for:

Gables Residential

6850 Austin Center Blvd, Suite 200
Austin, Texas 78731

Issues and Revisions		
No.	Date	Issues and Revisions
01	11.10.06	PERMIT SET
	03.28.07	PERMIT RESUBMITTAL

© 2006 Looney Ricks Kiss Architects, Inc.
Drawings, written material, and design concepts shall not be used or reproduced in whole or part in any form or format without prior written consent of Looney Ricks Kiss Architects, Inc. Do not scale drawings. Use given dimensions only. If not shown, verify correct dimensions with the Architect. Contractor shall check and verify all dimensions and conditions of job site.

Seal



4/5/07

Project Number: 01.06006.00

Project Name:

5th Street Commons

5th Street


Austin, Texas

Drawing Name:

Drawn By:


Checked By:


P108

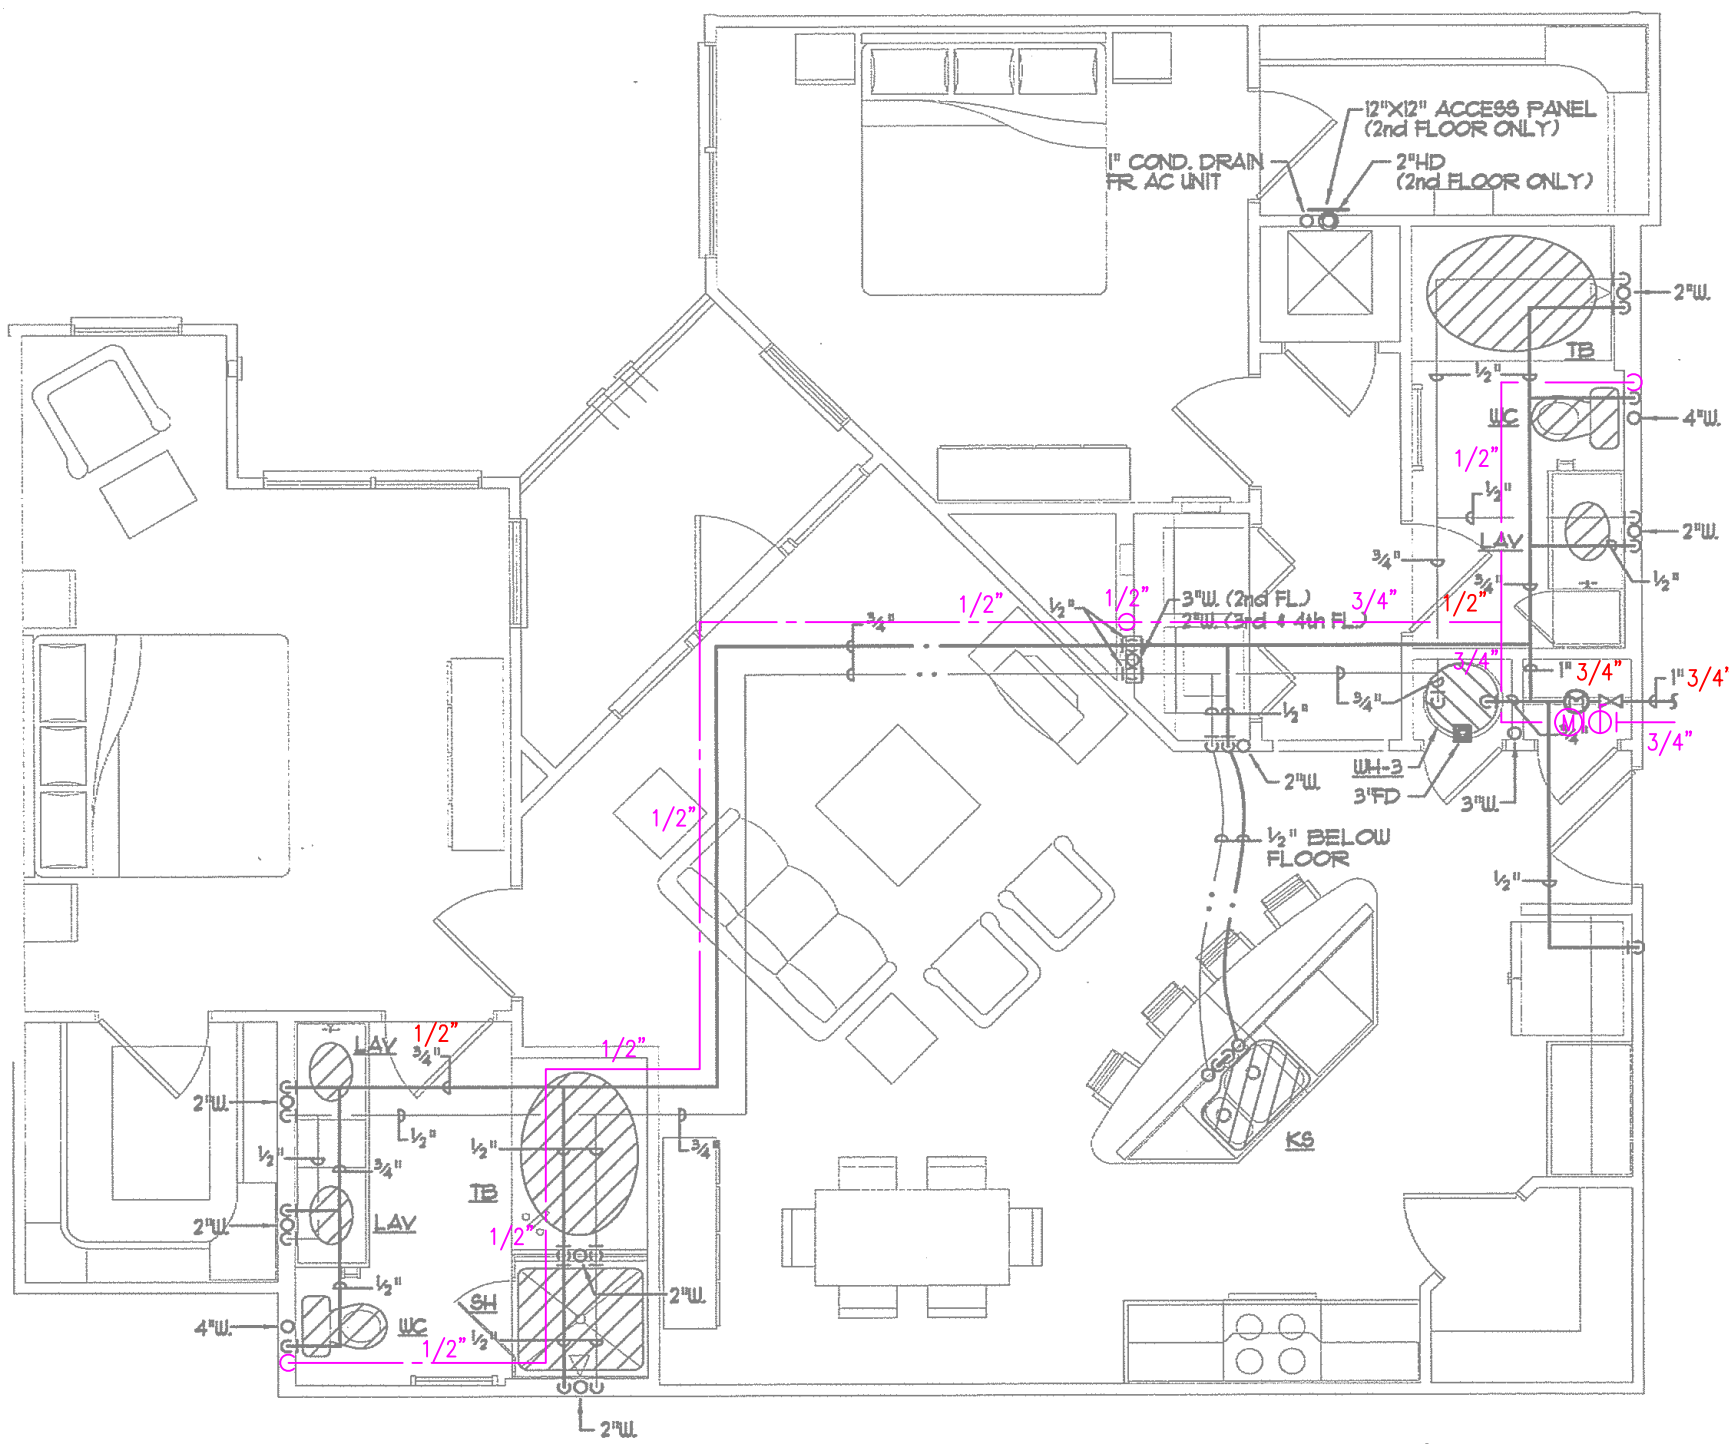

1 UNIT PLAN - B2D - PLUMBING


SCALE: 1/4" = 1'-0"

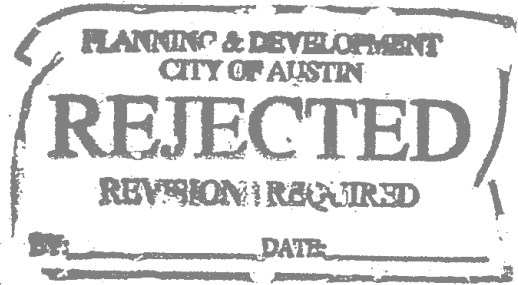

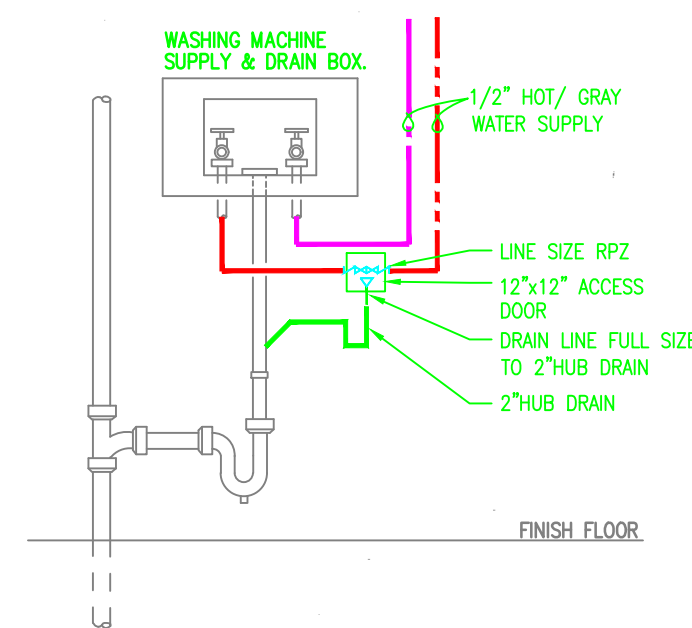


RPZ/HUB DRAIN @
WASHER BOX
SCALE: NOT TO SCALE


PLUMBING LEGEND	
---	DOMESTIC WATER SUPPLY PIPING
---	GRAY WATER SUPPLY PIPING
2"	DOMESTIC WATER SUPPLY PIPING SIZE REDUCTION

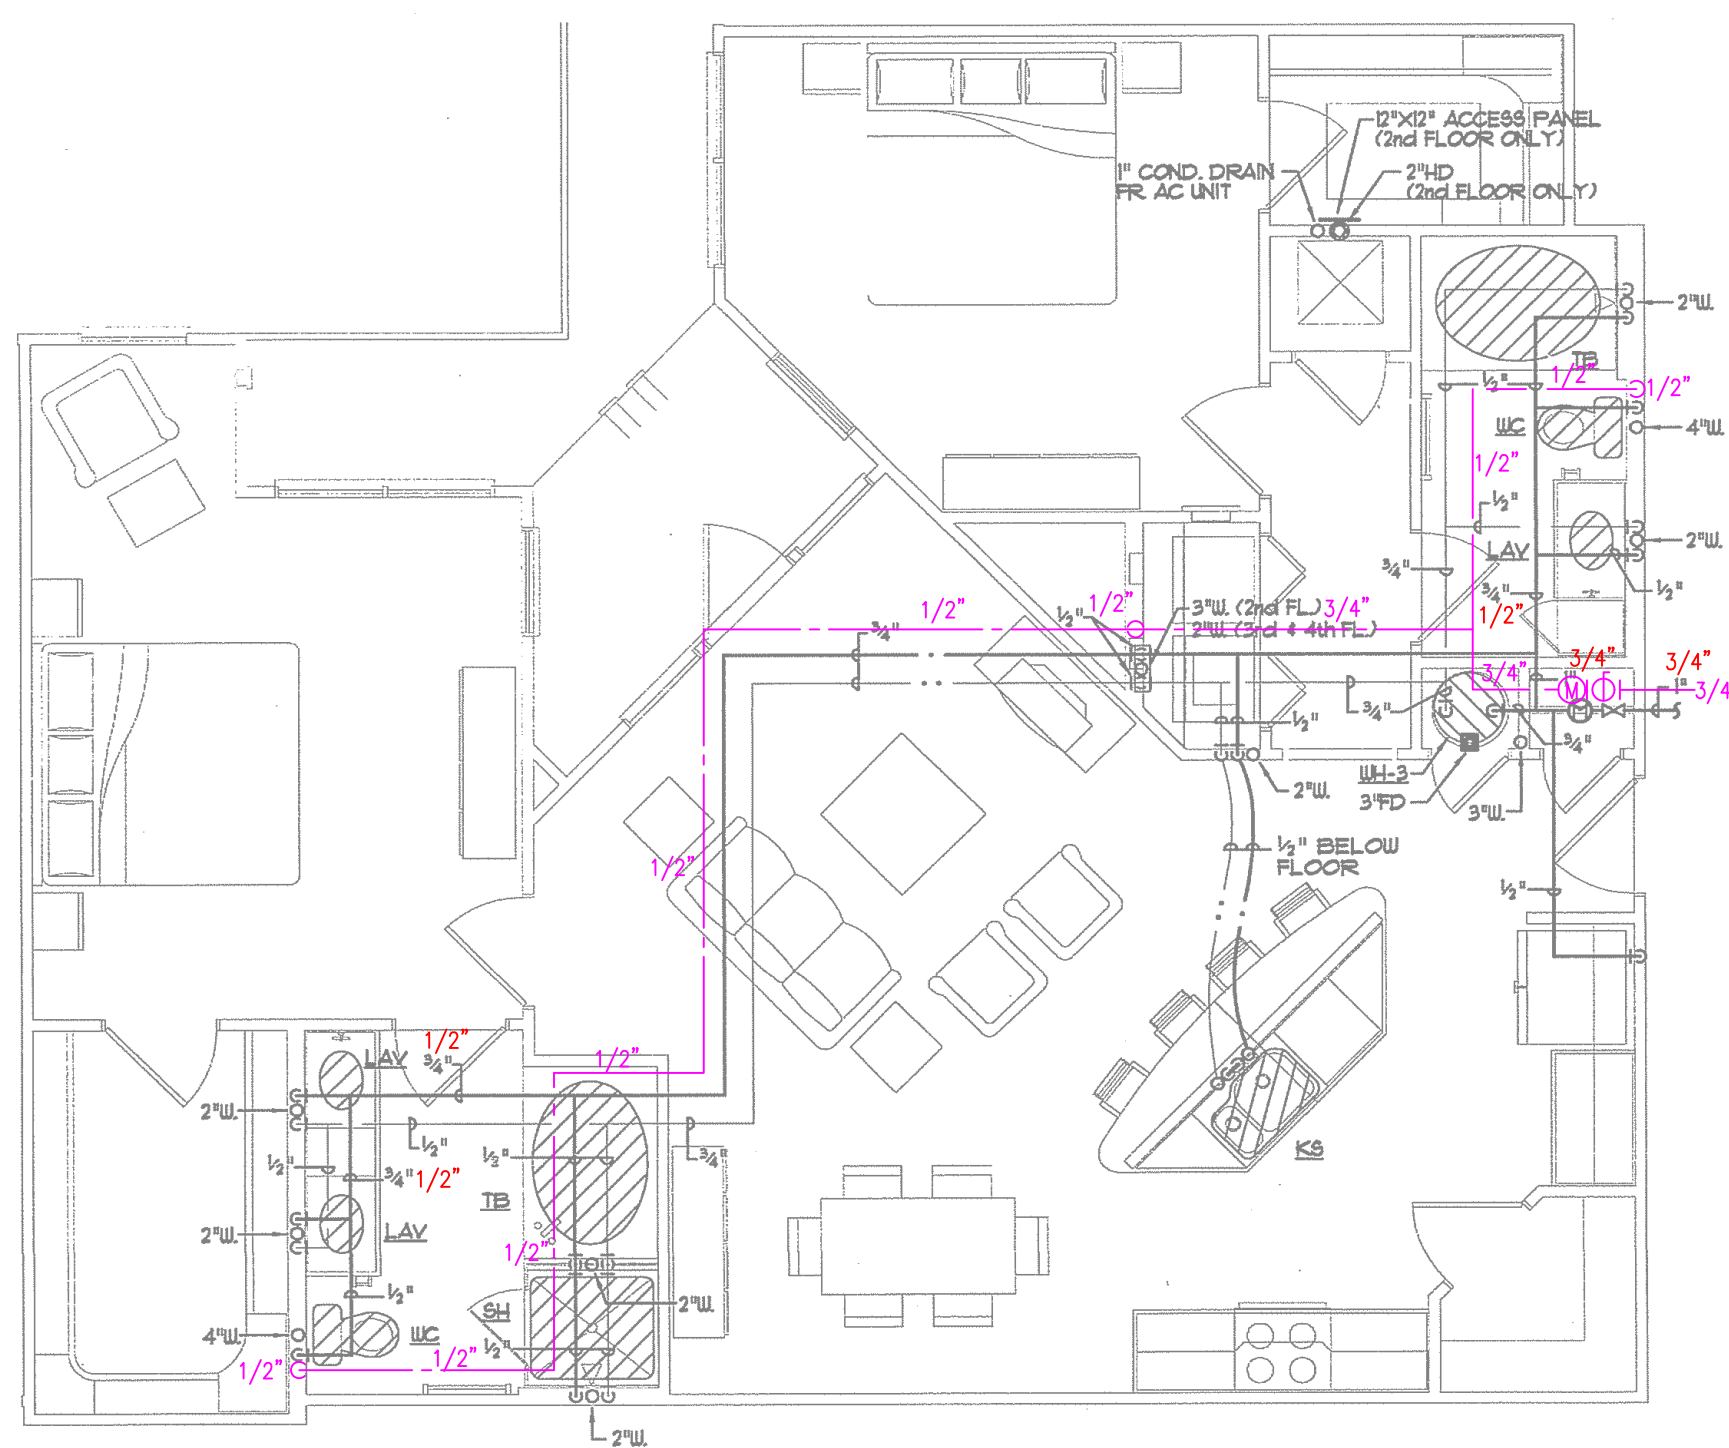

1 UNIT PLAN - B2H - PLUMBING
SCALE: 1/4" = 1'-0"

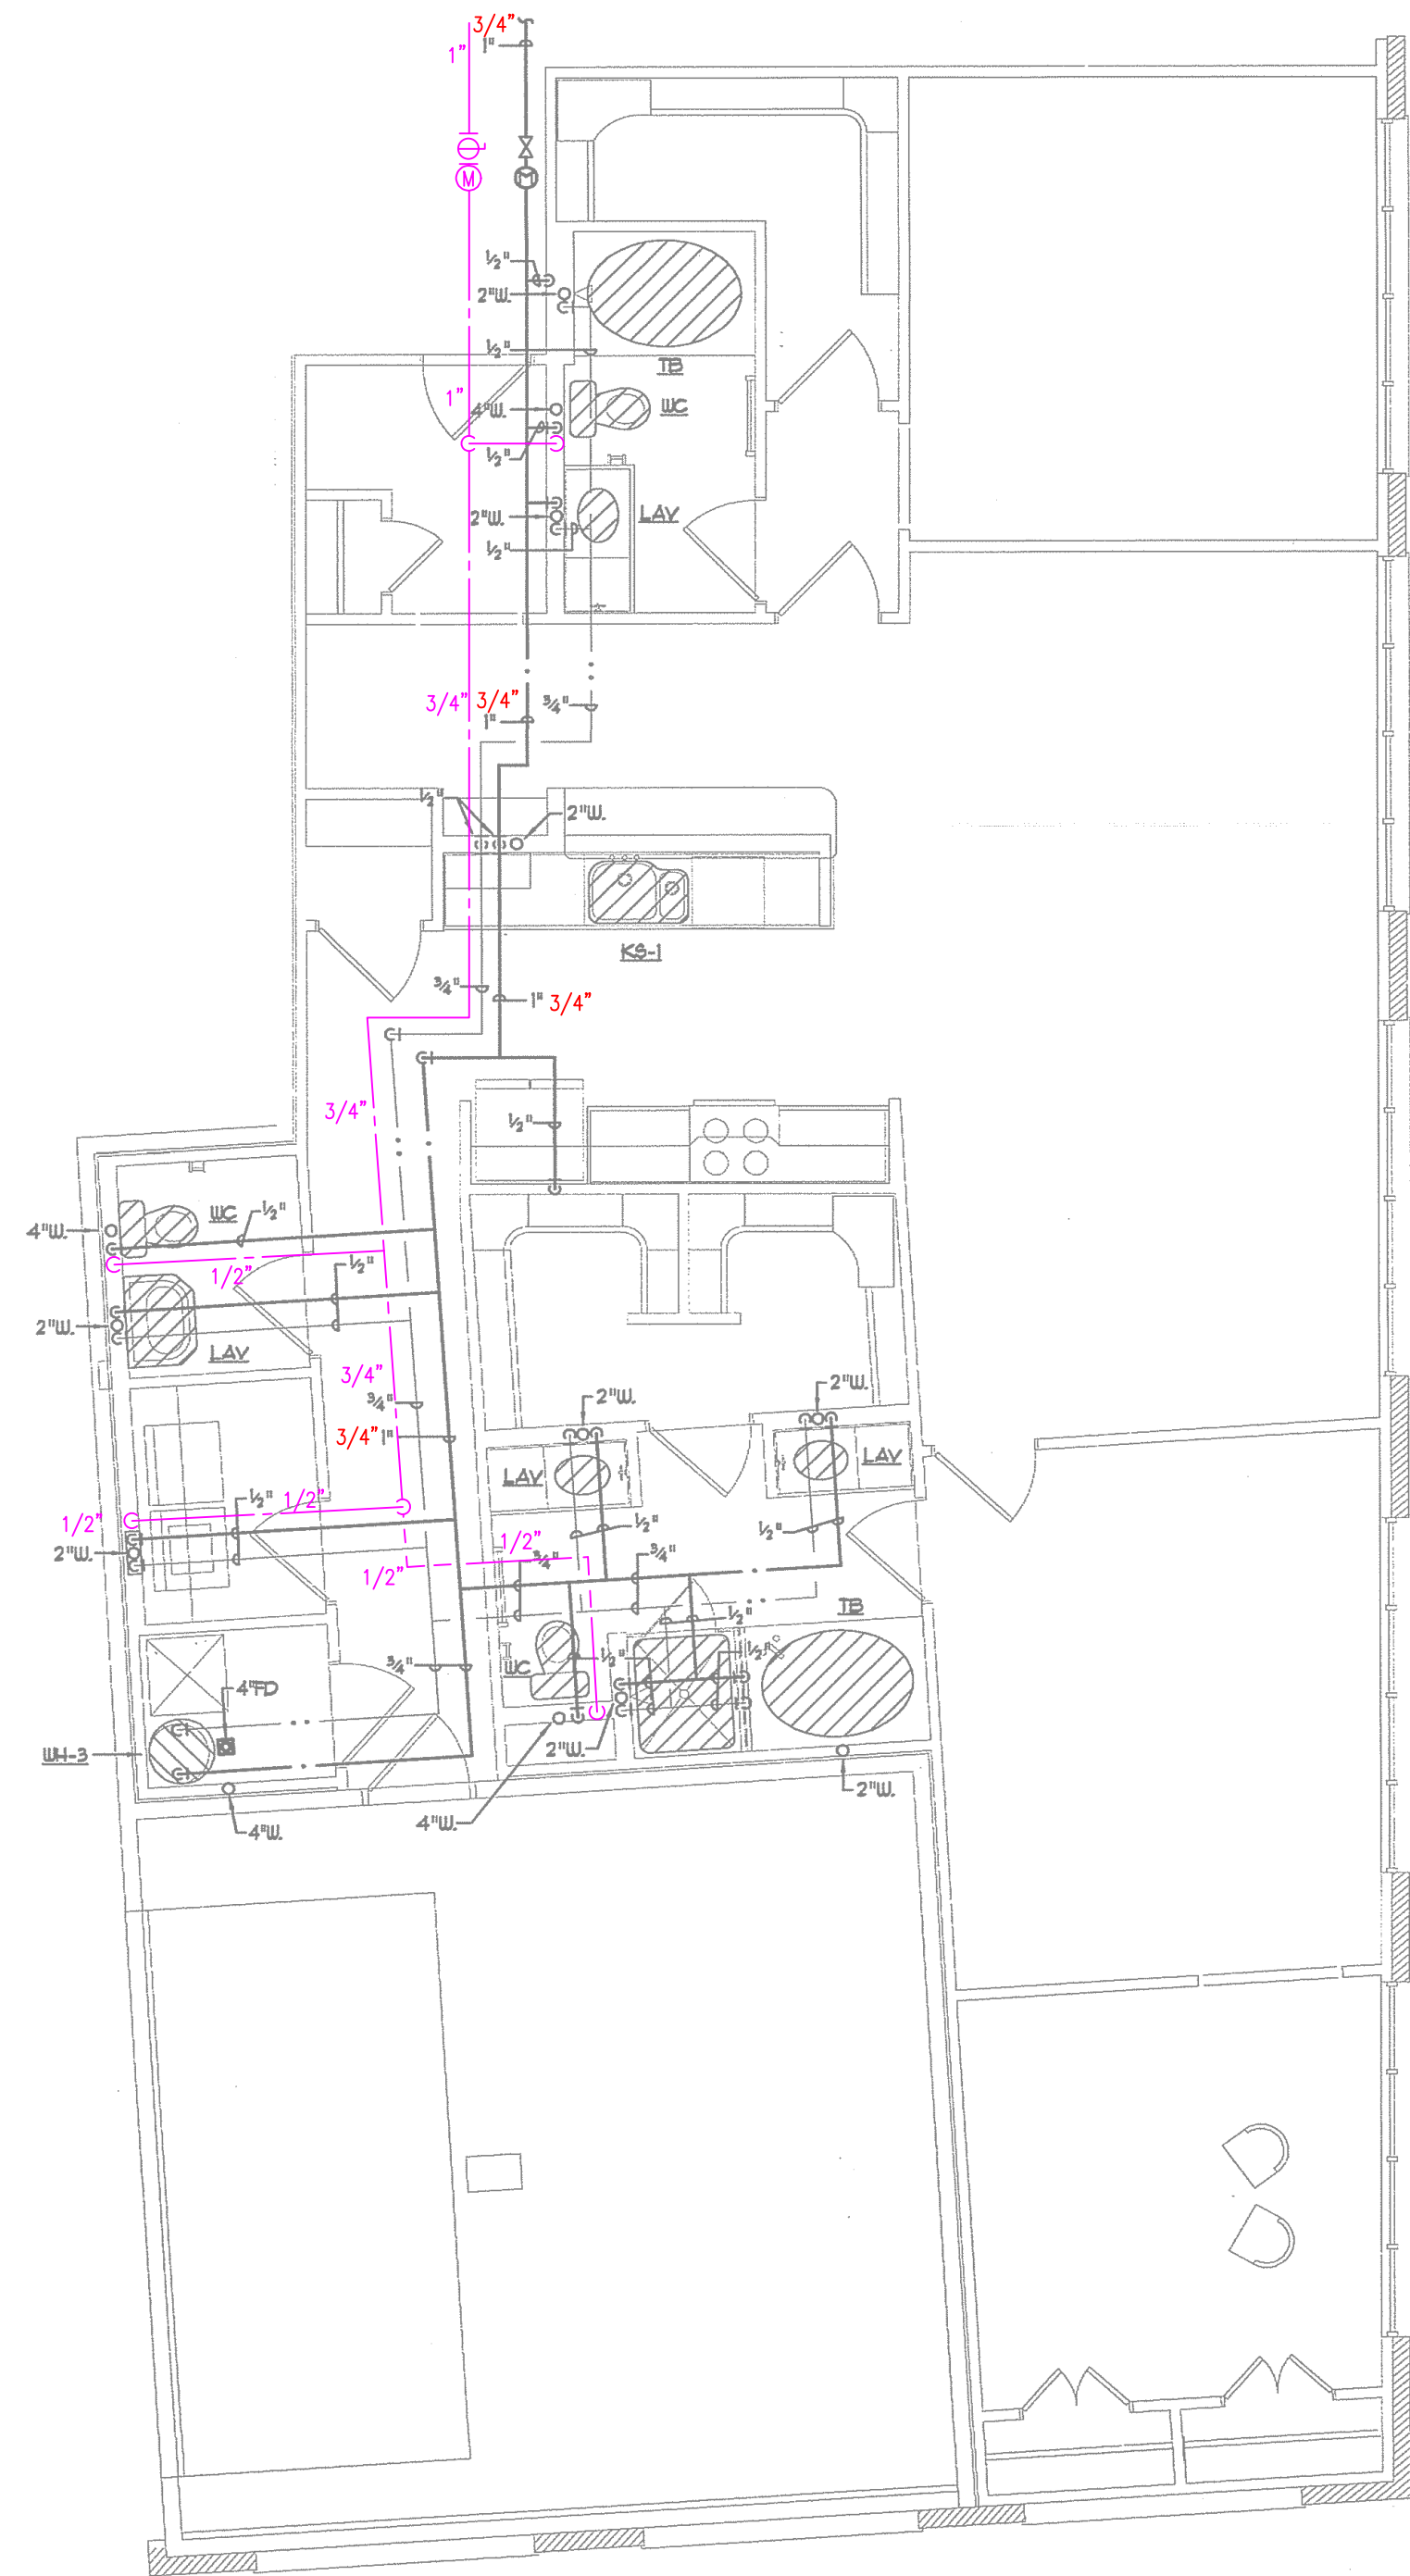

2 UNIT PLAN - B3 - PLUMBING
SCALE: 1/4" = 1'-0"

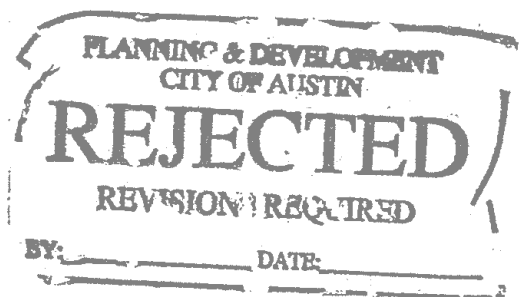

LRK

Looney Ricks Kiss

Architecture Planning Interiors Research
5307 E Mockingbird Lane, Suite 220
Dallas, Texas 75206
Telephone 214-242-7650
Fax 214-242-7655
E-mail info@lrk.com

Multi-Family Plan for:

Gables Residential

6850 Austin Center Blvd, Suite 200

Austin, Texas 78731

Issues and Revisions

No.	Date	Issues and Revisions
01	11.10.06	PERMIT SET
	03.28.07	PERMIT RESUBMITTAL

© 2006 Looney Ricks Kiss Architects, Inc.
Drawings, written material, and design concepts shall not be used or reproduced in whole or part in any form or format without prior written consent of Looney Ricks Kiss Architects, Inc. Do not scale drawings. Use given dimensions only. If not shown, verify correct dimensions with the Architect. Contractor shall check and verify all dimensions and conditions at job site.

Seal



4/5/07

Project Number: 01.06006.00

Project Name:

5th Street Commons

5th Street


Austin, Texas

Drawing Name:

Drawn By:

Checked By:

P109

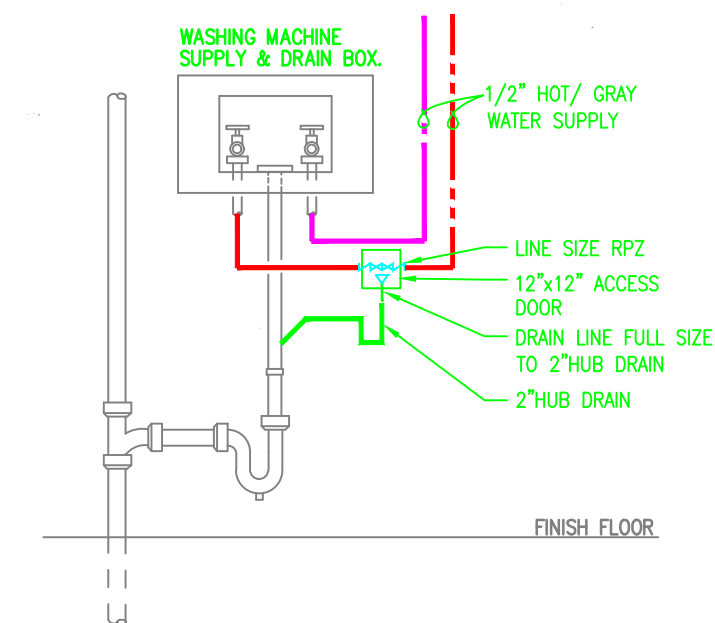The logo for Looney Ricks Kiss, featuring the stylized letters 'LRK' in a large, thin, sans-serif font, with the full name 'Looney Ricks Kiss' in a smaller, bold, sans-serif font below it, all enclosed in a thin black rectangular border.

Multi-Family Plan for:

Gables Residential

6850 Austin Center Blvd, Suite 200

Austin, Texas 78731

© 2006 Looney Ricks Kiss Architects, Inc.
Drawings, written material, and design concepts shall not be used or reproduced in whole or part in any form or format without prior written consent of Looney Ricks Kiss Architects, Inc. Do not scale drawings. Use given dimensions only. If not shown, verify correct dimensions with the Architect. Contractor shall check and verify all dimensions and conditions at job site.

Project Number: 01.06006.00

Project Name:



5th Street Commons


5th Street

Austin, Texas


Drawing Name:

P110

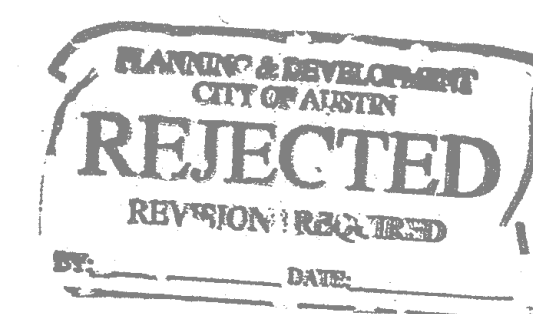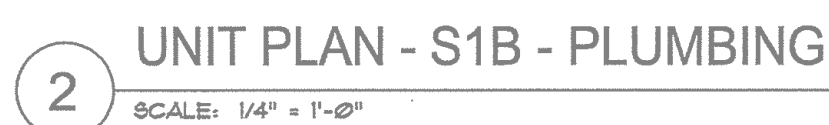


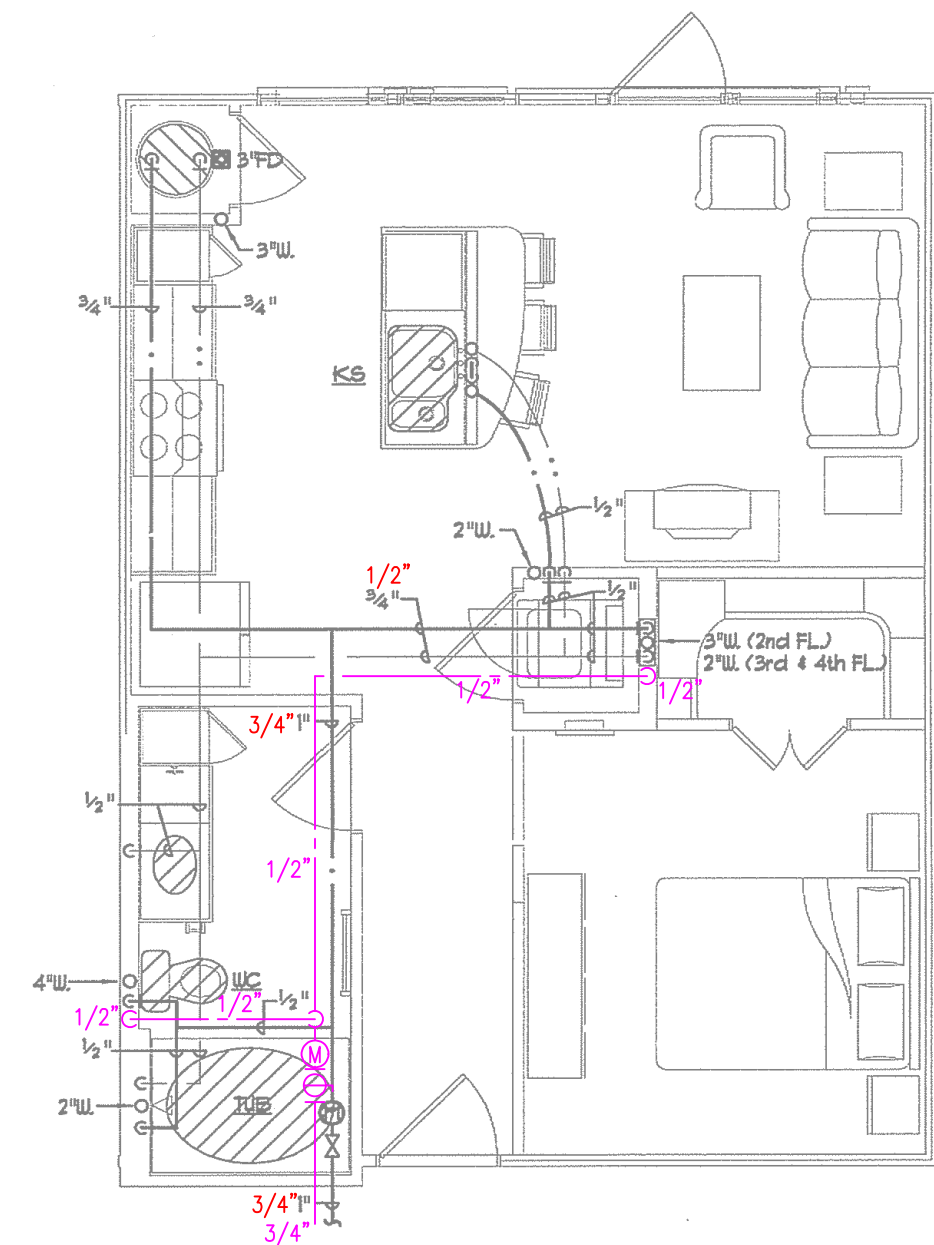


1 UNIT PLAN - S1A1 - PLUMBING
SCALE: 1/4" = 1'-0"

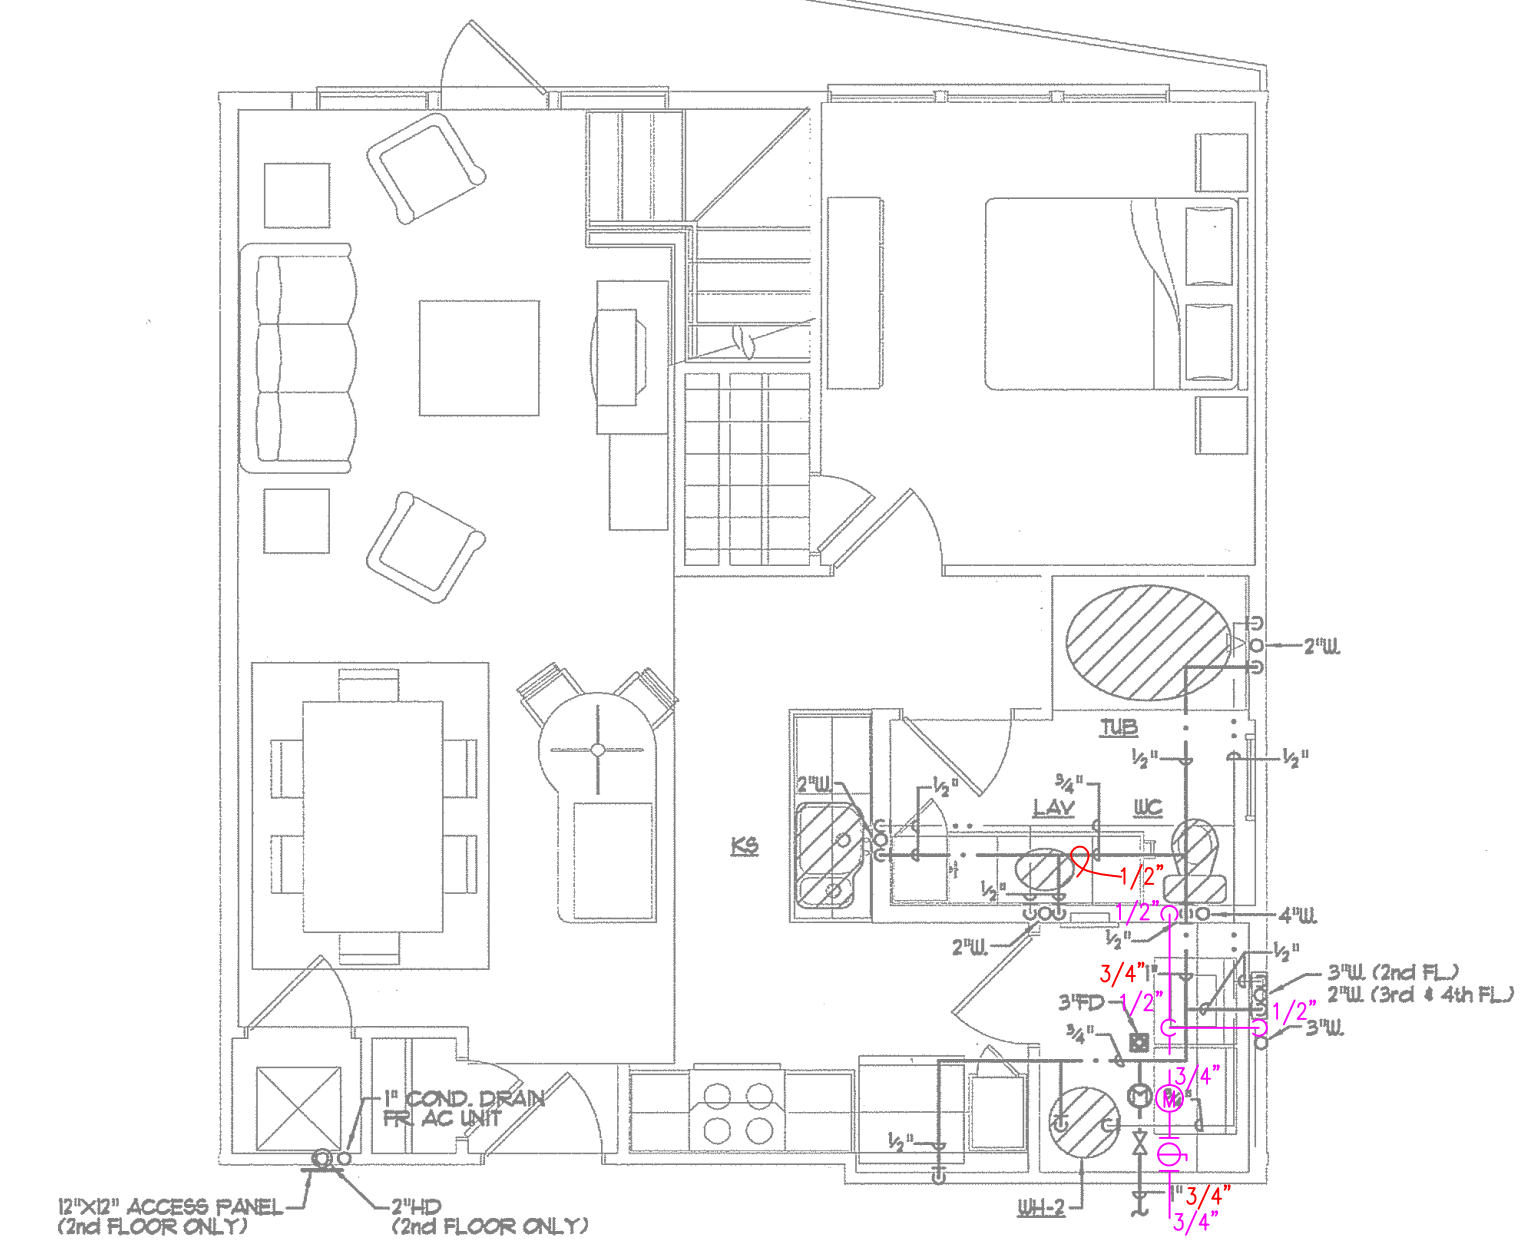

2 UNIT PLAN - A1LA-1 - PLUMBING
SCALE: 1/4" = 1'-0"

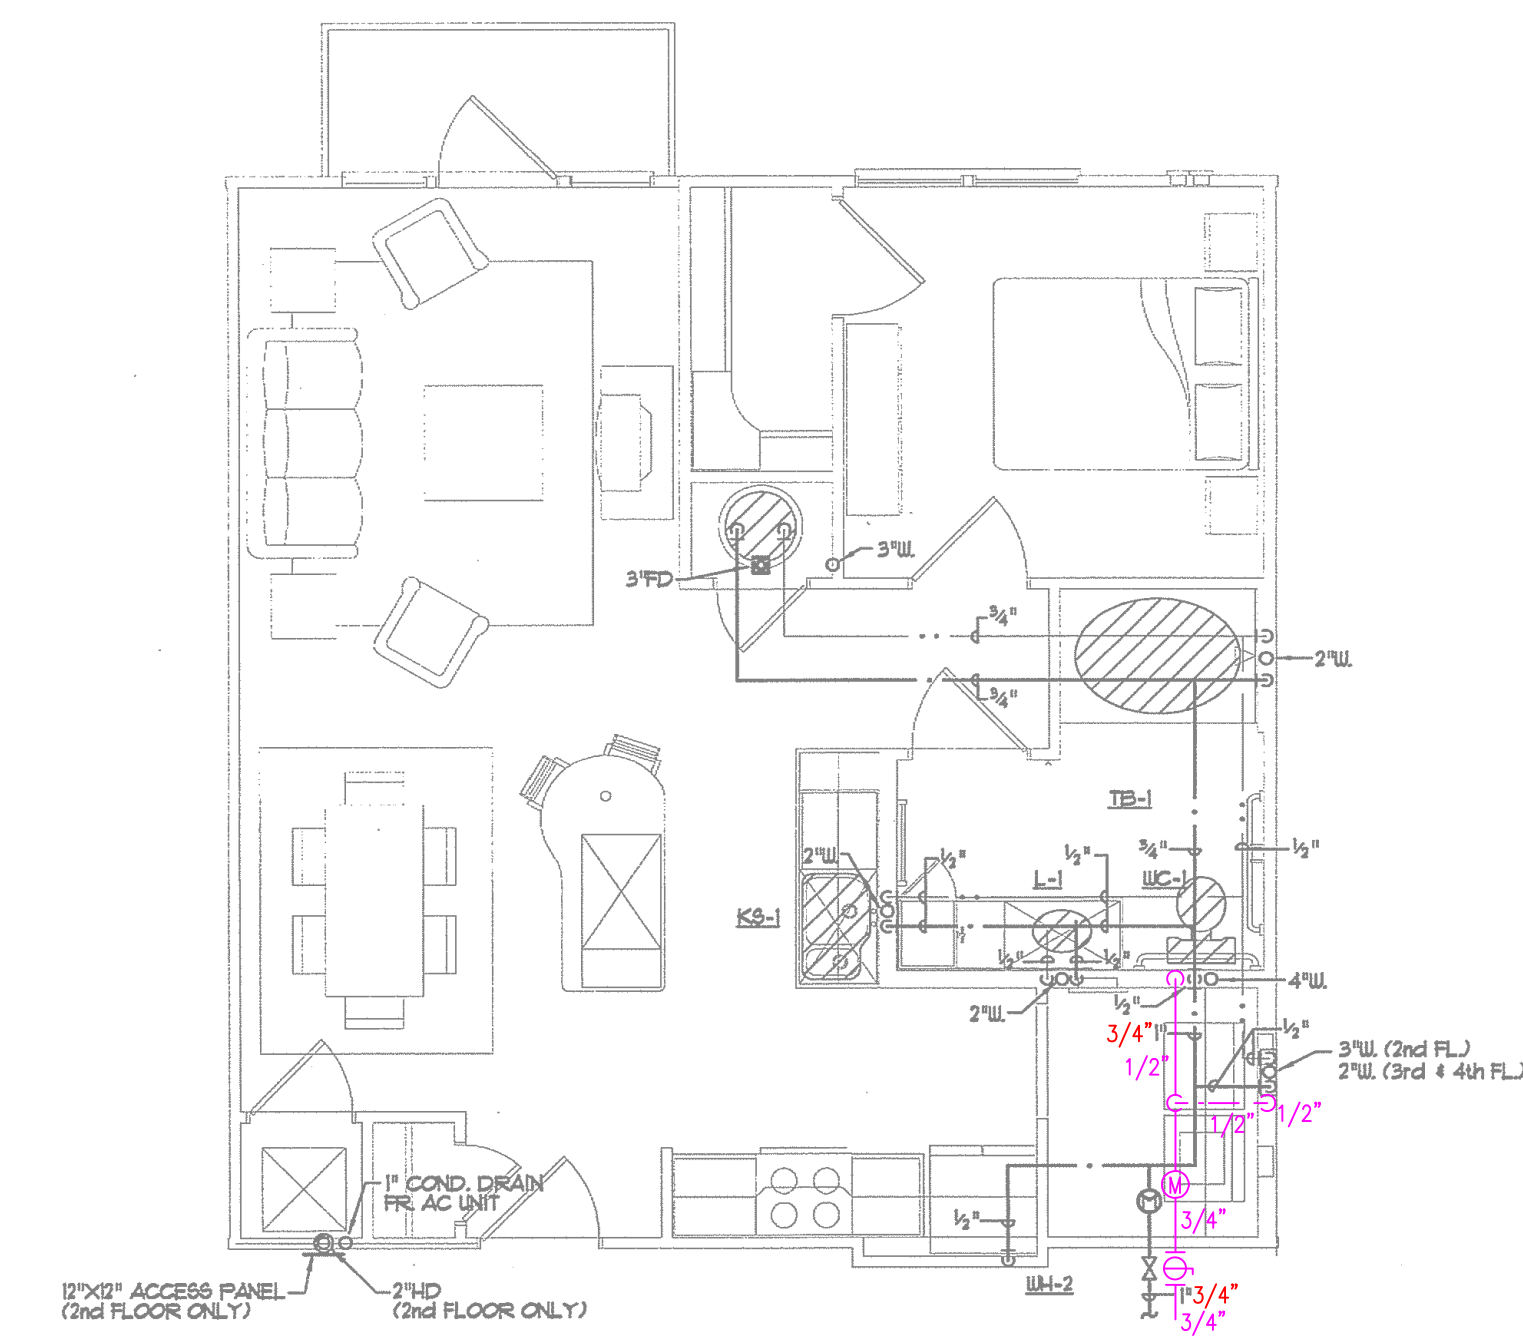


3 UNIT PLAN - A1BHC - PLUMBING
SCALE: 1/4" = 1'-0"

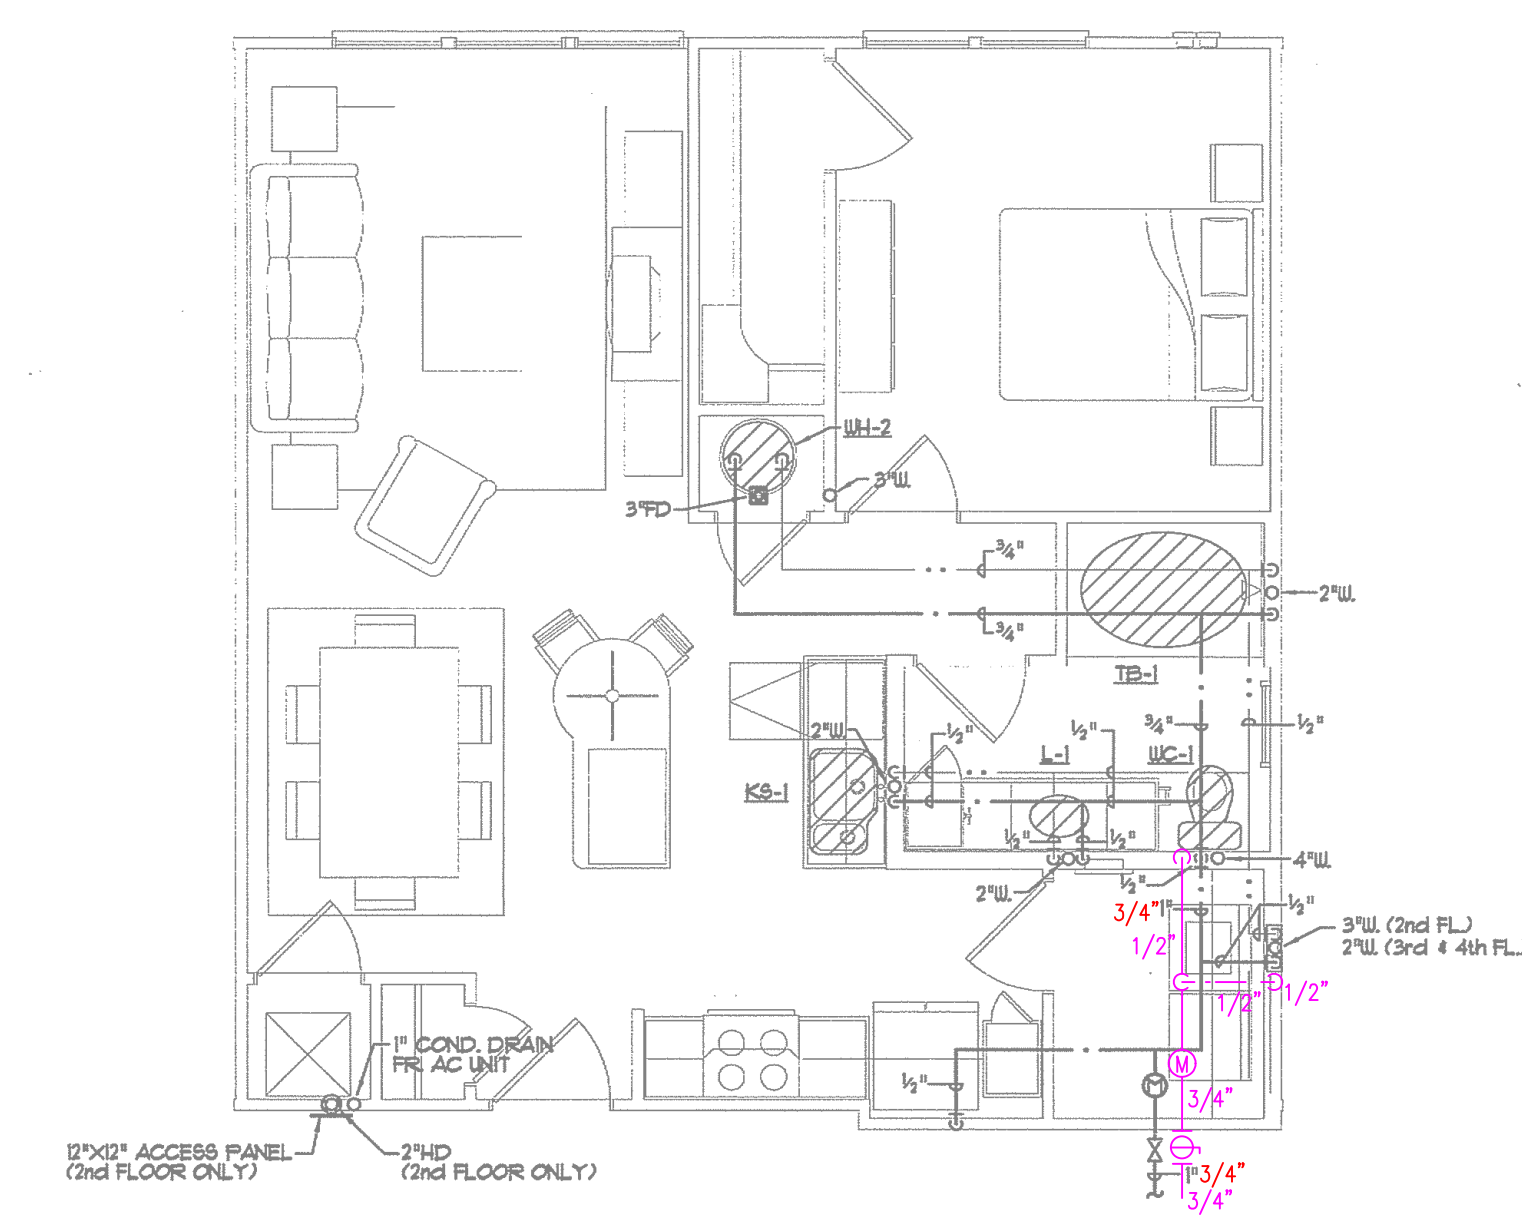

4 UNIT PLAN - A1A5 - PLUMBING
SCALE: 1/4" = 1'-0"

PLUMBING LEGEND	
	DOMESTIC WATER SUPPLY PIPING
	GRAY WATER SUPPLY PIPING
	DOMESTIC WATER SUPPLY PIPING SIZE REDUCTION

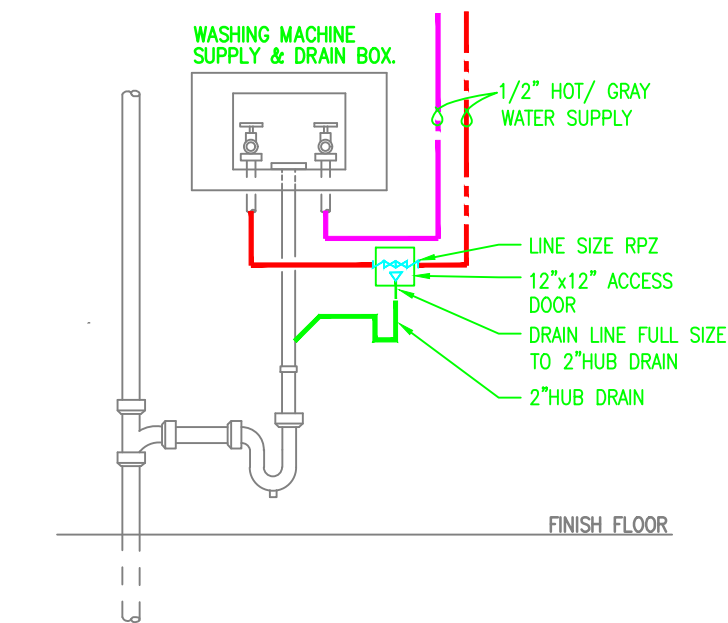

RPZ/HUB DRAIN @ WASHER BOX
SCALE: NOT TO SCALE




Architecture Planning Interiors Research
5307 E Mockingbird Lane, Suite 220
Dallas, Texas 75206
Telephone 214-242-7650
Fax 214-242-7655
E-mail info@lrk.com

Multi-Family Plan for:
Gables Residential
6850 Austin Center Blvd, Suite 200
Austin, Texas 78731

Issues and Revisions		
No.	Date	Issues and Revisions
01	11.10.06	PERMIT SET
	03.28.07	PERMIT RESUBMITTAL

© 2006 Looney Ricks Kiss Architects, Inc.
Drawings, written material, and design concepts shall not be used or reproduced in whole or part in any form or format without prior written consent of Looney Ricks Kiss Architects, Inc. Do not scale drawings. Use given dimensions only. If not shown, verify correct dimensions with the Architect. Contractor shall check and verify all dimensions and conditions at job site.

Seal

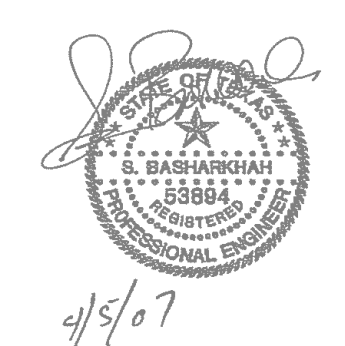

Project Number: 01.06006.00

Project Name:

5th Street Commons


5th Street

Austin, Texas

Drawing Name:

Drawn By:

Checked By:

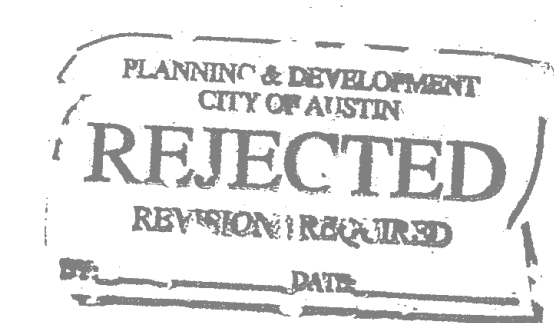


P111



Checked By:

P200A

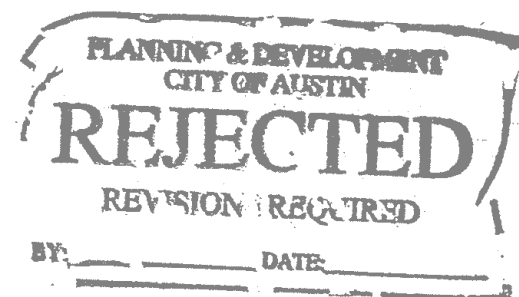

PLUMBING LEGEND	
2"	BASLINE COLD WATER SIZE
2"	DOMESTIC WATER SUPPLY PIPING SIZE REDUCTION
---	GRAY WATER SUPPLY PIPING
2"	GRAY WATER PIPE SIZE

L

R

K

Looney Ricks Kiss

Architecture Planning Interiors Research
5307 E Markingbird Lane, Suite 220
Dallas, Texas 75206
Telephone 214-242-7650
Fax 214-242-7655
E-mail info@lrk.com

Multi-Family Plan for:

Gables Residential

6850 Austin Center Blvd, Suite 200


Austin, Texas 78731

Issues and Revisions

No.	Date	Issues and Revisions
01	11.10.06	PERMIT SET
△	03.28.07	PERMIT RESUBMITTAL

© 2006 Looney Ricks Kiss Architects, Inc.
Drawings, written material, and design concepts shall not be used or reproduced in whole or part in any form or format without prior written consent of Looney Ricks Kiss Architects, Inc. Do not scale drawings. Use given dimensions only. If not shown, verify correct dimensions with the Architect. Contractor shall check and verify all dimensions and conditions at job site.

Seal

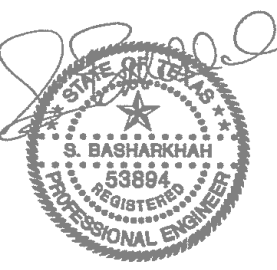

4/5/07

Project Number: 01.06006.00

Project Name:

5th Street Commons

5th Street


Austin, Texas

Drawing Name:

Drawn By:

Checked By:

△**P201A**

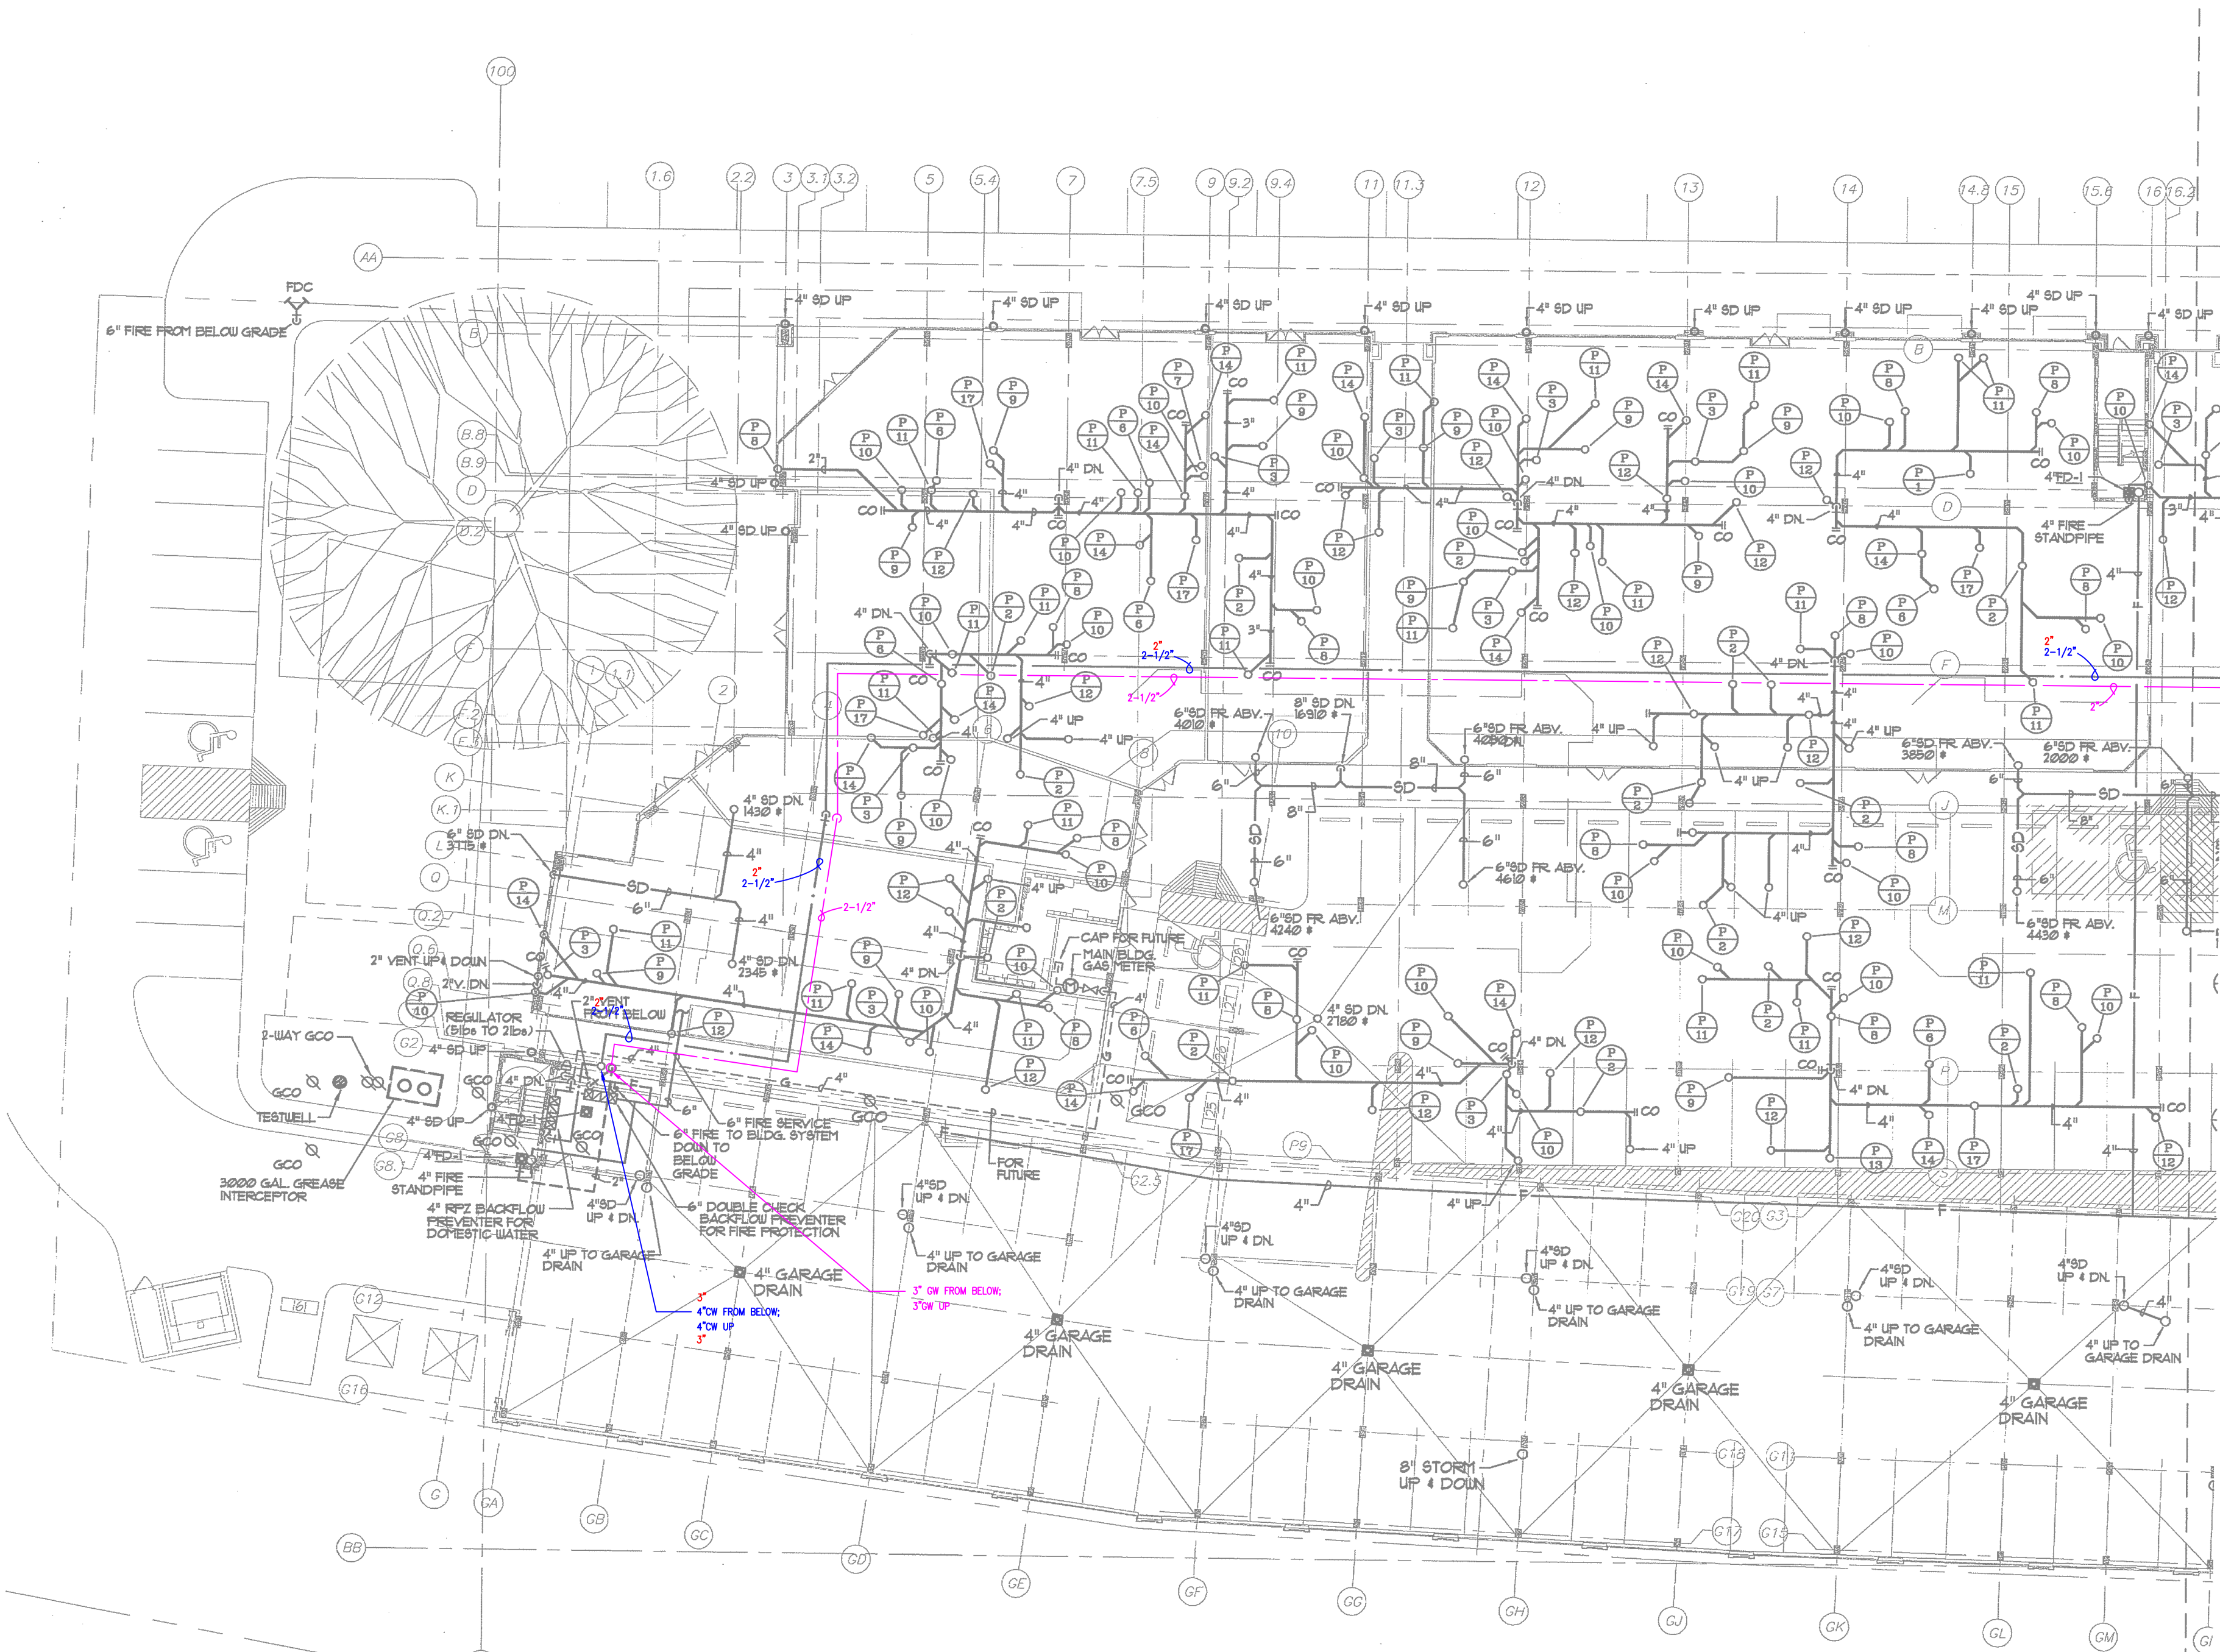

1 PARTIAL FLOOR PLAN - GROUND FLOOR - PLUMBING (WEST)
SCALE: 1/16" = 1'-0"

PLANNING & DEVELOPMENT
CITY OF AUSTIN
REFLECTED
REVISION REQUIRED
BY: _____ DATE: _____

PLUMBING LEGEND	
2"	BASELINE COLD WATER SIZE
2"	DOMESTIC WATER SUPPLY PIPING SIZE REDUCTION
---	GRAY WATER SUPPLY PIPING
2"	GRAY WATER PIPE SIZE

LRK

Looney Ricks Kiss

Architecture Planning Interiors Research
 5307 E Markingbird Lane, Suite 220
 Dallas, Texas 75206
 Telephone 214-242-7650
 Fax 214-242-7655
 E-mail info@lrk.com

Multi-Family Plan for:

Gables Residential

6850 Austin Center Blvd, Suite 200

Austin, Texas 78731

Issues and Revisions		
No.	Date	Issues and Revisions
01	11.10.06	PERMIT SET
△	03.28.07	PERMIT RESUBMITTAL

© 2006 Looney Ricks Kiss Architects, Inc.
 Drawings, written material, and design concepts shall not be used or reproduced in whole or part in any form or format without prior written consent of Looney Ricks Kiss Architects, Inc. Do not scale drawings. Use given dimensions only. If not shown, verify correct dimensions with the Architect. Contractor shall check and verify all dimensions and conditions at job site.

Seal

4/5/07

Project Number: 01.06006.00

Project Name:

5th Street Commons

5th Street

Austin, Texas

Drawing Name:

Drawn By:

Checked By:

△


P201B



1

PARTIAL FLOOR PLAN - GROUND FLOOR - PLUMBING (EAST)

SCALE: 1/16" = 1'-0"

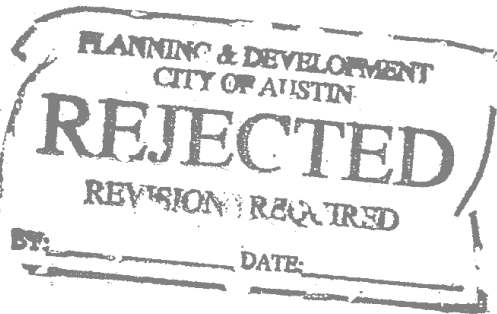

PLUMBING LEGEND	
2"	BASELINE COLD WATER SIZE
2"	DOMESTIC WATER SUPPLY PIPING SIZE REDUCTION
---	GRAY WATER SUPPLY PIPING
2"	GRAY WATER SUPPLY PIPE SIZE

LRK

Looney Ricks Kiss

Architecture Planning Interiors Research
5307 E Mockingbird Lane, Suite 220
Dallas, Texas 75206
Telephone 214-242-7650
Fax 214-242-7655
E-mail info@lrk.com

Multi-Family Plan for:

Gables Residential

6850 Austin Center Blvd, Suite 200

Austin, Texas 78731

Issues and Revisions

No.	Date	Issues and Revisions
01	11.10.06	PERMIT SET
⚠	03.28.07	PERMIT RESUBMITTAL

© 2006 Looney Ricks Kiss Architects, Inc.
Drawings, written material, and design concepts shall not be used or reproduced in whole or part in any form or format without prior written consent of Looney Ricks Kiss Architects, Inc. Do not scale drawings. Use given dimensions only. If not shown, verify correct dimensions with the Architect. Contractor shall check and verify all dimensions and conditions at job site.

Seal



4/5/07

Project Number: 01.06006.00

Project Name:

5th Street Commons

5th Street

Austin, Texas

Drawing Name:


Drawn By:

Checked By:

⚠ P202A



1 PARTIAL FLOOR PLAN -2ND FLOOR - PLUMBING (WEST)
SCALE: 1/16" = 1'-0"

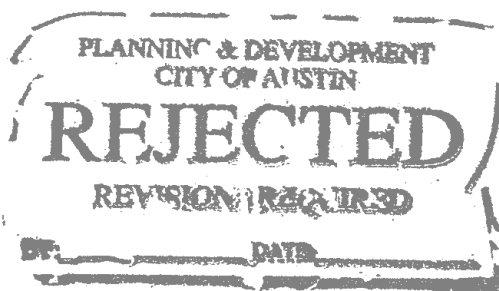

PLUMBING LEGEND	
2"	BASELINE COLD WATER SIZE
2"	DOMESTIC WATER SUPPLY PIPING SIZE REDUCTION
	GRAY WATER SUPPLY PIPING
2"	GRAY WATER PIPE SIZE

L

R

K

Looney Ricks Kiss

Architecture Planning Interiors Research
 5307 E Mockingbird Lane, Suite 220
 Dallas, Texas 75206
 Telephone 214-242-7650
 Fax 214-242-7655
 E-mail info@lrk.com

Multi-Family Plan for:

Gables Residential

6850 Austin Center Blvd, Suite 200

Austin, Texas 78731

Issues and Revisions		
No.	Date	Issues and Revisions
01	11.10.06	PERMIT SET
△	03.28.07	PERMIT RESUBMITTAL

© 2006 Looney Ricks Kiss Architects, Inc.
 Drawings, written material, and design concepts shall not be used or reproduced in whole or part in any form or format without prior written consent of Looney Ricks Kiss Architects, Inc. Do not scale drawings. Use given dimensions only. If not shown, verify correct dimensions with the Architect. Contractor shall check and verify all dimensions and conditions at job site.

Seal

4/5/07

Project Number: 01.06006.00

Project Name:

5th Street Commons

5th Street

Austin, Texas

Drawing Name:

Drawn By:

Checked By:


△ P202B



1

PARTIAL FLOOR PLAN - 2ND FLOOR - PLUMBING (EAST)

SCALE: 1/16" = 1'-0"

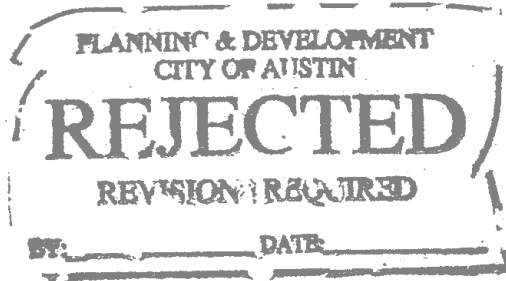

PLUMBING LEGEND	
2"	BASELINE COLD WATER SIZE
2"	DOMESTIC WATER SUPPLY PIPING SIZE REDUCTION
	GRAY WATER SUPPLY PIPING
2"	GRAY WATER PIPE SIZE

L R K

Looney Ricks Kiss

Architecture Planning Interiors Research
5307 E Mockingbird Lane, Suite 220
Dallas, Texas 75206
Telephone 214-242-7650
Fax 214-242-7655
E-mail info@lrk.com

Multi-Family Plan for:

Gables Residential
6850 Austin Center Blvd, Suite 200
Austin, Texas 78731

Issues and Revisions

No.	Date	Issues and Revisions
01	11.10.06	PERMIT SET
△	03.28.07	PERMIT RESUBMITTAL

© 2006 Looney Ricks Kiss Architects, Inc.
Drawings, written material, and design concepts shall not be used or reproduced in whole or part in any form or format without prior written consent of Looney Ricks Kiss Architects, Inc. Do not scale drawings. Use given dimensions only. If not shown, verify correct dimensions with the Architect. Contractor shall check and verify all dimensions and conditions at job site.

Seal



4/5/07

Project Number: 01.06006.00

Project Name:

5th Street Commons

5th Street

Austin, Texas

Drawing Name:


Drawn By:

Checked By:

P203B



1 PARTIAL FLOOR PLAN - 3RD FLOOR - PLUMBING (EAST)
SCALE: 1/16" = 1'-0"

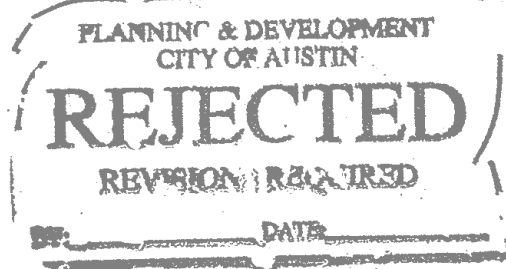

PLUMBING LEGEND	
2"	BASLINE COLD WATER SIZE
2"	DOMESTIC WATER SUPPLY PIPING SIZE REDUCTION
---	GRAY WATER SUPPLY PIPING
2"	GRAY WATER PIPE SIZE

LRK

Looney Ricks Kiss

Architecture Planning Interiors Research

5307 E Mockingbird Lane, Suite 220

Dallas, Texas 75206

Telephone 214-242-7650

Fax 214-242-7655

E-mail info@lrk.com

Multi-Family Plan for:

Gables Residential

6850 Austin Center Blvd, Suite 200

Austin, Texas 78731

Issues and Revisions		
No.	Date	Issues and Revisions
01	11.10.06	PERMIT SET
Δ	03.28.07	PERMIT RESUBMITTAL

© 2006 Looney Ricks Kiss Architects, Inc.
Drawings, written materials, and design concepts shall not be used or reproduced in whole or part in any form or format without prior written consent of Looney Ricks Kiss Architects, Inc. Do not scale drawings. Use given dimensions only. If not shown, verify correct dimensions with the Architect. Contractor shall check and verify all dimensions and conditions at job site.

Seal

4/5/07

Project Numbers: 01.06006.00

Project Name:

5th Street Commons

5th Street

Austin, Texas

Drawing Name:

Drawn By:

Checked By:

Δ **P204B**

1

PARTIAL FLOOR PLAN - 4TH FLOOR - PLUMBING (EAST)

SCALE: 1/16" = 1'-0"