


TPOLOGY 20

Commercial/Laundry

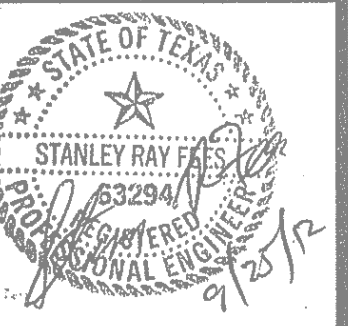

FEES ENGINEERING

(Firm No. F-2031)
1630 Coldwater Hollow
Buda, Texas 78610
(512)-285-6521

McCANN AND ASSOCIATES
2111 DICKSON DRIVE, SUITE #28
AUSTIN, TEXAS 78704
(512) 707-9406



SpinZone SoCo
2424 SOUTH CONGRESS AVE.
AUSTIN, TX 78704




PLUMBING WATER PLAN

JOB No:
12-01

DATE: 09/14/12

DRAWN BY: PSB

SHEET No.
P2 OF **6**

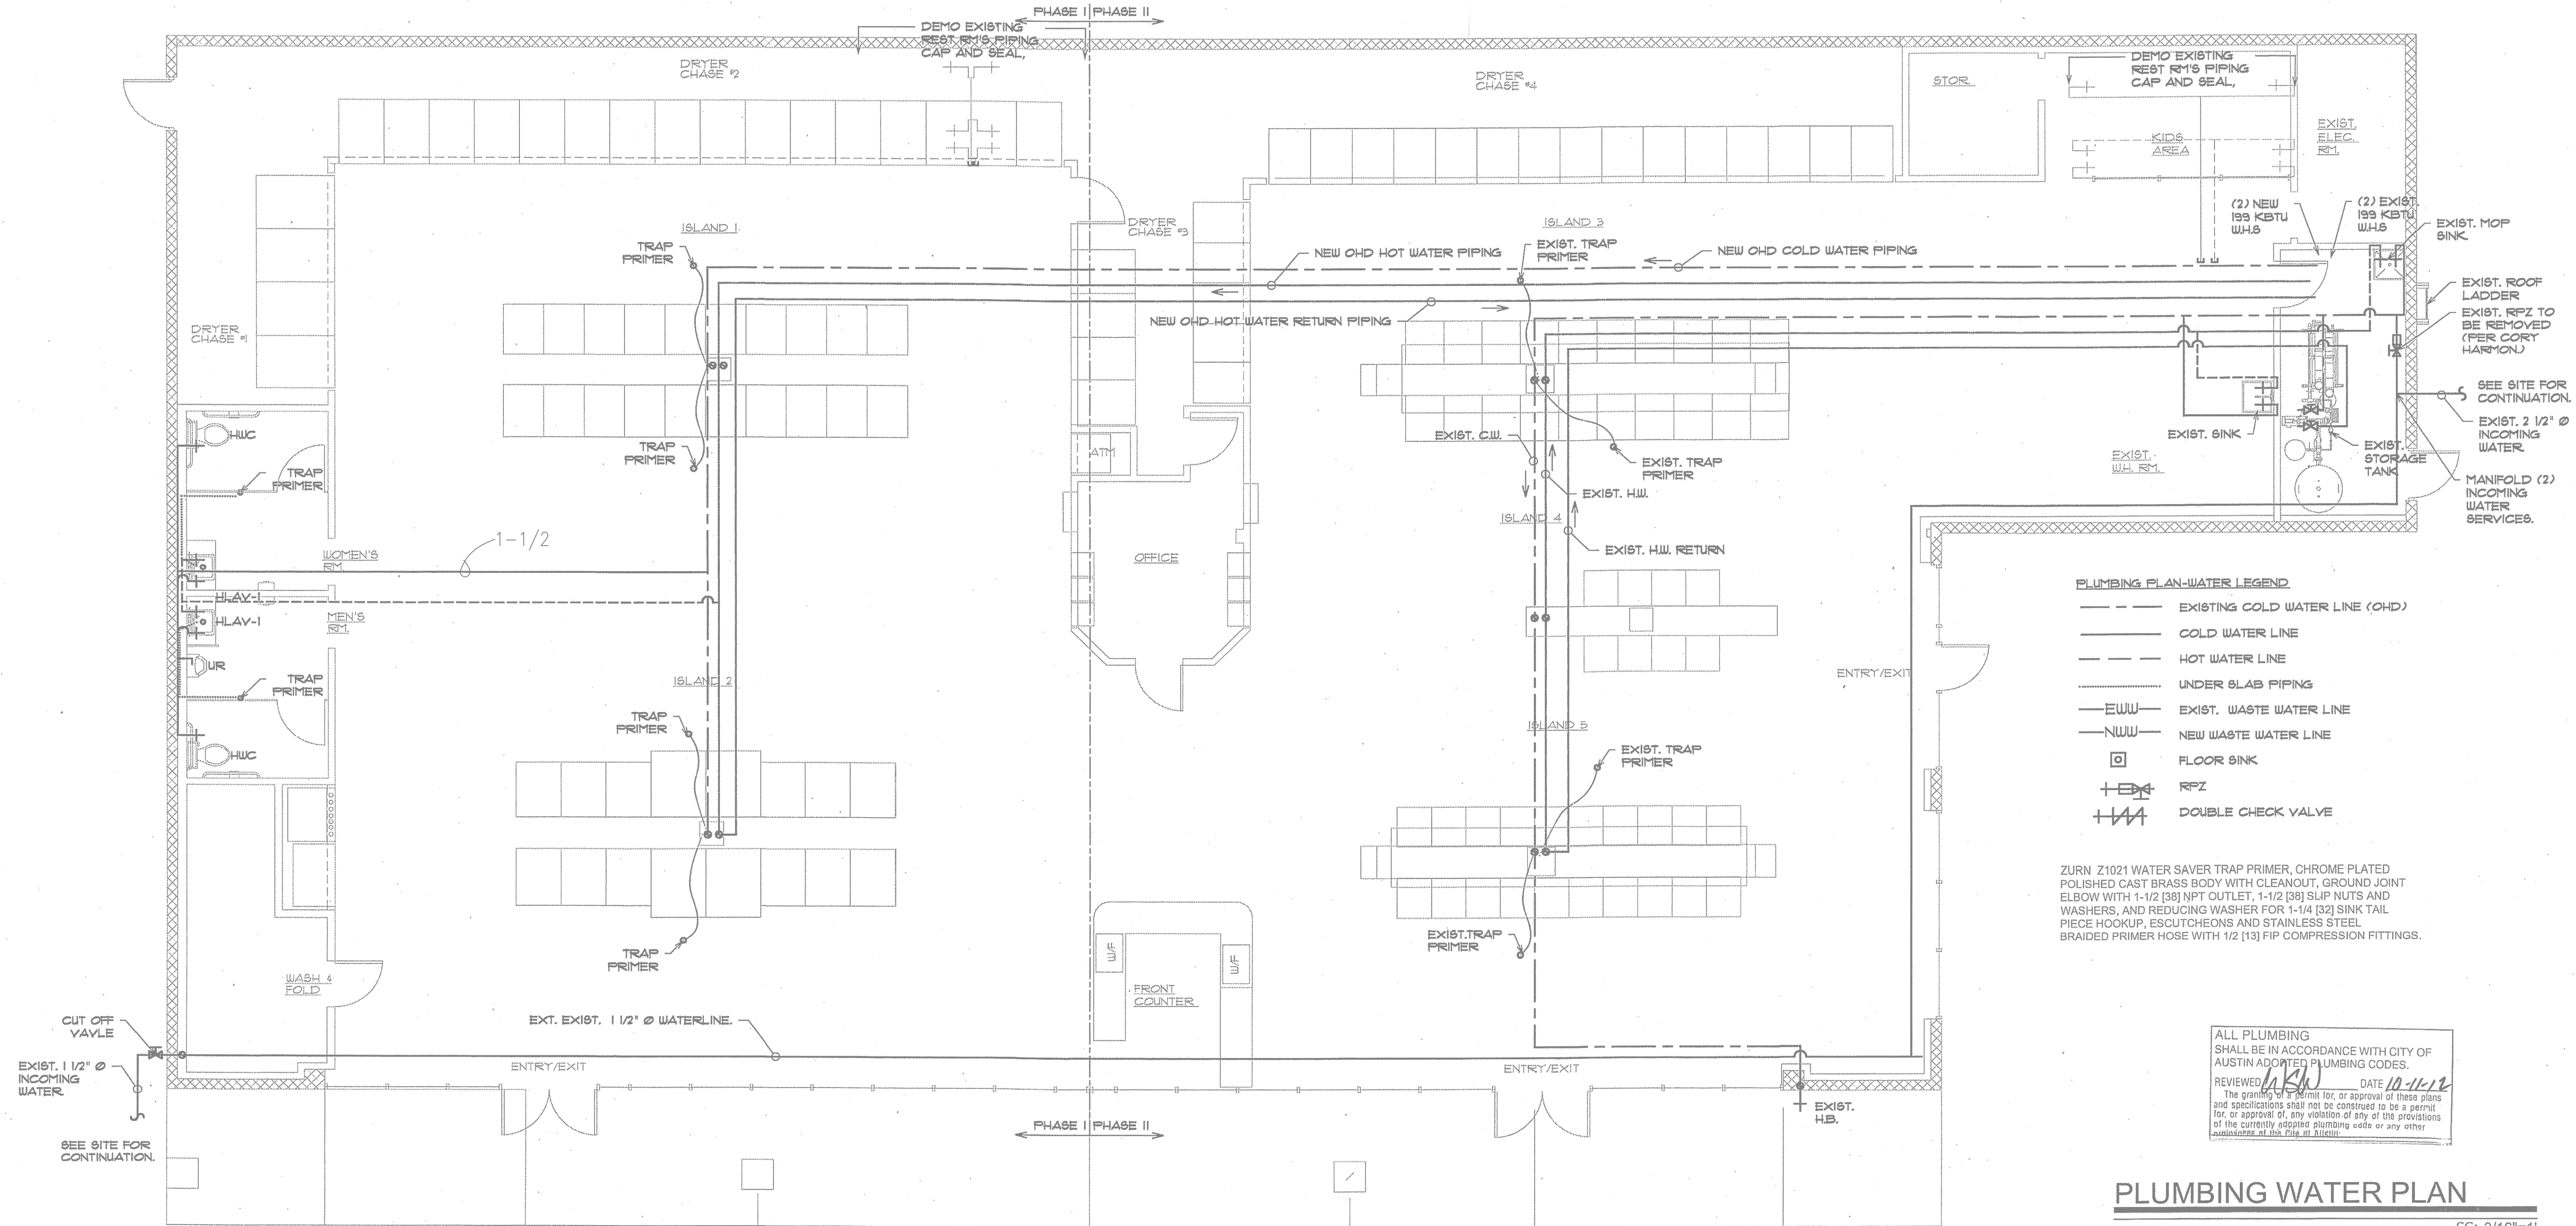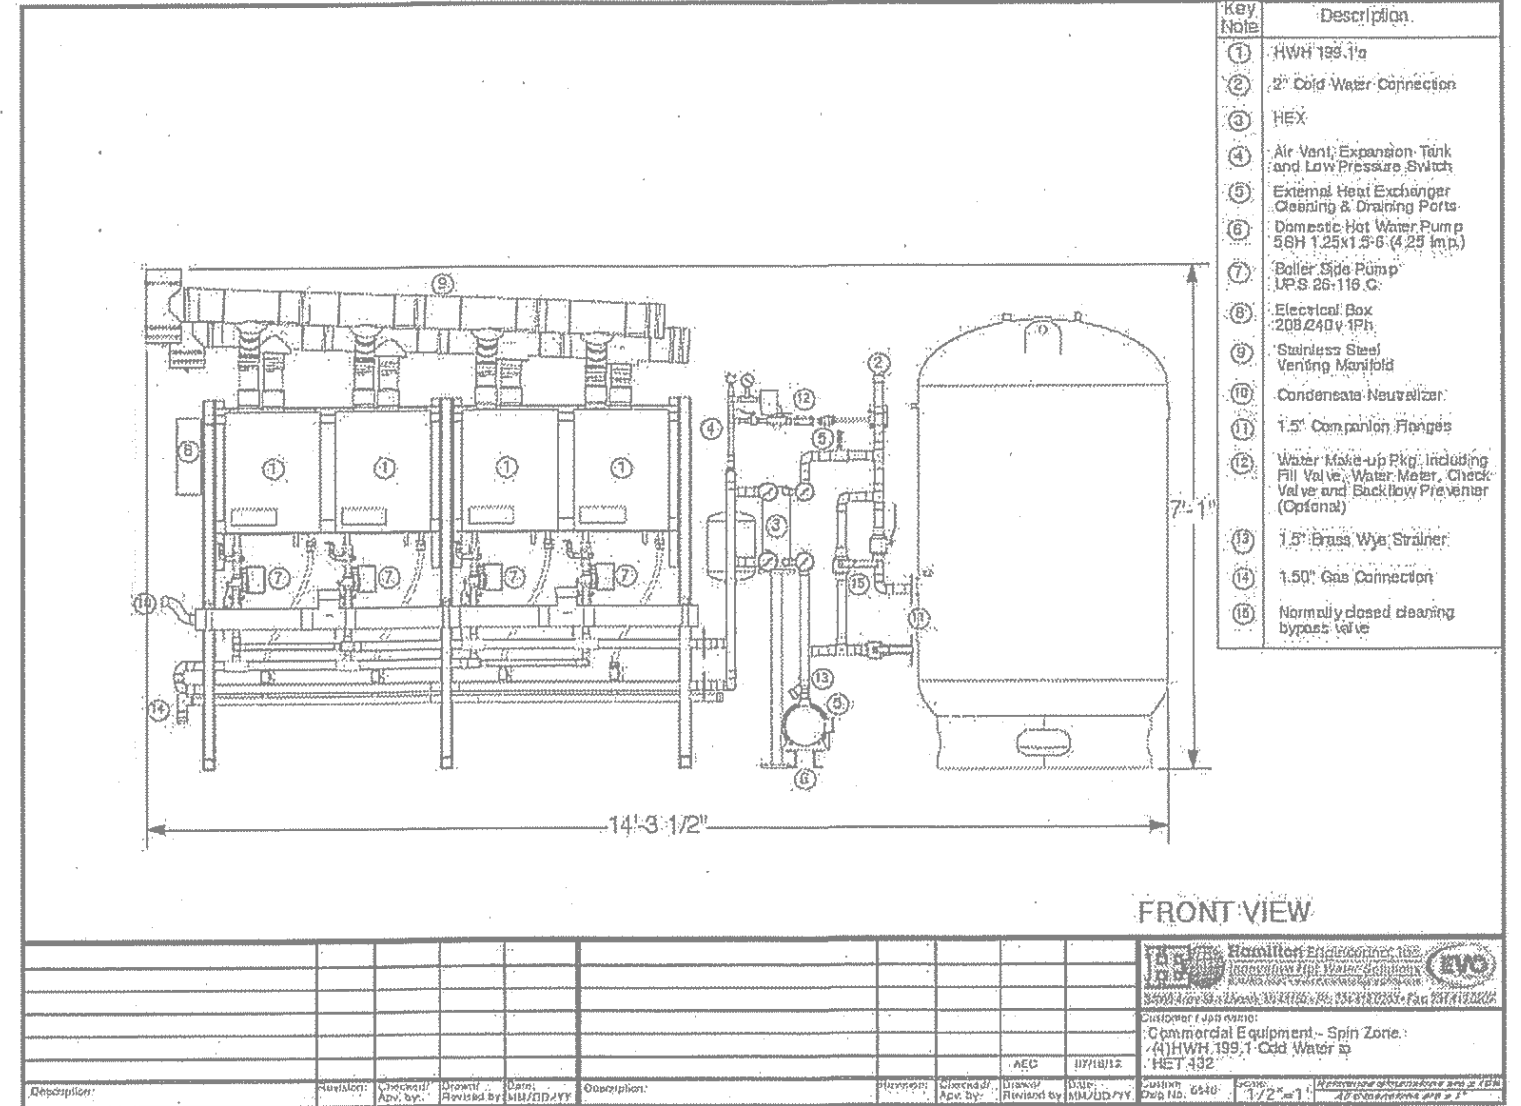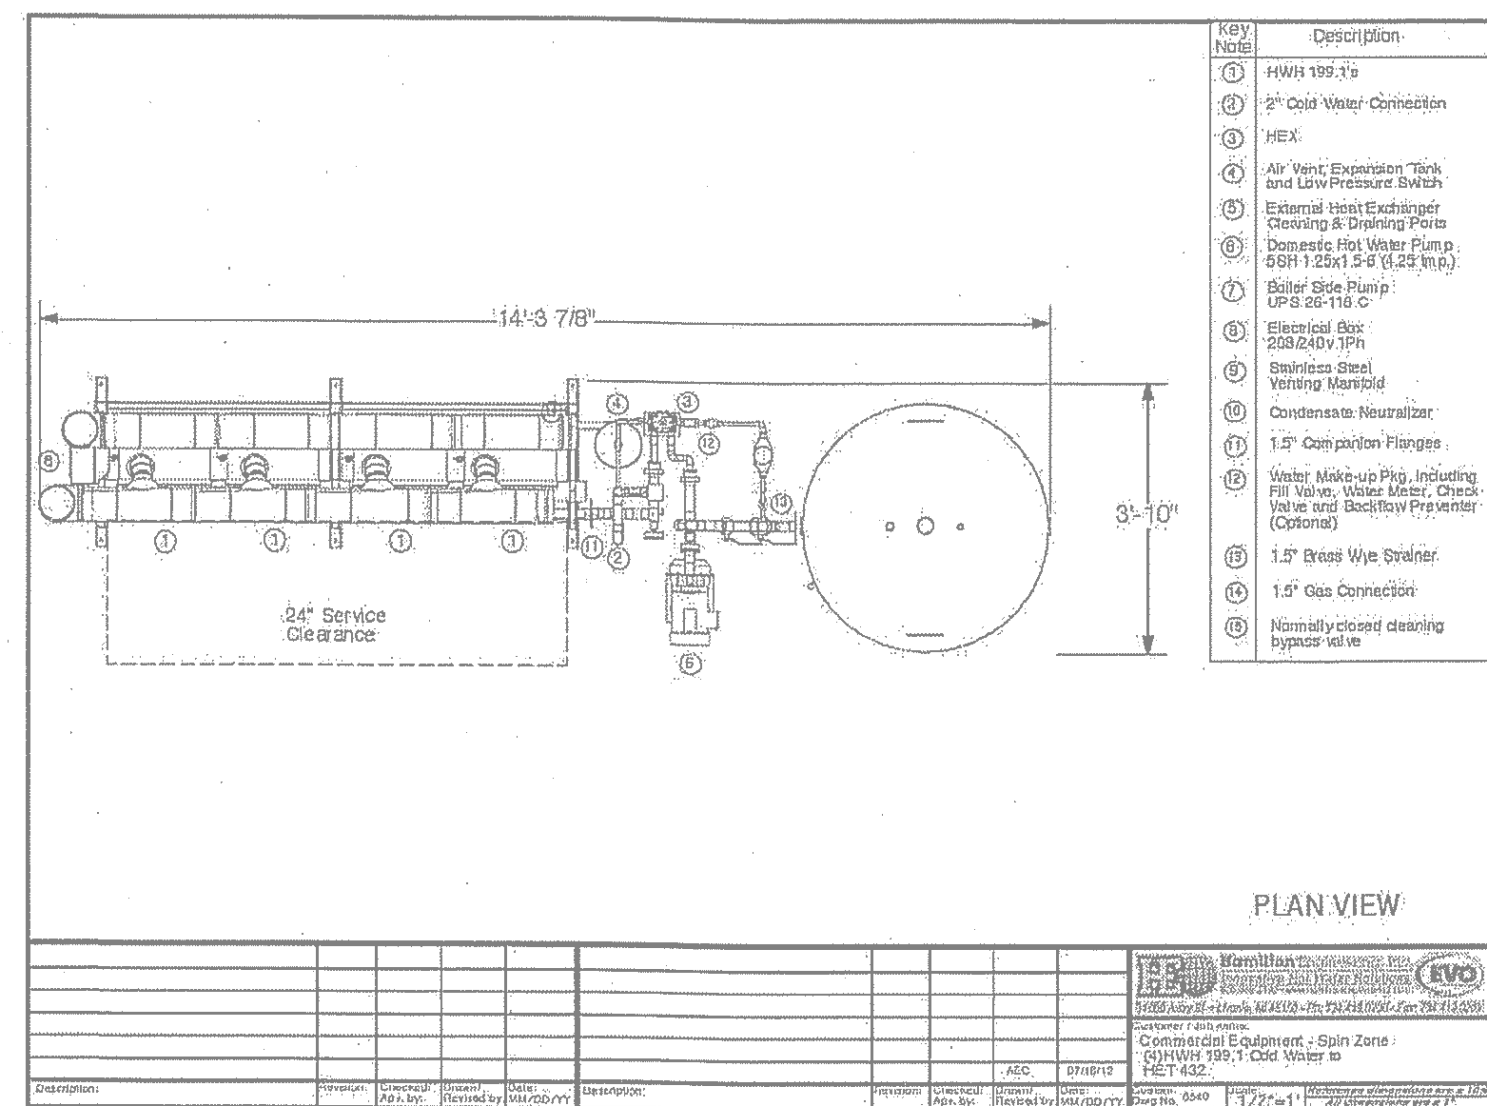

- PLUMBING PLAN-WATER LEGEND**
- EXISTING COLD WATER LINE (CHD)
 - COLD WATER LINE
 - HOT WATER LINE
 - UNDER SLAB PIPING
 - EWU --- EXIST. WASTE WATER LINE
 - NWU --- NEW WASTE WATER LINE
 - ⊠ FLOOR SINK
 - +BX+ RPZ
 - +H+ DOUBLE CHECK VALVE

ZURN Z1021 WATER SAVER TRAP PRIMER, CHROME PLATED POLISHED CAST BRASS BODY WITH CLEANOUT, GROUND JOINT ELBOW WITH 1-1/2 [38] NPT OUTLET, 1-1/2 [38] SLIP NUTS AND WASHERS, AND REDUCING WASHER FOR 1-1/4 [32] SINK TAIL PIECE HOOKUP, ESCUTCHEONS AND STAINLESS STEEL BRAIDED PRIMER HOSE WITH 1/2 [13] FIP COMPRESSION FITTINGS.

ALL PLUMBING SHALL BE IN ACCORDANCE WITH CITY OF AUSTIN ADOPTED PLUMBING CODES.
REVIEWED *[Signature]* DATE *10-11-12*
The granting of a permit for, or approval of these plans for, or approval of any violation of any of the provisions of the currently adopted plumbing code or any other regulations at the City of Austin.


PLUMBING WATER PLAN

SC: 3/16"-1"

NOTE: BEFORE PROCEEDING WITH ANY WORK OR ORDERING ANY MATERIALS, THE CONTRACTOR AND/OR SUBCONTRACTOR SHALL VERIFY ALL MEASUREMENTS AND LOCATIONS OF BUILDING COMPONENTS AND THEIR INTERRELATIONSHIP AT THE BUILDING SITE, AND SHALL BE RESPONSIBLE FOR THEIR CORRECTNESS.

© Copyright 2012, SpinZone & Associates

NOTES: BEFORE PROCEEDING WITH ANY WORK OR ORDERING ANY MATERIALS, THE CONTRACTOR AND/OR SUBCONTRACTOR SHALL VERIFY ALL MEASUREMENTS AND LOCATIONS OF BUILDING COMPONENTS AND THEIR INTERRELATIONSHIP AT THE BUILDING SITE, AND SHALL BE RESPONSIBLE FOR THEIR CORRECTNESS.

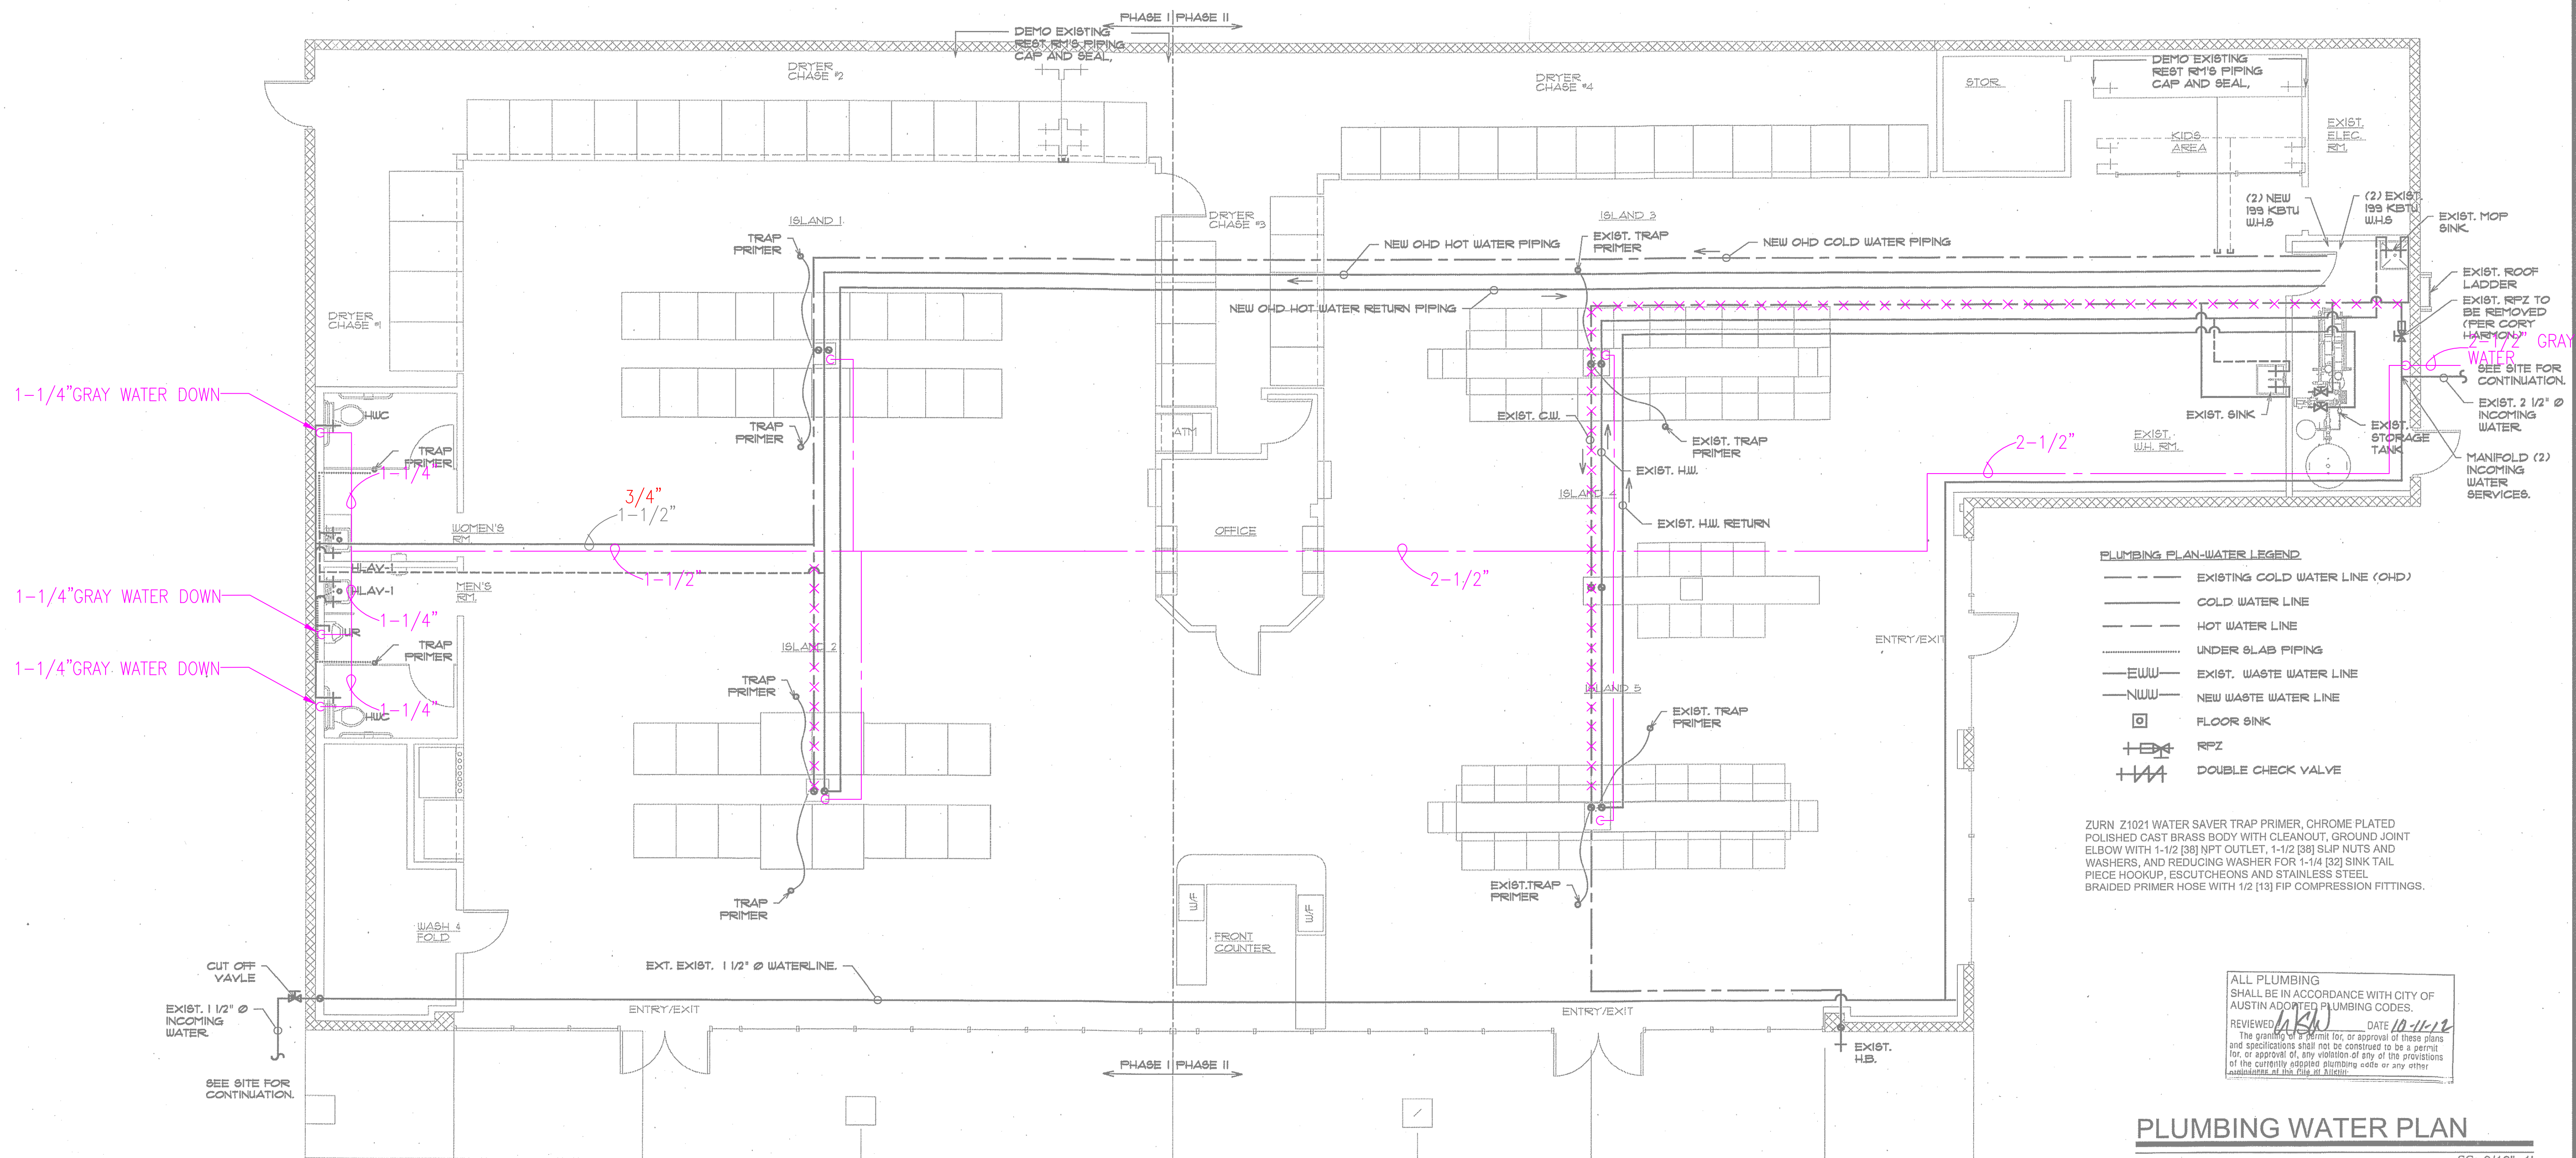

ALL PLUMBING SHALL BE IN ACCORDANCE WITH CITY OF AUSTIN ADOPTED PLUMBING CODES.
REVIEWED: *ASW* DATE: *12-14-12*
The granting of a permit for, or approval of these plans and specifications shall not be construed to be a permit for, or approval of, any violation of any of the provisions of the currently adopted plumbing code or any other applicable code or regulation.

PLUMBING WATER PLAN

SC: 3/16"=1'



PLUMBING LEGEND

GRAY WATER SUPPLY PIPING
2" DOMESTIC WATER SUPPLY PIPING SIZE REDUCTION

PLUMBING PLAN-WATER LEGEND

- EXISTING COLD WATER LINE (CHD)
- COLD WATER LINE
- HOT WATER LINE
- UNDER SLAB PIPING
- EXIST. WASTE WATER LINE
- NEW WASTE WATER LINE
- FLOOR SINK
- RPZ
- DOUBLE CHECK VALVE

ZURN Z1021 WATER SAVER TRAP PRIMER, CHROME PLATED POLISHED CAST BRASS BODY WITH CLEANOUT, GROUND JOINT ELBOW WITH 1-1/2 [38] NPT OUTLET, 1-1/2 [38] SLIP NUTS AND WASHERS, AND REDUCING WASHER FOR 1-1/4 [32] SINK TAIL PIECE HOOKUP, ESCUTCHEONS AND STAINLESS STEEL BRAIDED PRIMER HOSE WITH 1/2 [13] FIP COMPRESSION FITTINGS.

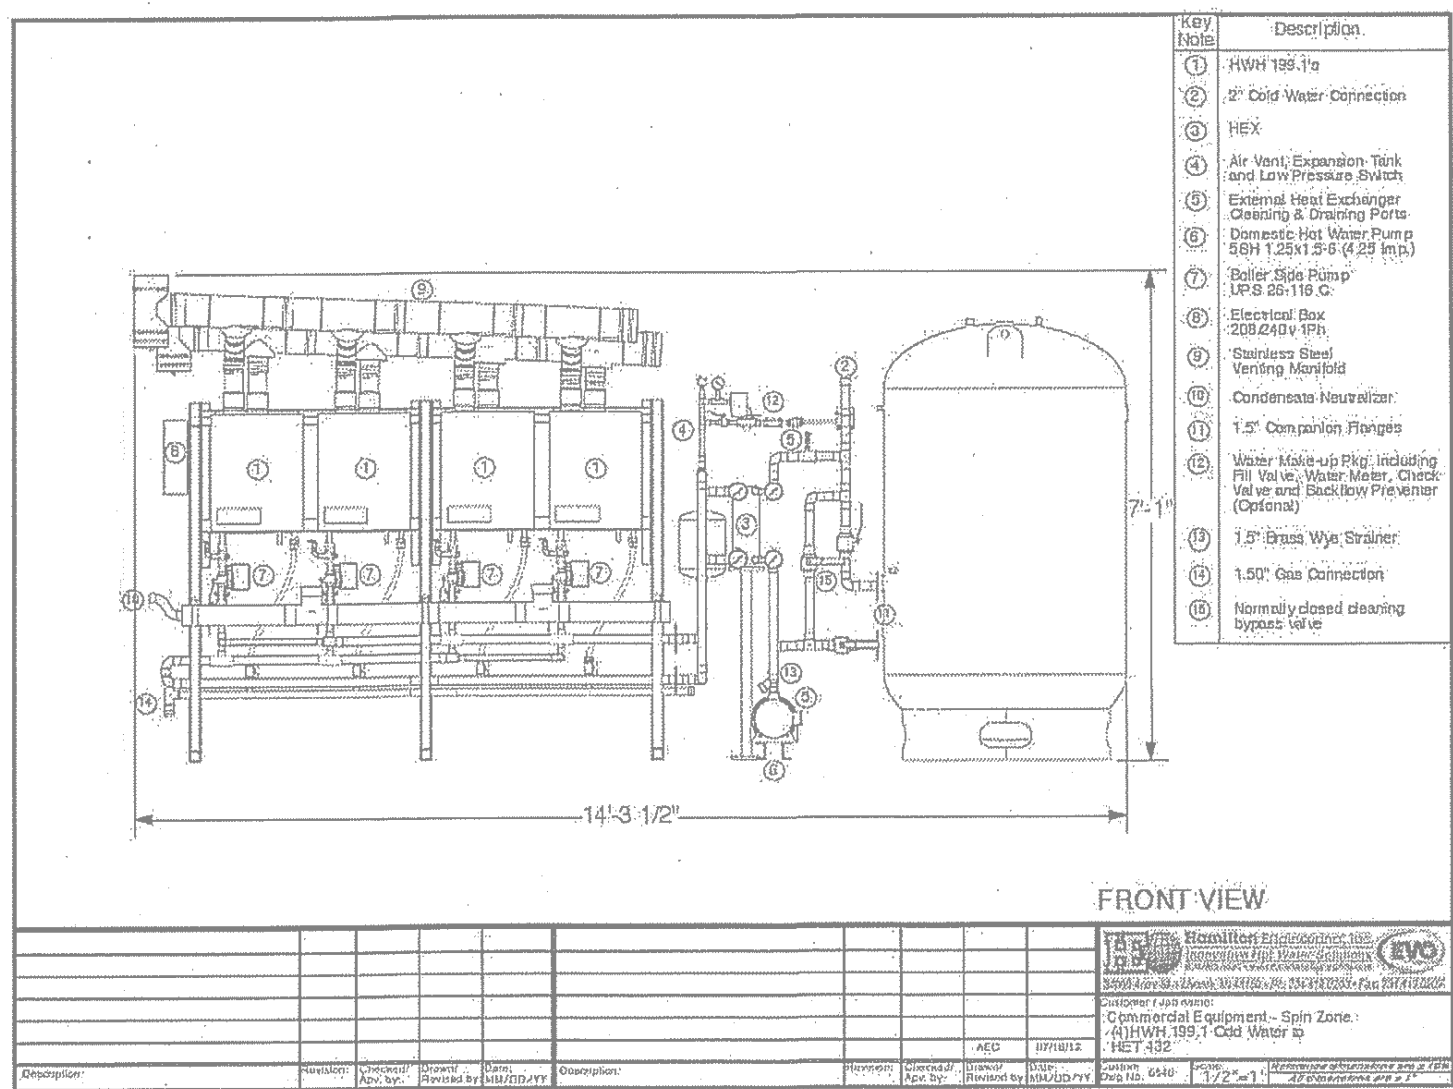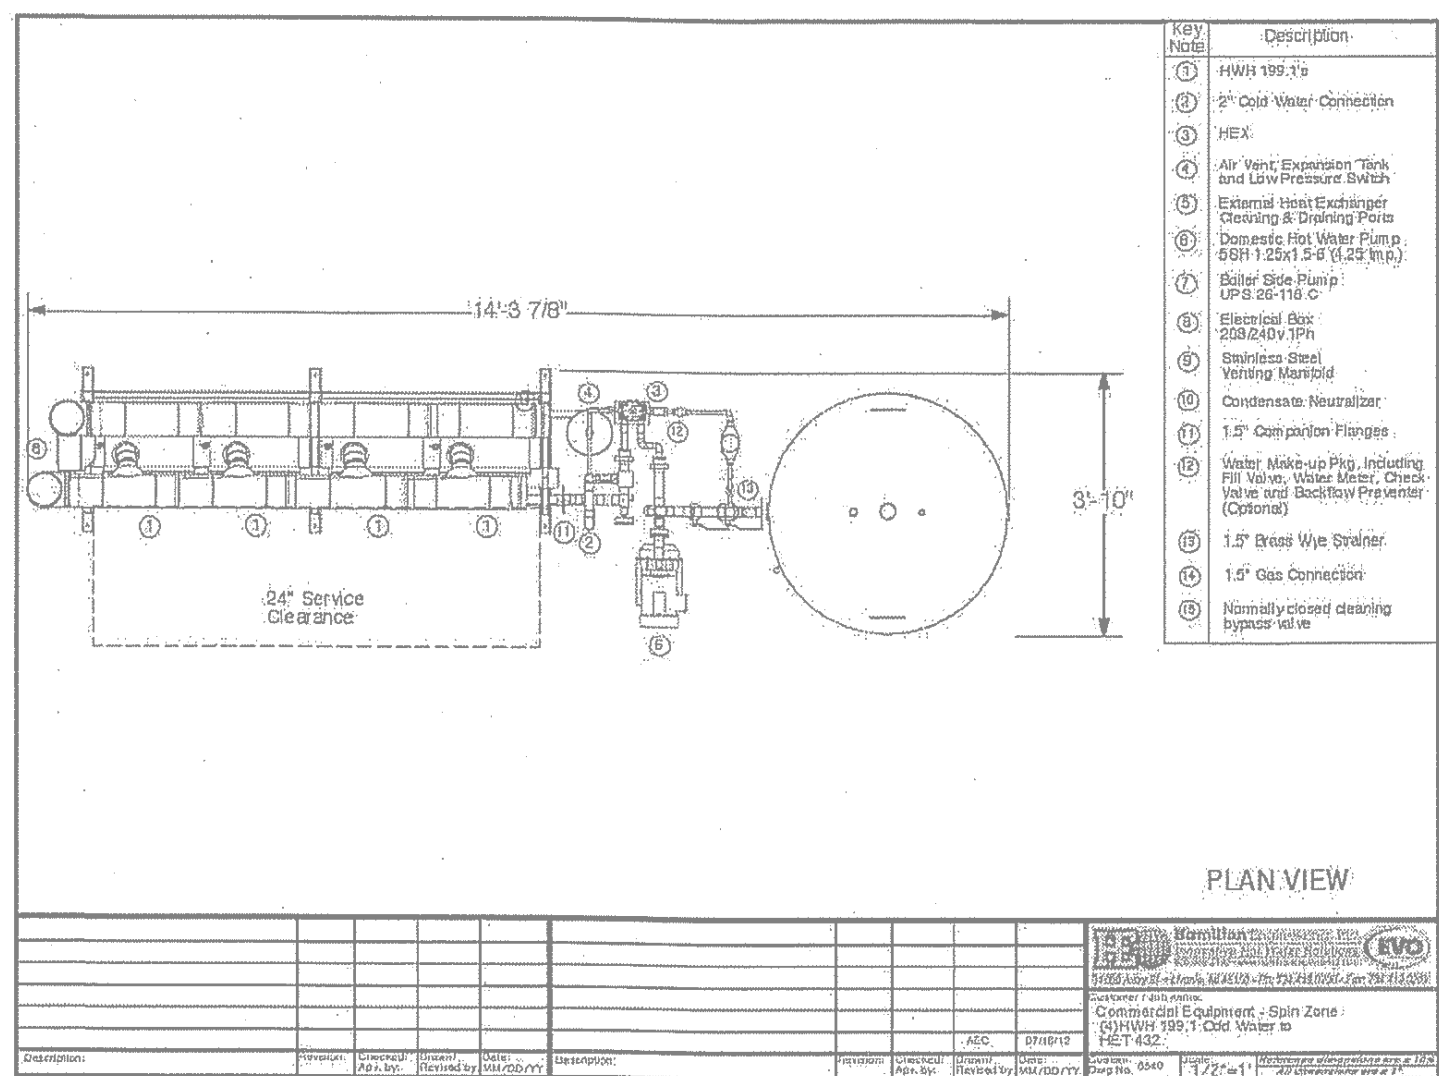

STATE OF TEXAS
STANLEY RAY FAY
53294
REGISTERED PROFESSIONAL ENGINEER
9/23/12
FEES ENGINEERING
(Firm No. F-25311)
1630 Coldwater Hollow
Buda, Texas 78610
(512) 295-9521

McCANN AND ASSOCIATES
2111 DICKSON DRIVE, SUITE #28
AUSTIN, TEXAS 78704
(512) 707-9406



SpinZone SoCo
2424 SOUTH CONGRESS AVE.
AUSTIN, TX 78704
PLUMBING WATER PLAN

JOB No:
12-01


DATE: 09/14/12

DRAWN BY: PSB

SHEET No.
P2 OF 6

©Copyright 2010, McCann & Associates

NOTE: BEFORE PROCEEDING WITH ANY WORK OR ORDERING ANY MATERIALS, THE CONTRACTOR AND/OR SUBCONTRACTOR SHALL VERIFY ALL MEASUREMENTS AND LOCATIONS OF BUILDING COMPONENTS AND THEIR INTERRELATIONSHIP AT THE BUILDING SITE, AND SHALL BE RESPONSIBLE FOR THEIR CORRECTNESS.

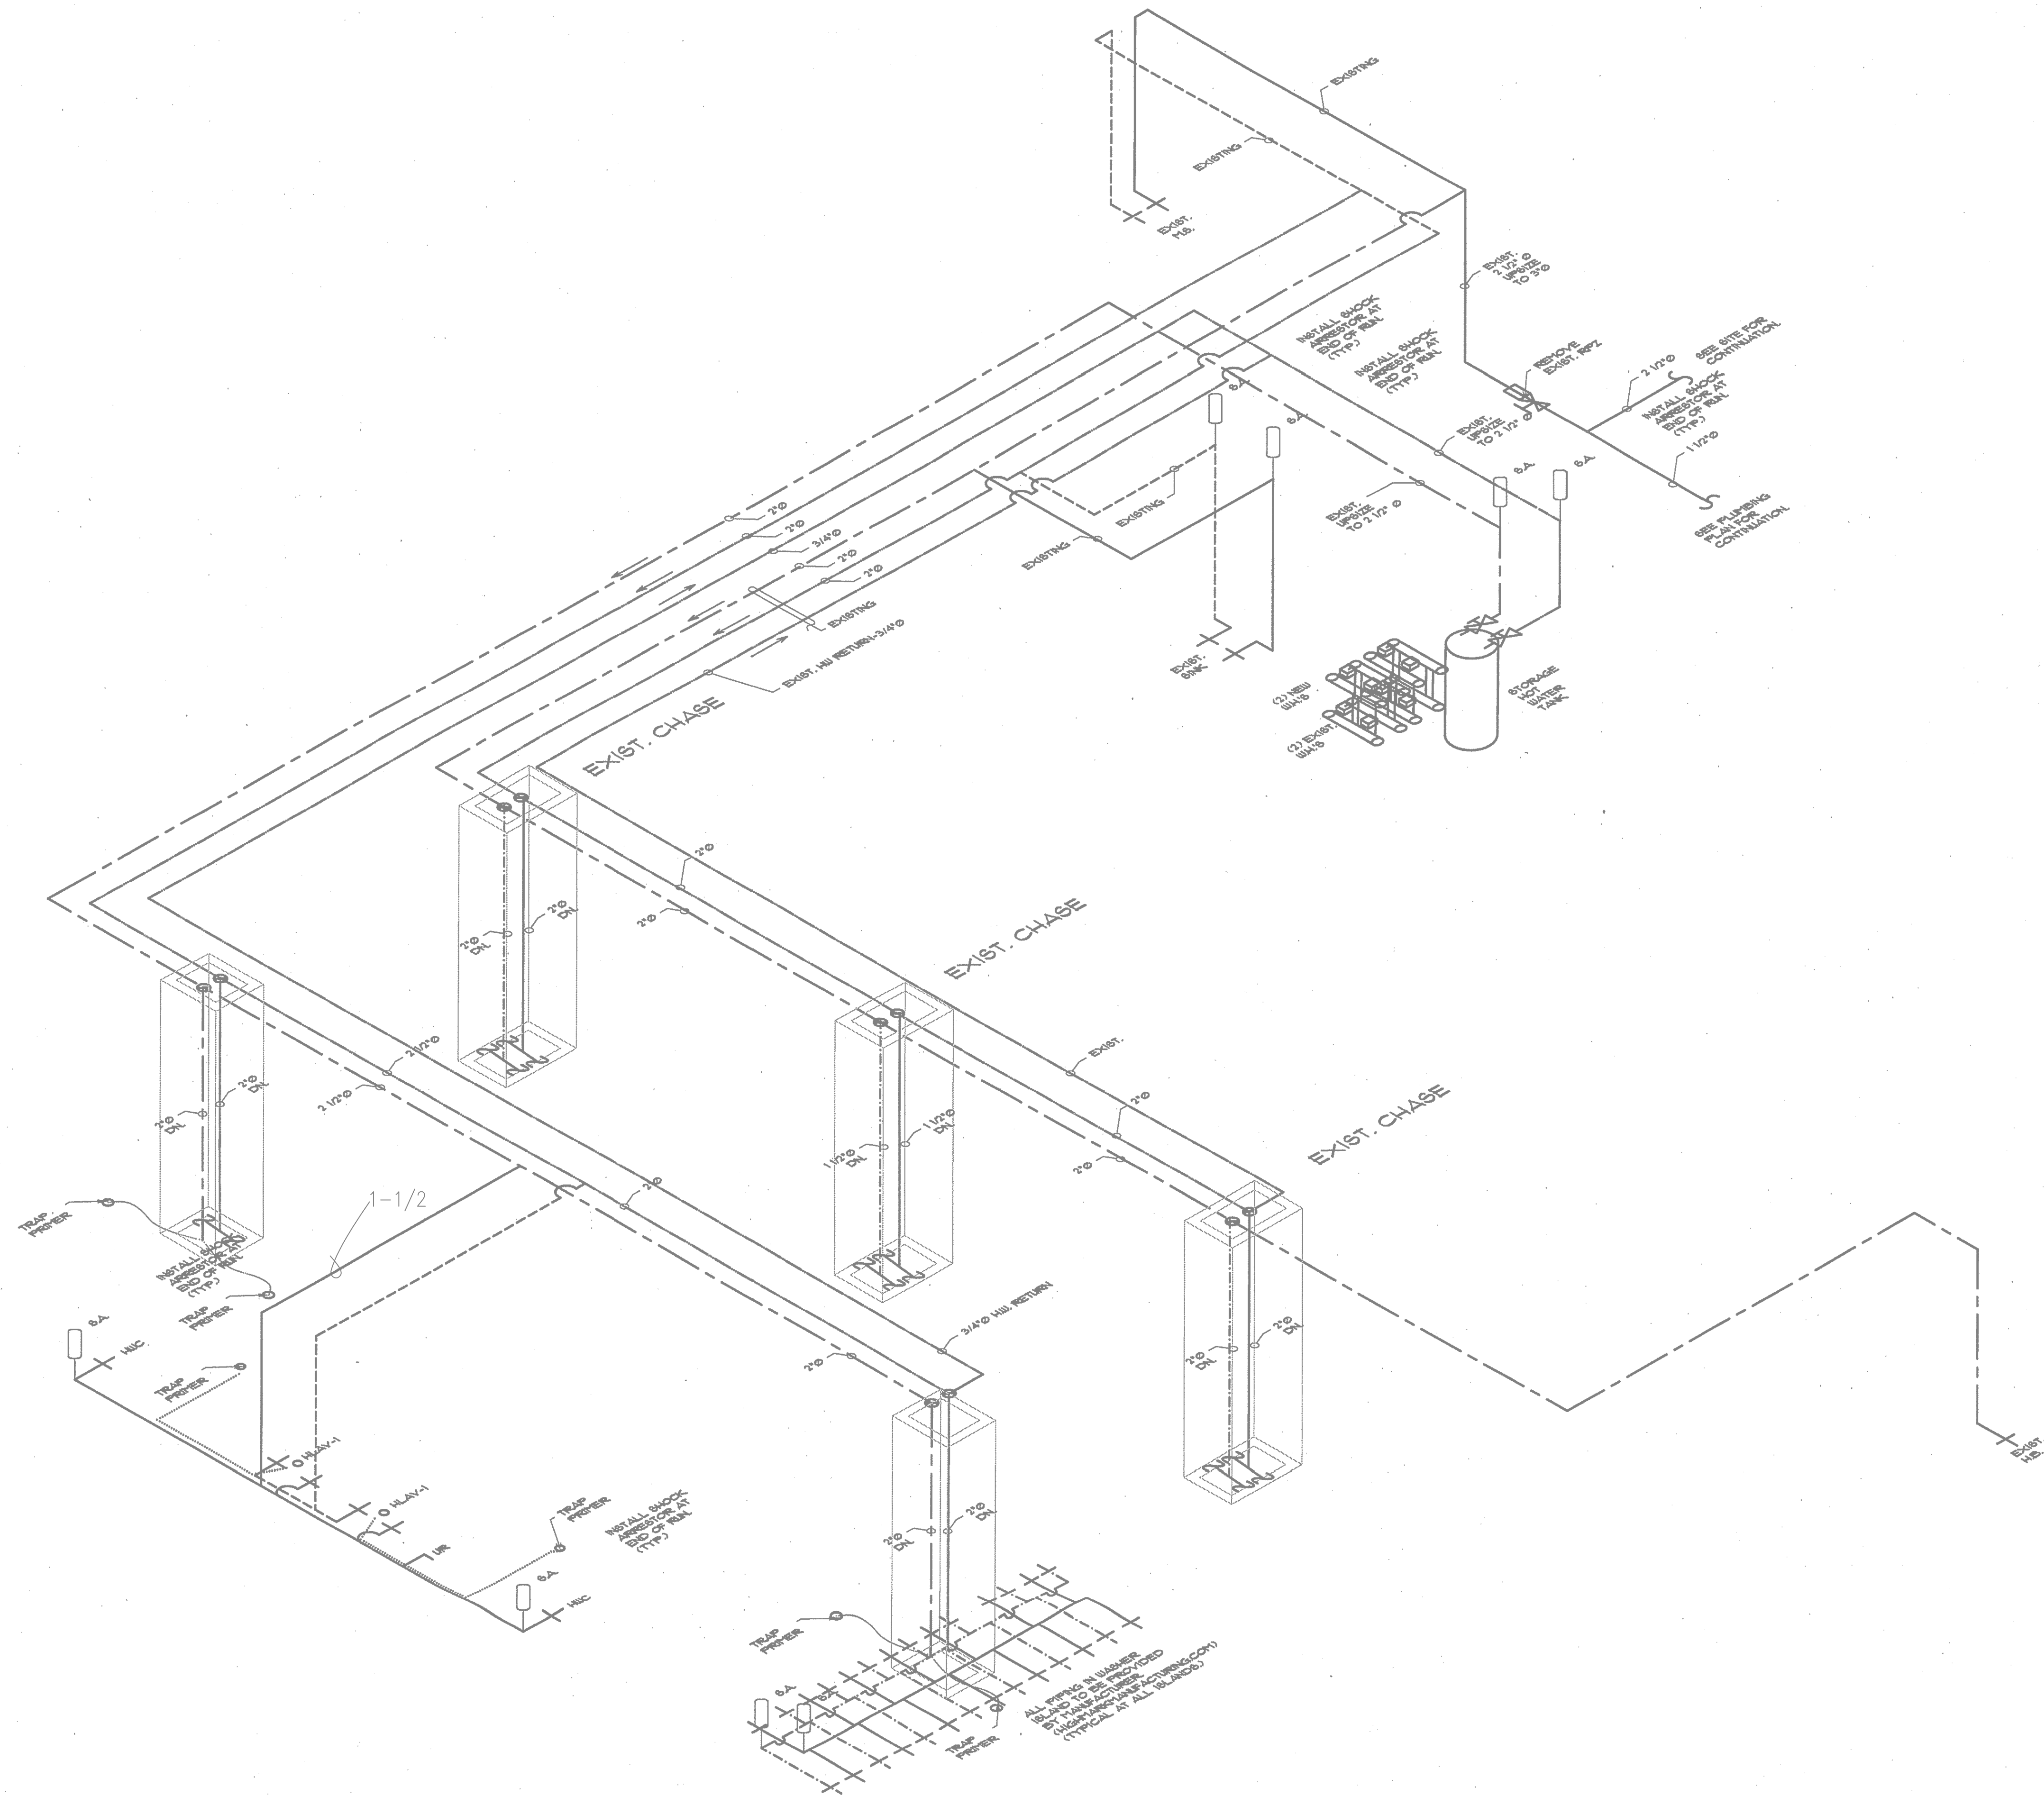

ALL PLUMBING SHALL BE IN ACCORDANCE WITH CITY OF AUSTIN ADOPTED PLUMBING CODES.
REVIEWED *CSW* DATE *10-11-12*
The granting of a permit for, or approval of these plans and specifications shall not be construed to be a permit for, or approval of, any violation of any of the provisions of the currently adopted plumbing code or any other regulations of the City of Austin.

PLUMBING WATER RISER

SC: NTS



FEES ENGINEERING
(Firm No. F-2531)
1630 Coldwater Hollow
Butch, Texas 78610
(512) 258-9221

McCANN AND ASSOCIATES
2111 DICKSON DRIVE, SUITE #28
AUSTIN, TEXAS 78704
(512) 707-9406



SpinZone SoCo
2424 SOUTH CONGRESS AVE.
AUSTIN, TX 78704

PLUMBING WATER RISER

JOB No:


12-01

DATE: 09/14/12

DRAWN BY: PSB

SHEET No.

P5 OF 6

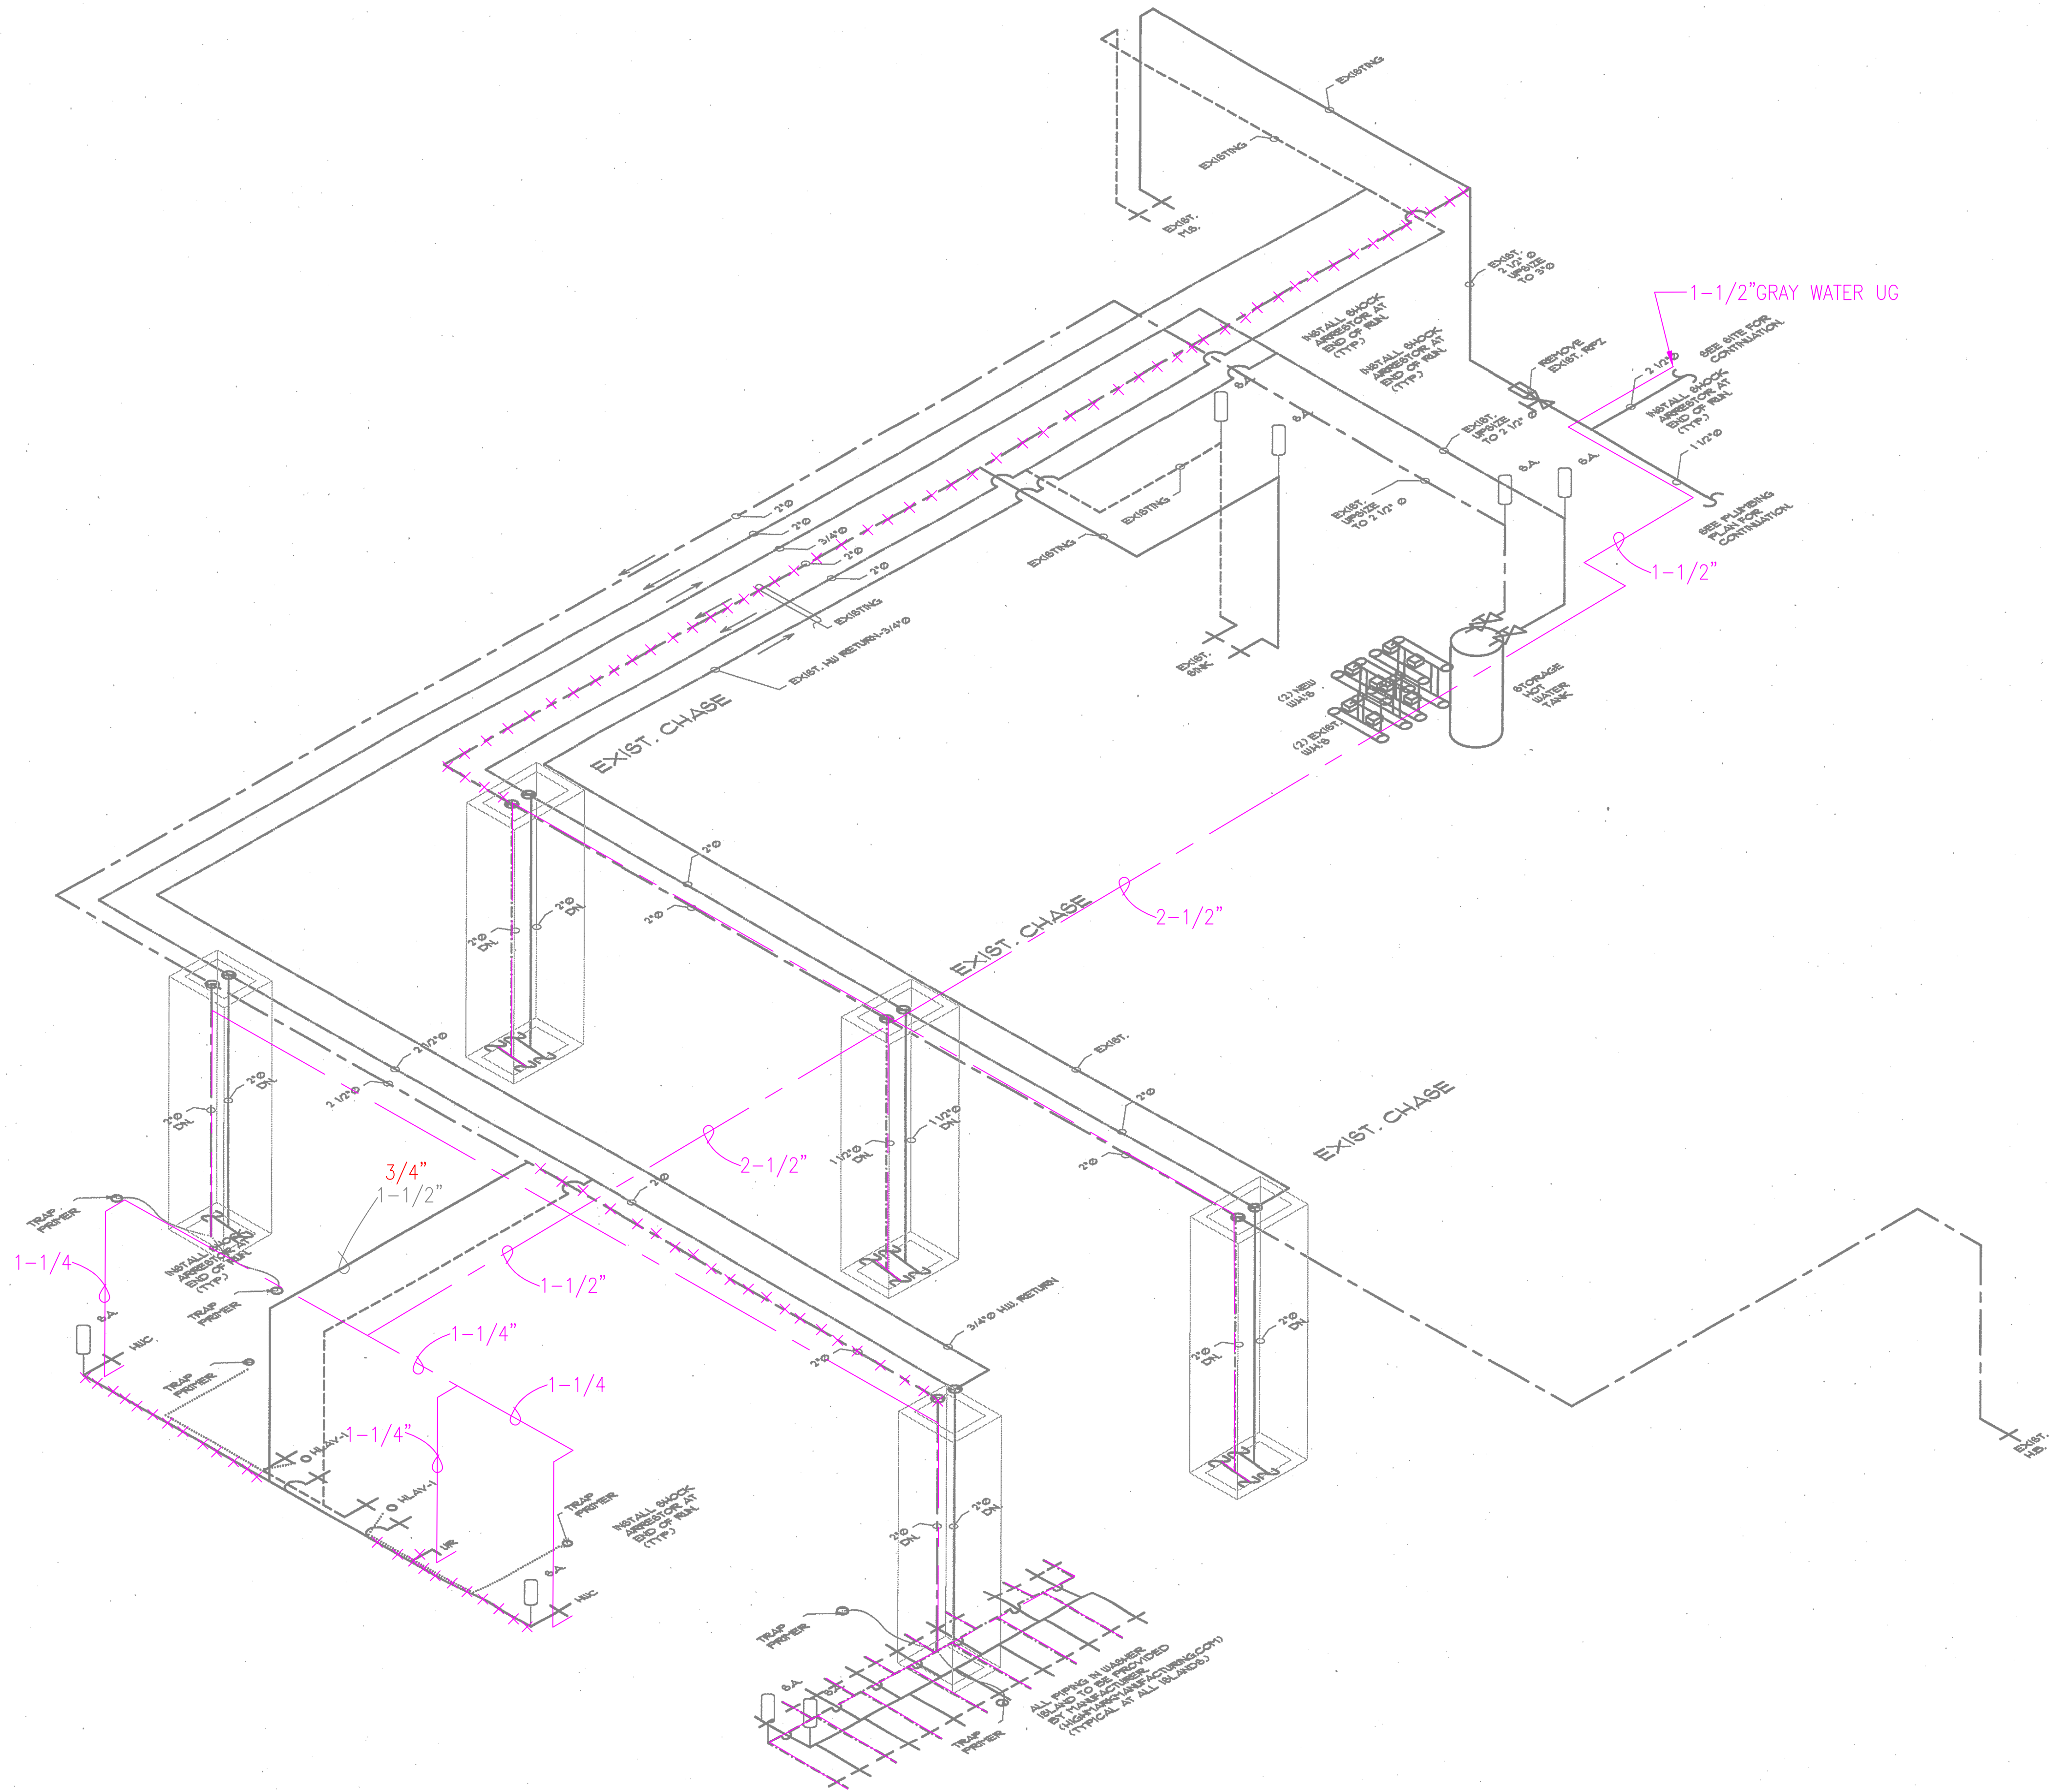

PLUMBING LEGEND

GRAY WATER SUPPLY PIPING

2" DOMESTIC WATER SUPPLY PIPING SIZE REDUCTION

PLUMBING PLAN-WATER LEGEND

EXISTING COLD WATER LINE

COLD WATER LINE

HOT WATER LINE

UNDER SLAB PIPING

EWU EXIST. WASTE WATER LINE

NWU NEW WASTE WATER LINE

FLOOR SINK

RPZ

DOUBLE CHECK VALVE

ALL PLUMBING SHALL BE IN ACCORDANCE WITH CITY OF AUSTIN ADOPTED PLUMBING CODES.
REVIEWED: LSW DATE: 0-11-12
The granting of a permit for, or approval of these plans and specifications shall not be construed to be a permit for, or approval of, any violation of any of the provisions of the currently adopted plumbing code or any other ordinances of the City of Austin.

PLUMBING WATER RISER

SC: NTS

STATE OF TEXAS
STANLEY RAY FEE
63294
REGISTERED PROFESSIONAL ENGINEER

FEE ENGINEERING
(Firm No. F-20531)
1630 Coldwater Hollow
Buda, Texas 78610
(512) 295-8521

McCANN AND ASSOCIATES
2111 DICKSON DRIVE, SUITE #28
AUSTIN, TEXAS 78704
(512) 707-9406

spinZONE

SpinZone SoCo
2424 SOUTH CONGRESS AVE.
AUSTIN, TX 78704

PLUMBING WATER RISER

JOB No:
12-01

DATE: 09/14/12

DRAWN BY: PSB

SHEET No.
P5 OF 6

NOTE: BEFORE PROCEEDING WITH ANY WORK OR ORDERING ANY MATERIALS, THE CONTRACTOR AND/OR SUBCONTRACTOR SHALL VERIFY ALL MEASUREMENTS AND LOCATIONS OF BUILDING COMPONENTS AND THEIR INTERRELATIONSHIP AT THE BUILDING SITE, AND SHALL BE RESPONSIBLE FOR THEIR CORRECTNESS.