



**TYOLOGY 3**  
Single Family Estate Home


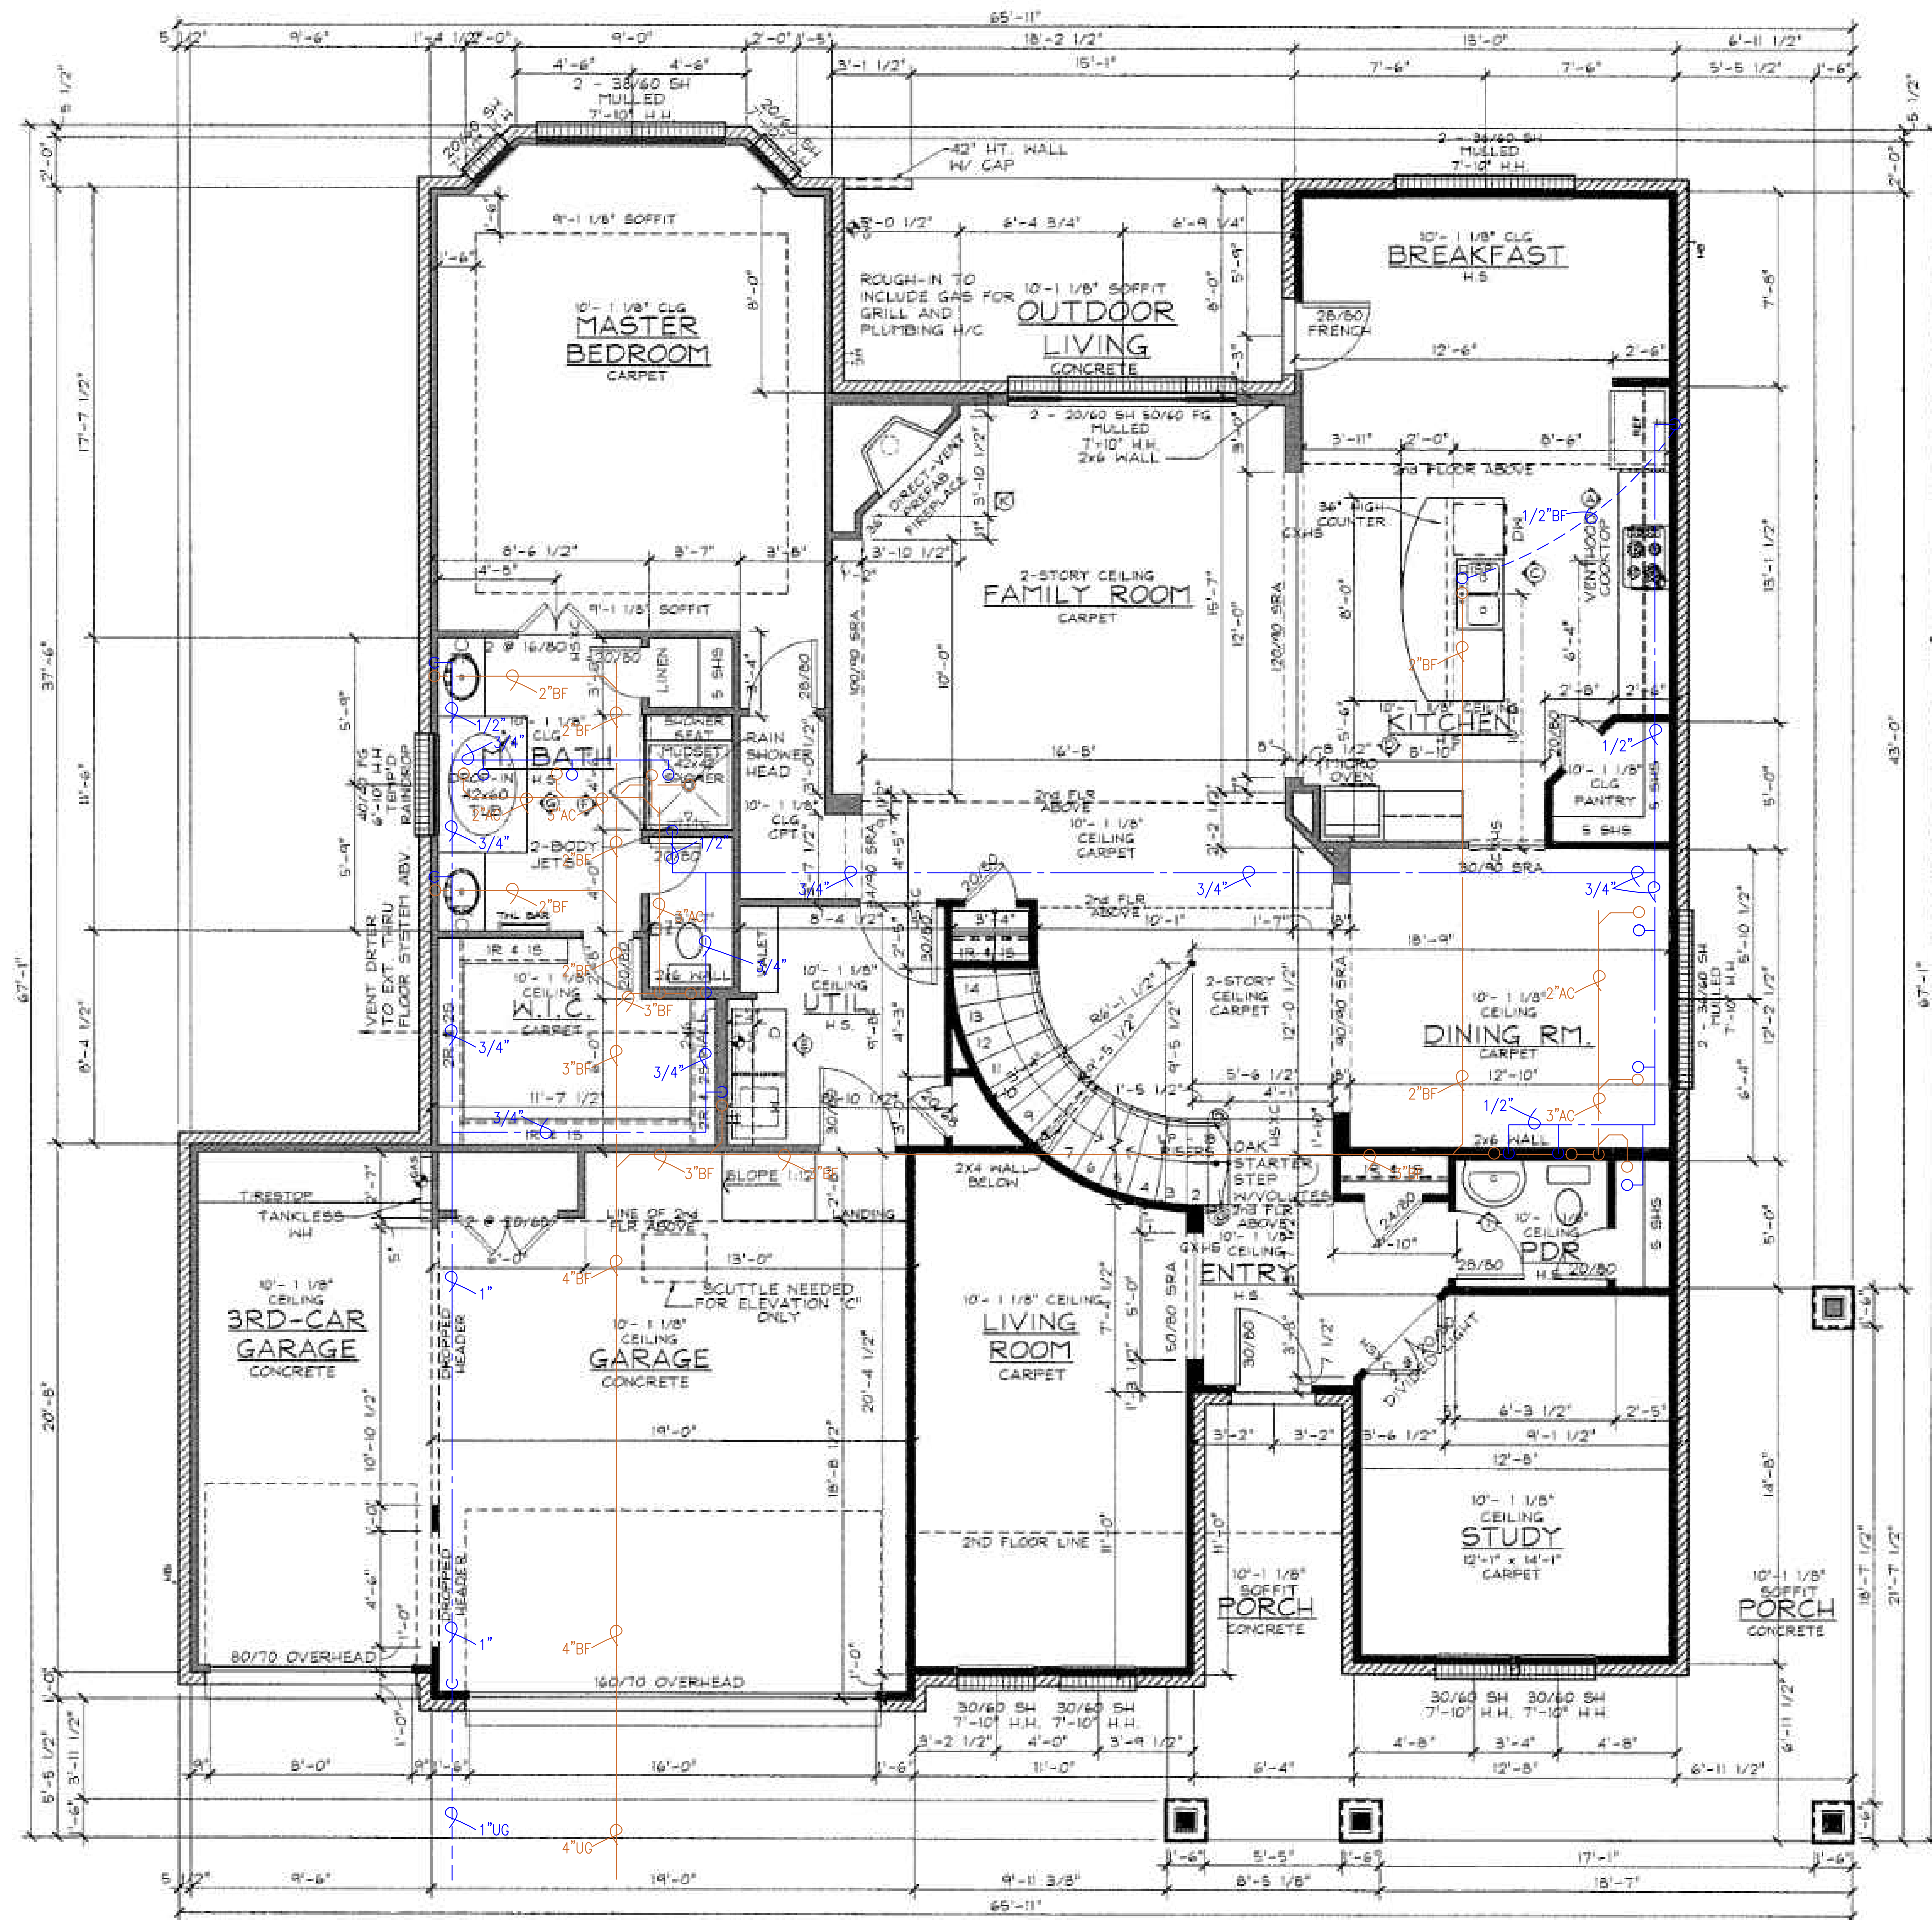


PLUMBING LEGEND	
	DOMESTIC WATER SUPPLY PIPING
	BLACK WATER WASTE PIPING

 

FIRST FLOOR PLAN

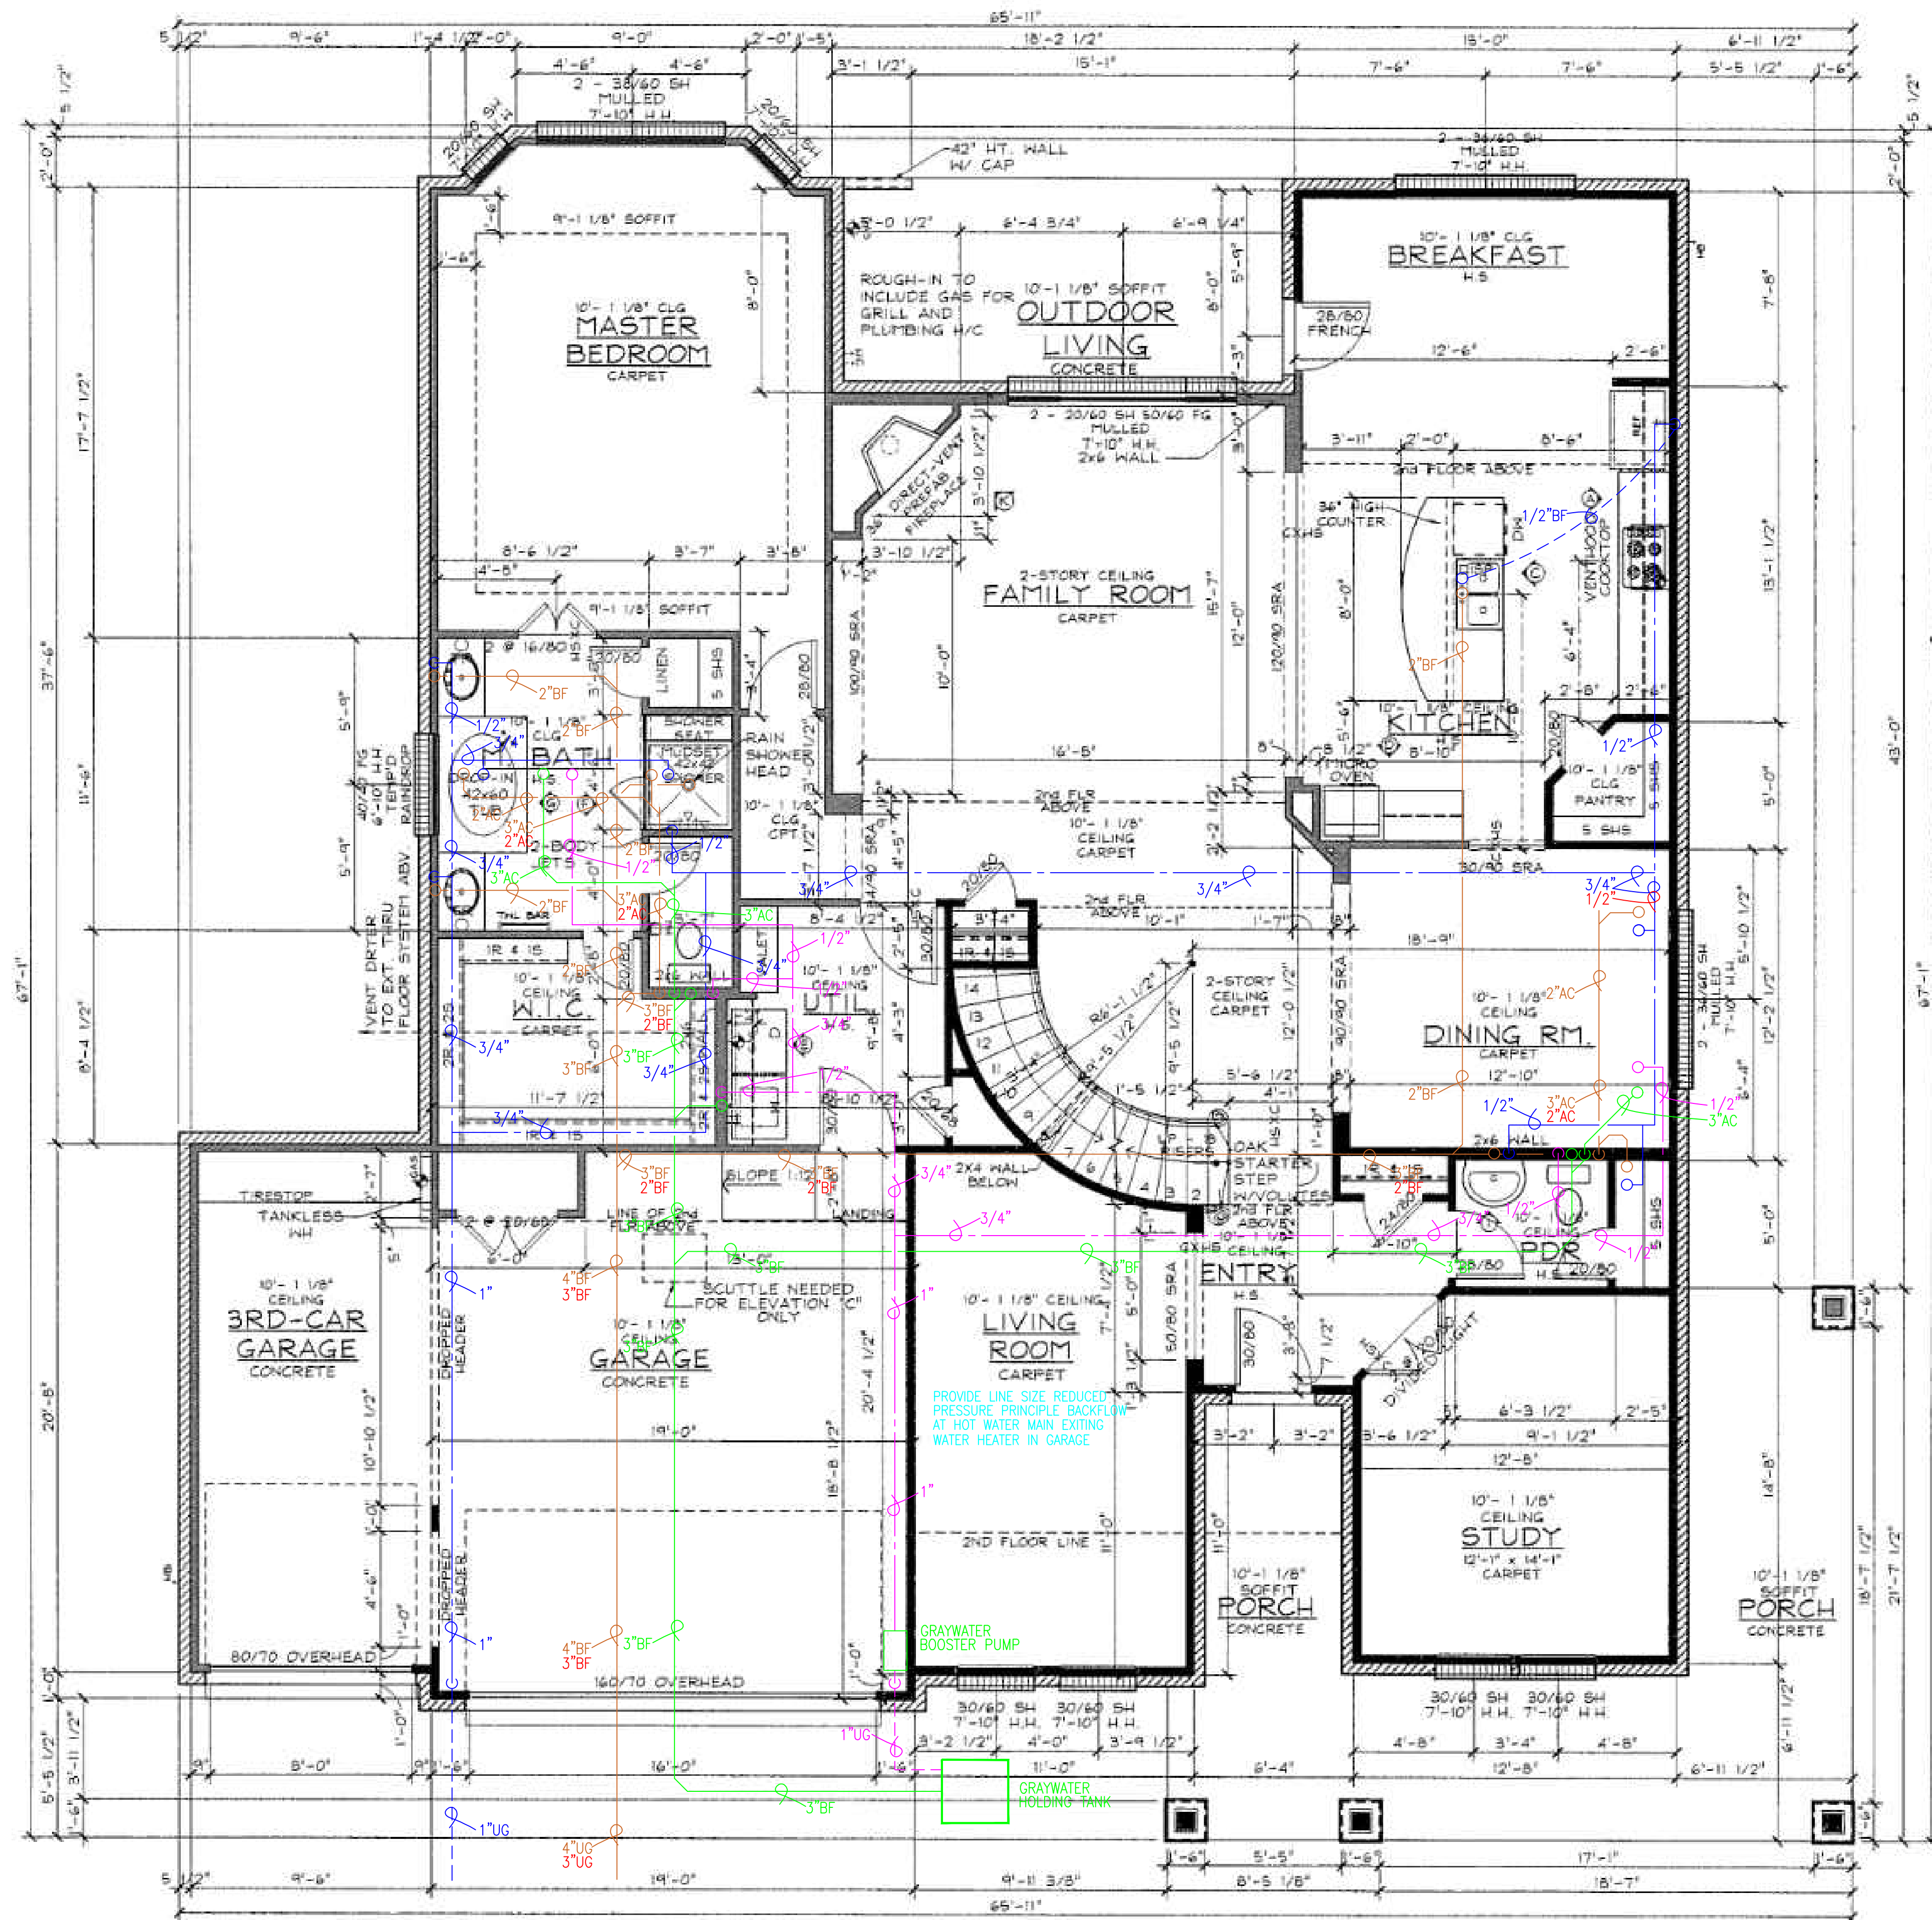


FIRST FLOOR PLAN

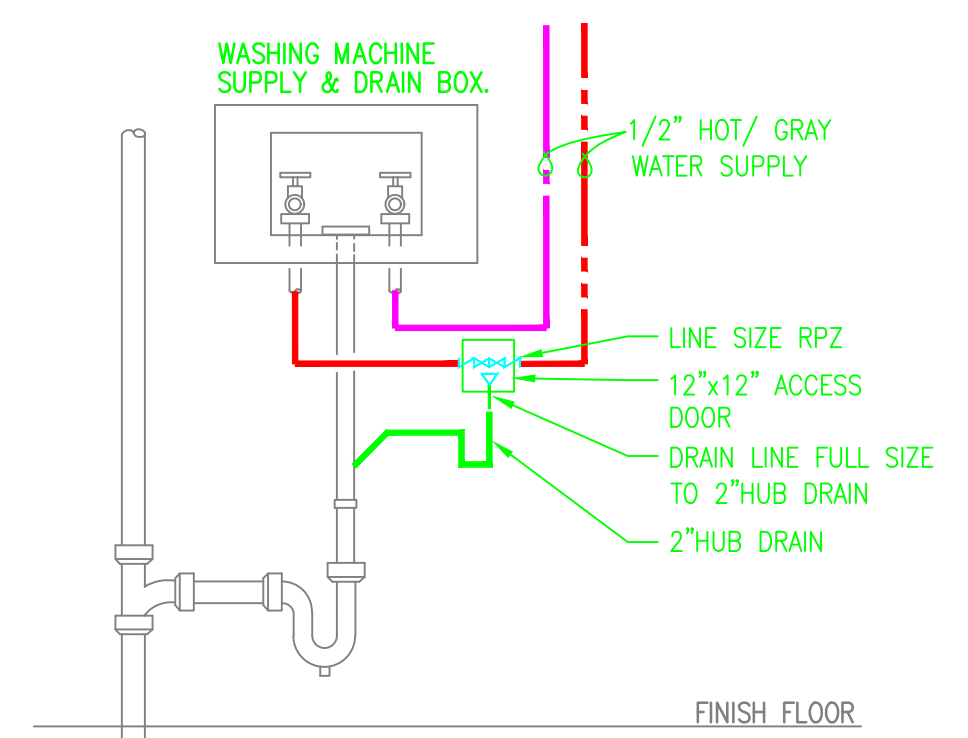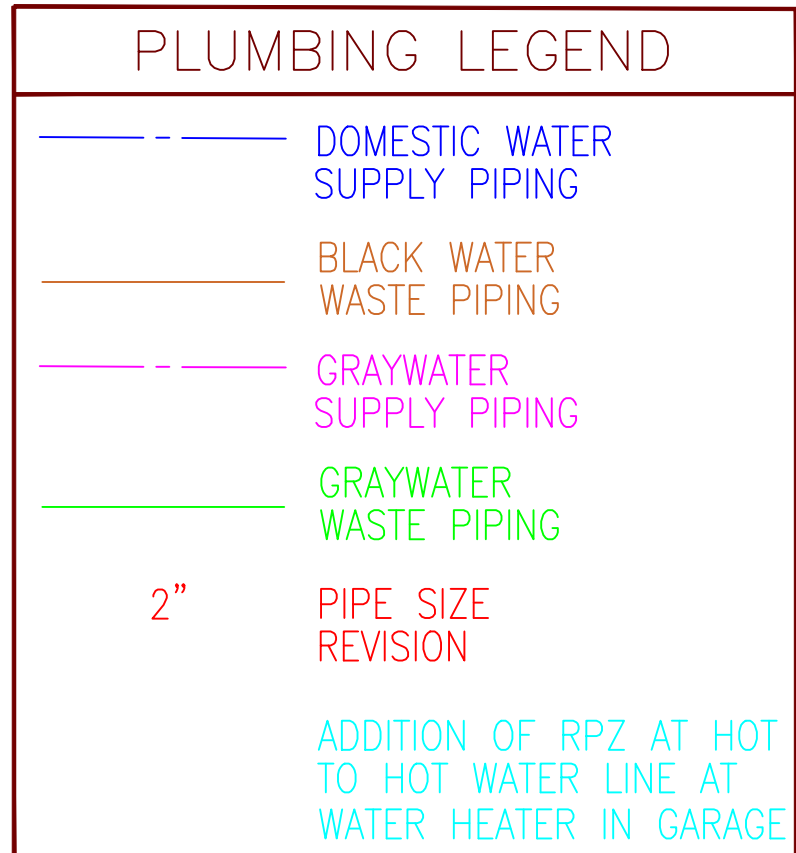


RPZ/HUB DRAIN @ WASHER BOX  
SCALE: NOT TO SCALE

PLUMBING LEGEND	
	DOMESTIC WATER SUPPLY PIPING
	BLACKWATER WASTE PIPING

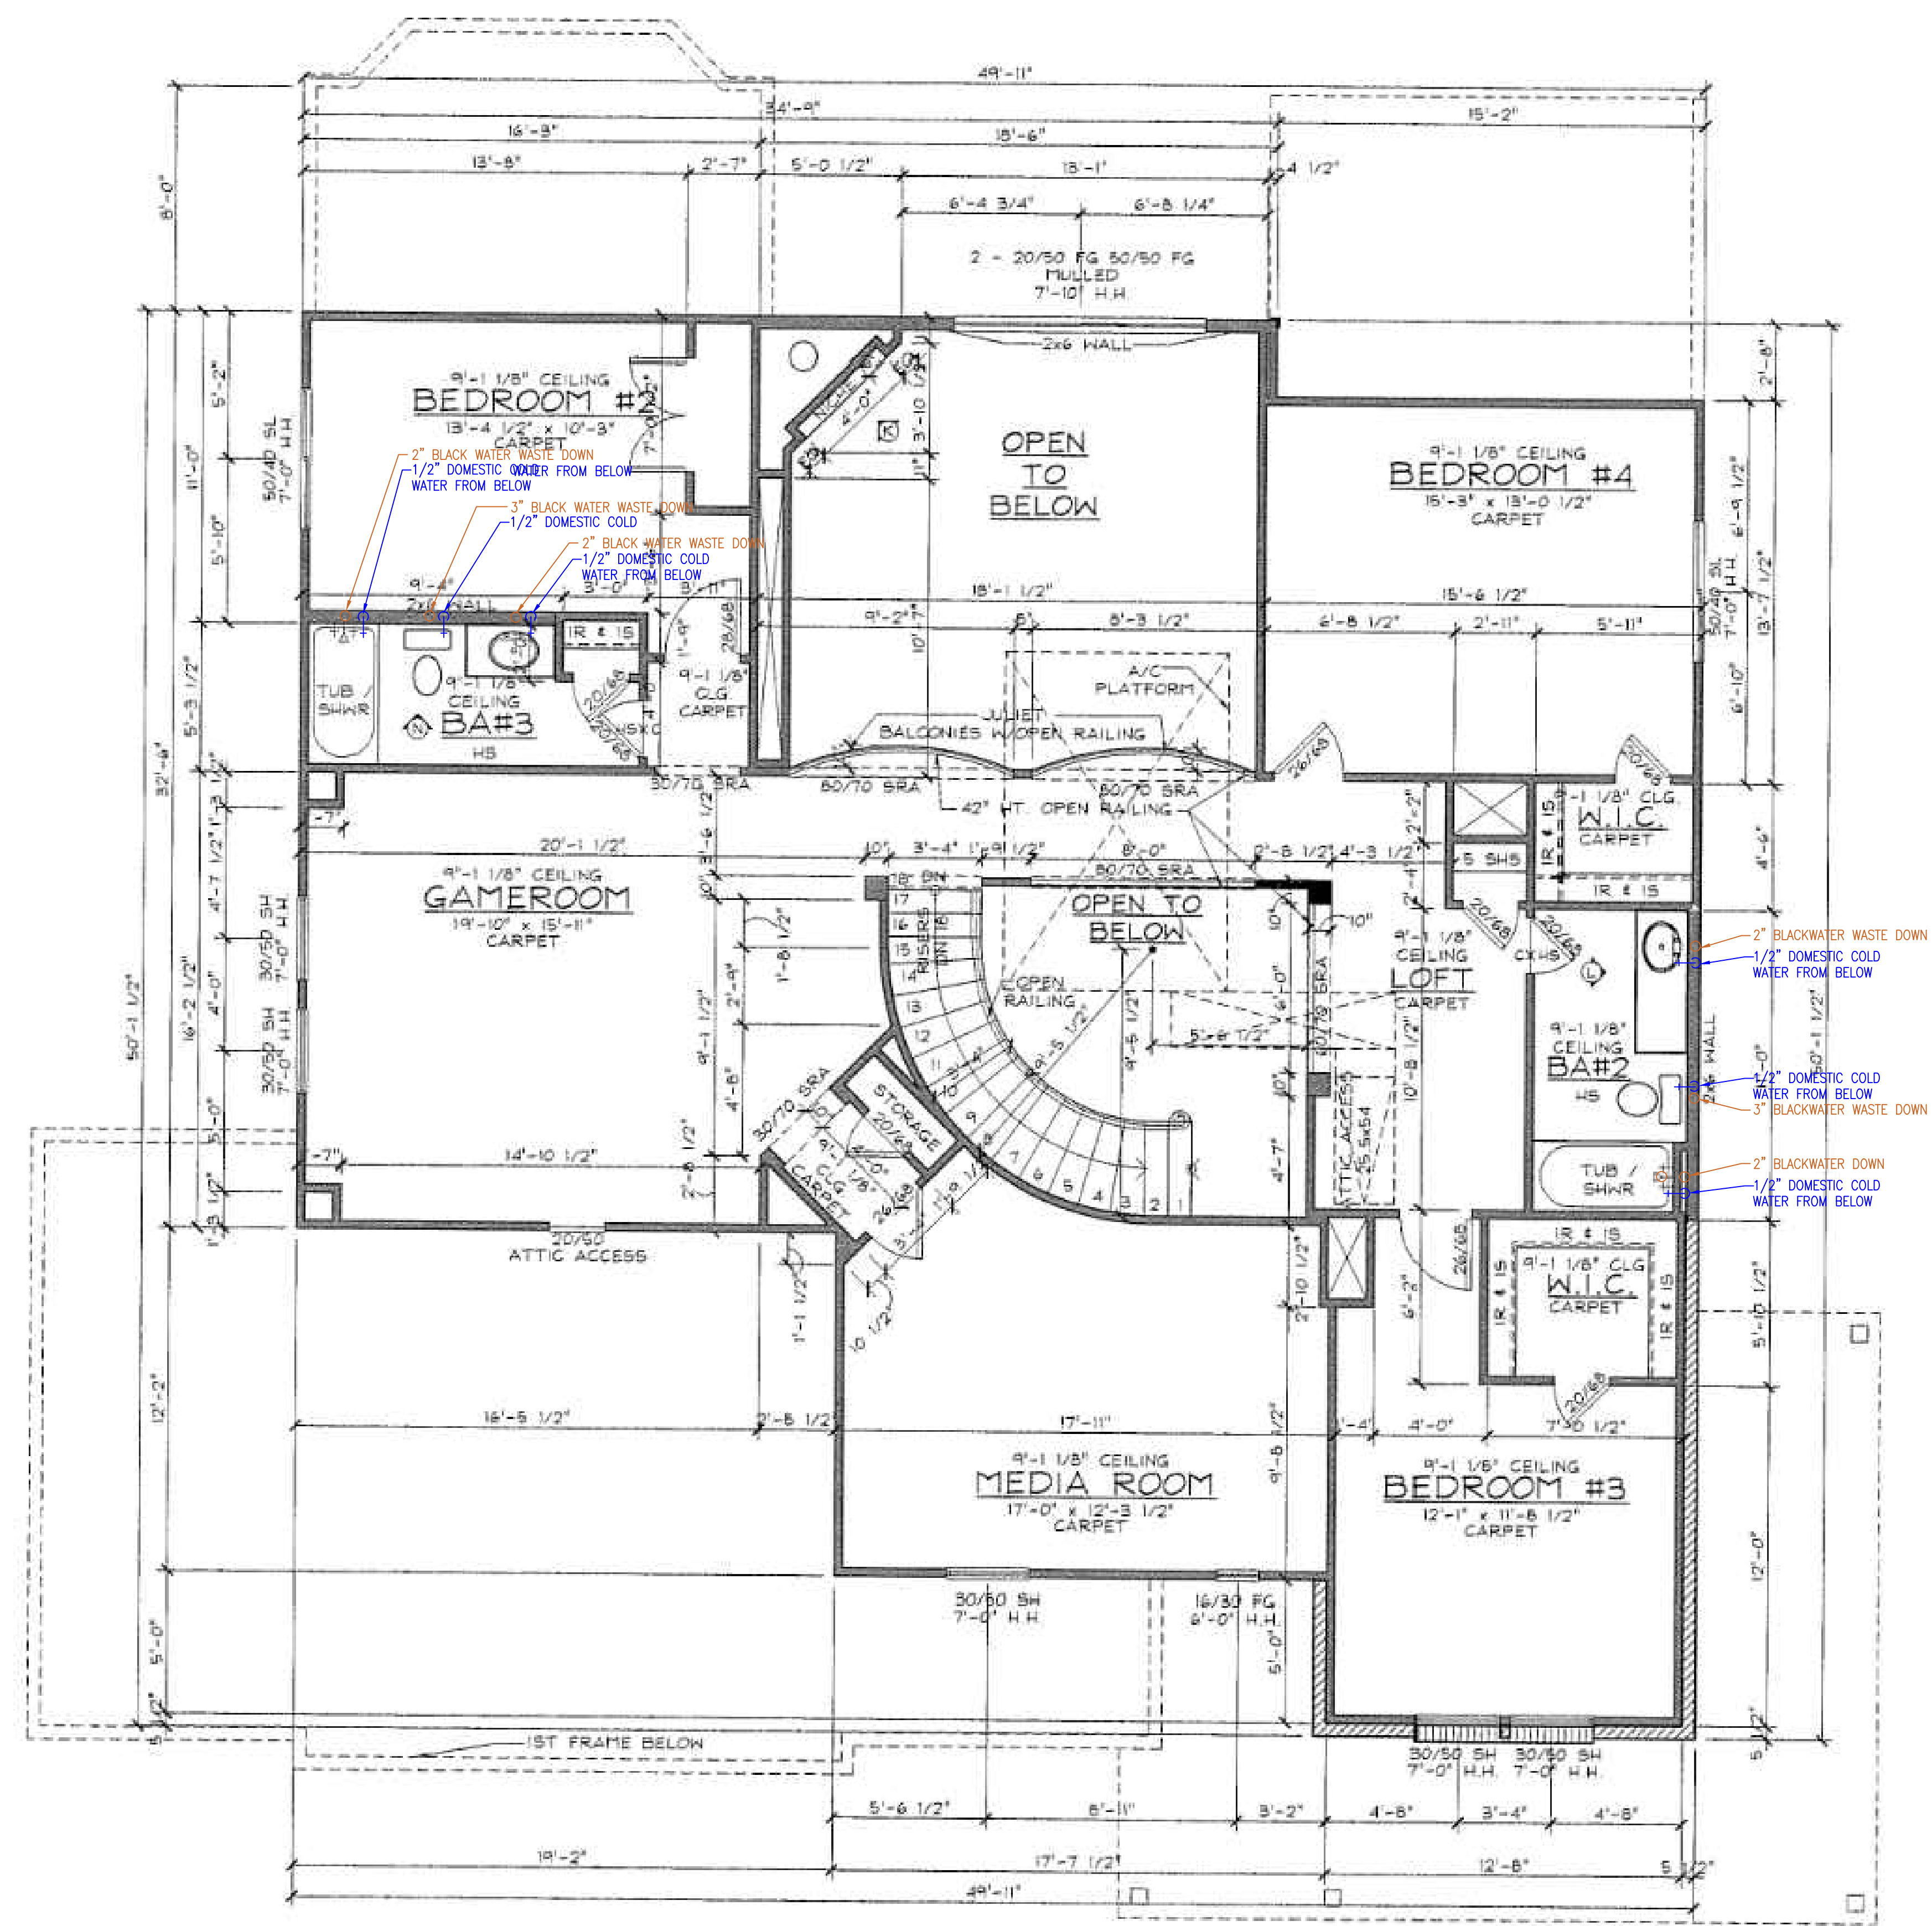

SECOND FLOOR PLAN

PLUMBING LEGEND	
	DOMESTIC WATER SUPPLY PIPING
	BLACK WATER WASTE PIPING
	GRAYWATER SUPPLY PIPING
	GRAYWATER WASTE PIPING
2"	PIPE SIZE REVISION

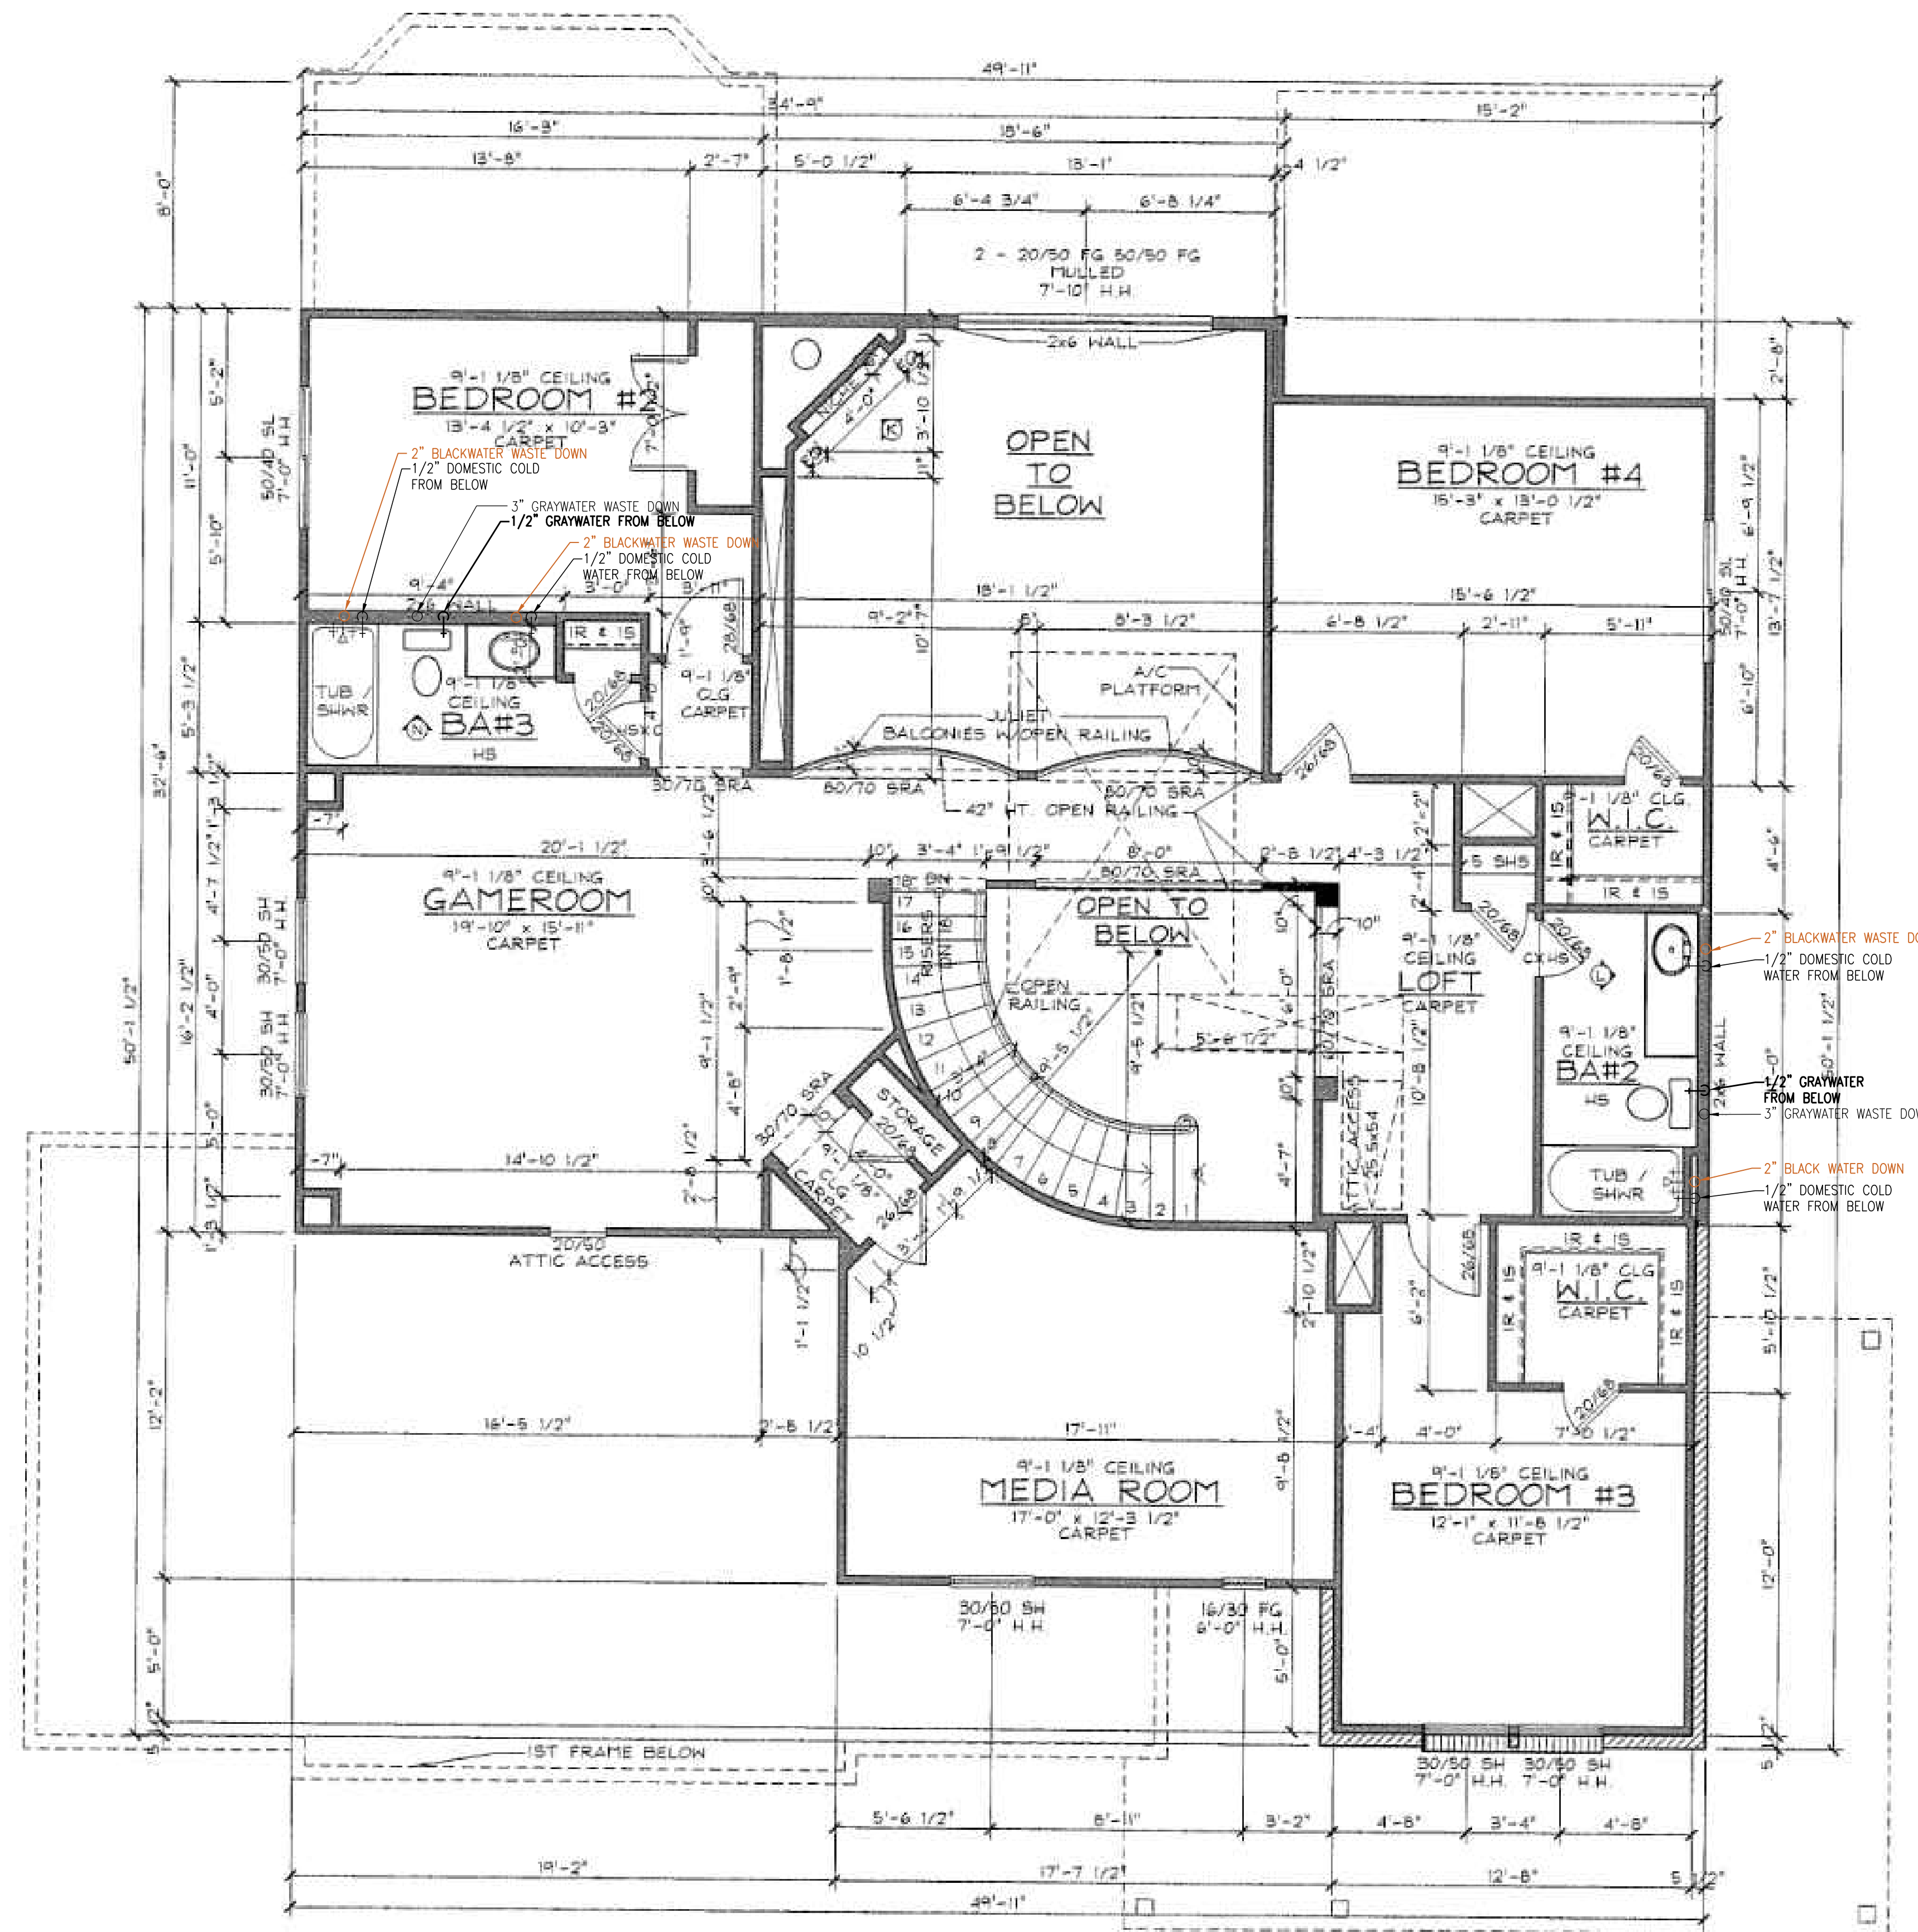

SECOND FLOOR PLAN